


FT	FLOOR TRAP
FD	FLOOR DRAIN
(F)	40Ø FLUSHING WATER SUPPLY
(HR)	40Ø HOT WATER RETURN PIPE
(H)	50Ø HOT WATER SUPPLY PIPE
(D)	50Ø DOMESTIC WATER SUPPLY
(R)	110 Ø UPVC RAIN WATER PIPE
(3)	75 Ø ANTI-SIPHONAGE PIPE
(2)	110 Ø UPVC WASTE & VENT PIPE
(1)	110 Ø UPVC SOIL & VENT PIPE

PLUMBING LEGEND:-

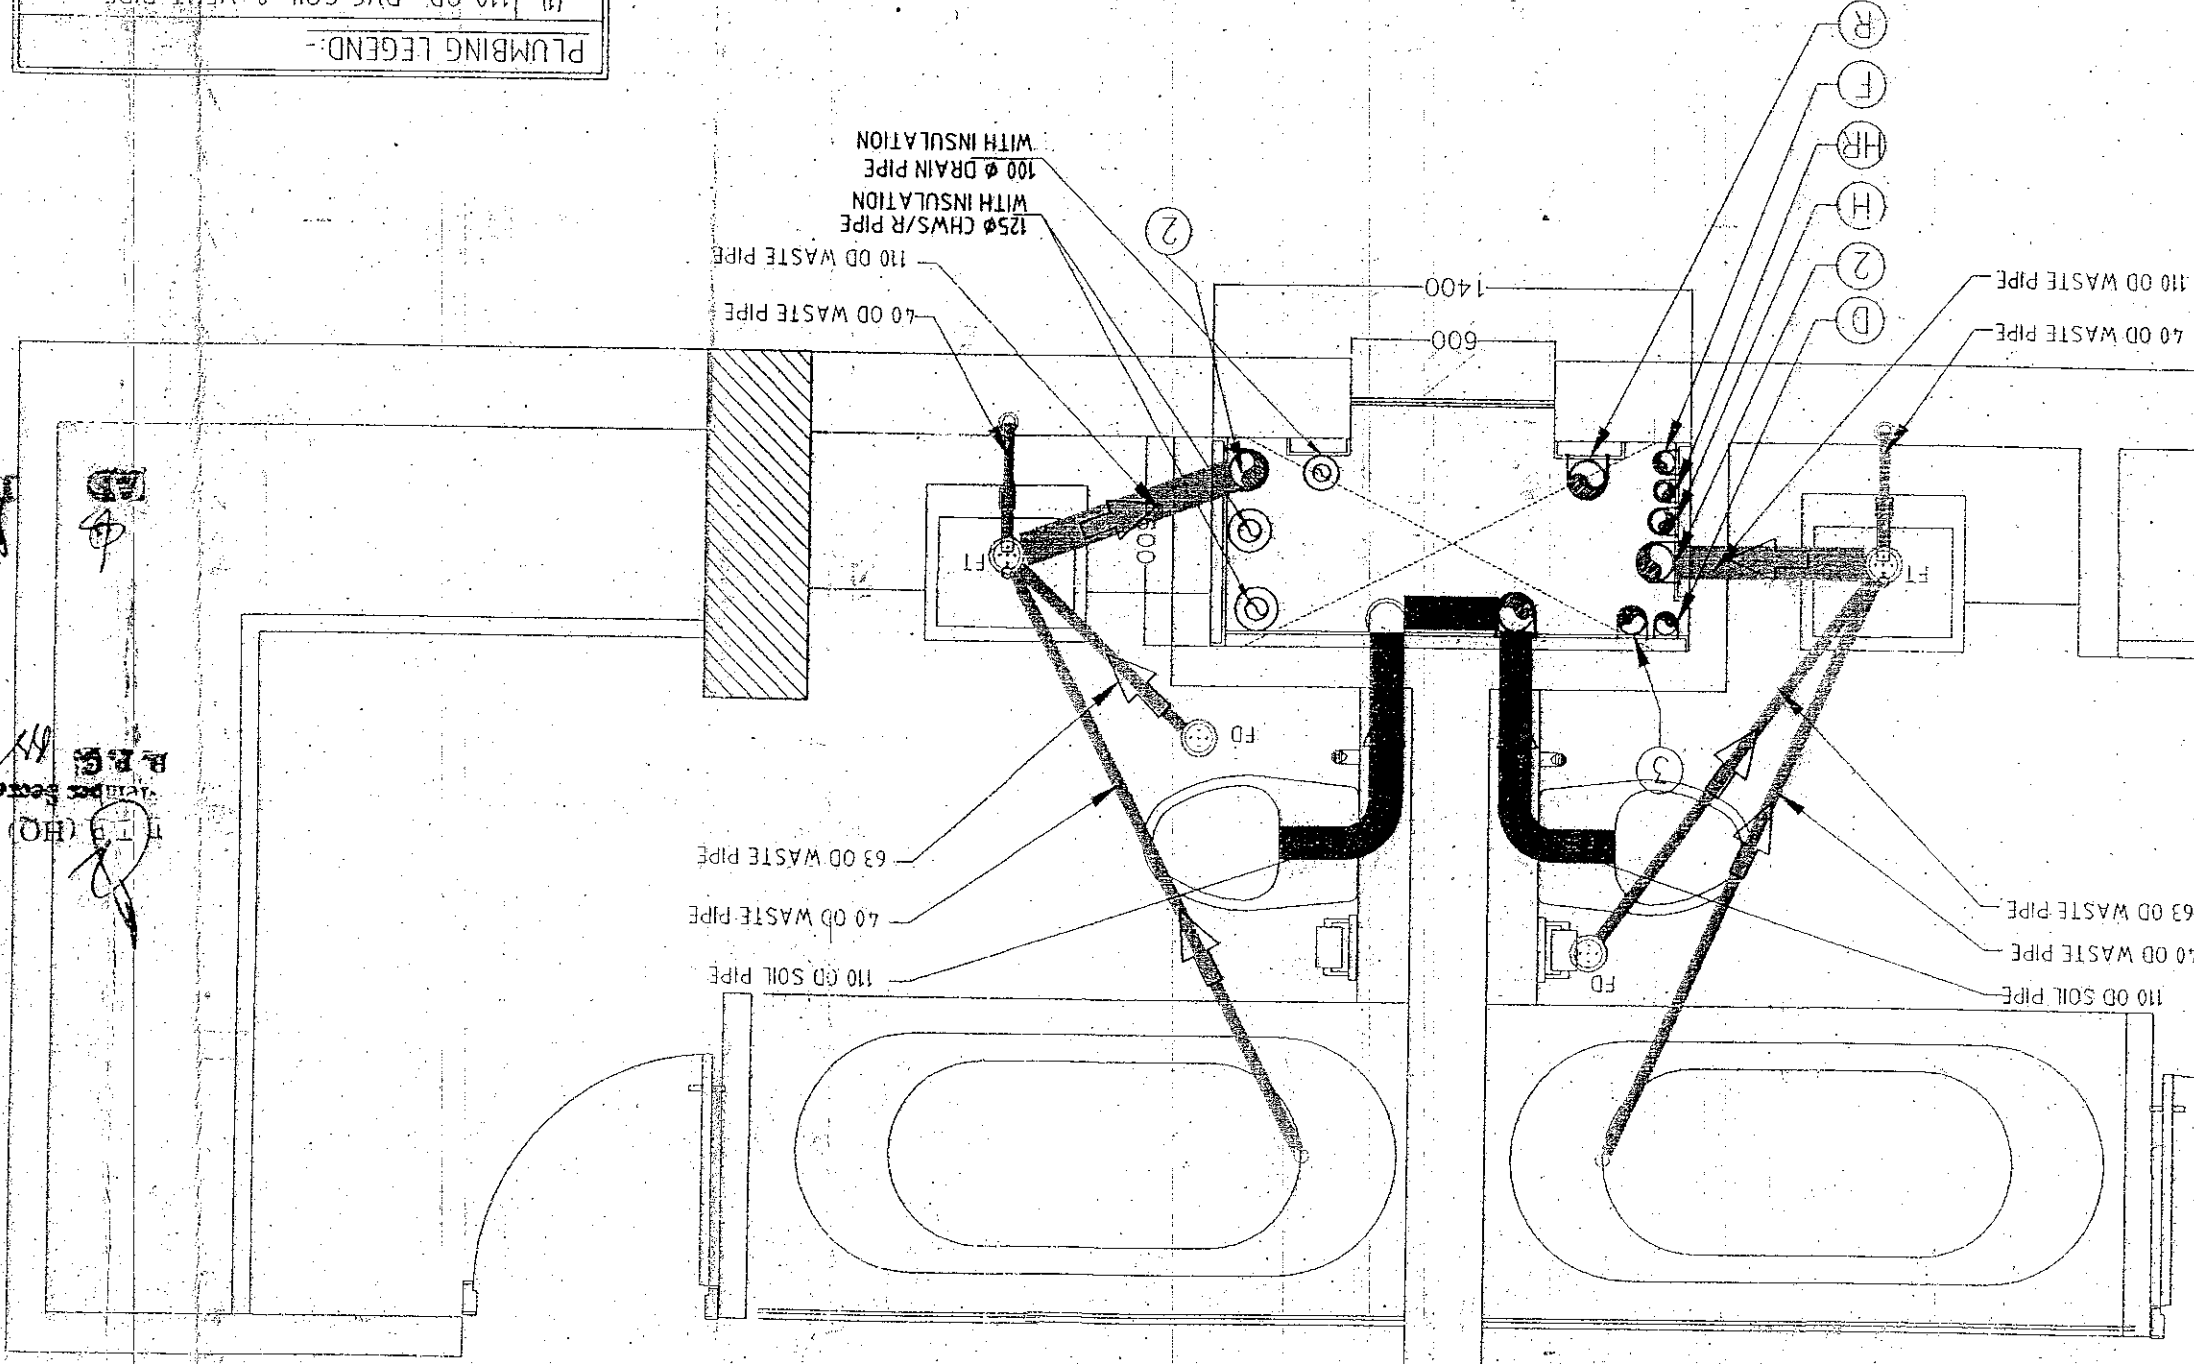

Notes:

- 1) ALL FIXTURE PROVIDED IN TOILETS ARE AS PER M.A.C.
- 2) ALL SPACES OFFICE, PARKING BASEMENT, SERVICES BASEMENT ETC) WILL BE PROVIDED FOR THE ELECTRICAL REQUIREMENT OF THE TOTAL SCHEME. THIS REQUIREMENT INCLUDES STANDBY GENERATION FOR ALL COMMON SERVICES, FIRE SERVICES, LIFTS ETC. AND ALSO THE ENTIRE ELECTRICAL LOAD FOR THE VENTILATION. THIS BUILDING SHALL BE SPRINKLERED.
- 3) FIRE SAFETY MEASURES AS/AND INCLUDES:
 - SMOKE DETECTOR - GM C/C (WHEREVER REQUIRED)
 - SPRINKLER JET C/C (WHEREVER REQUIRED)
 - HEAT DETECTOR - GM C/C (WHEREVER REQUIRED)

Key Plan

S.T.P. (G) C.T.P. (H) Member B.P.C. Chairman B.P.C.

Project

Proposed Commercial Colony measuring 2.968 acres in Sec. 14, Gurgaon. Major Urban Colony being developed by M/S AND ESTATE AND DEVELOPERS PVT. LTD. A-22, HBI View Apartments, Vasant Vihar, New Delhi 110057

Architect's Sign

Drawing Title
TOILET DETAIL
TYPICAL APARTMENT FLOOR

Sanction -

Drawing No. 11-240-PL-D101

Scale

Date 10-10-2011

North

Morphogenesis
E-Work: studio@morphogenesis.org
TEL: 91 11 41220070 FAX: 91 11 26490351

Stamp: GUJRAJEET SINGH CA/2006/38929