

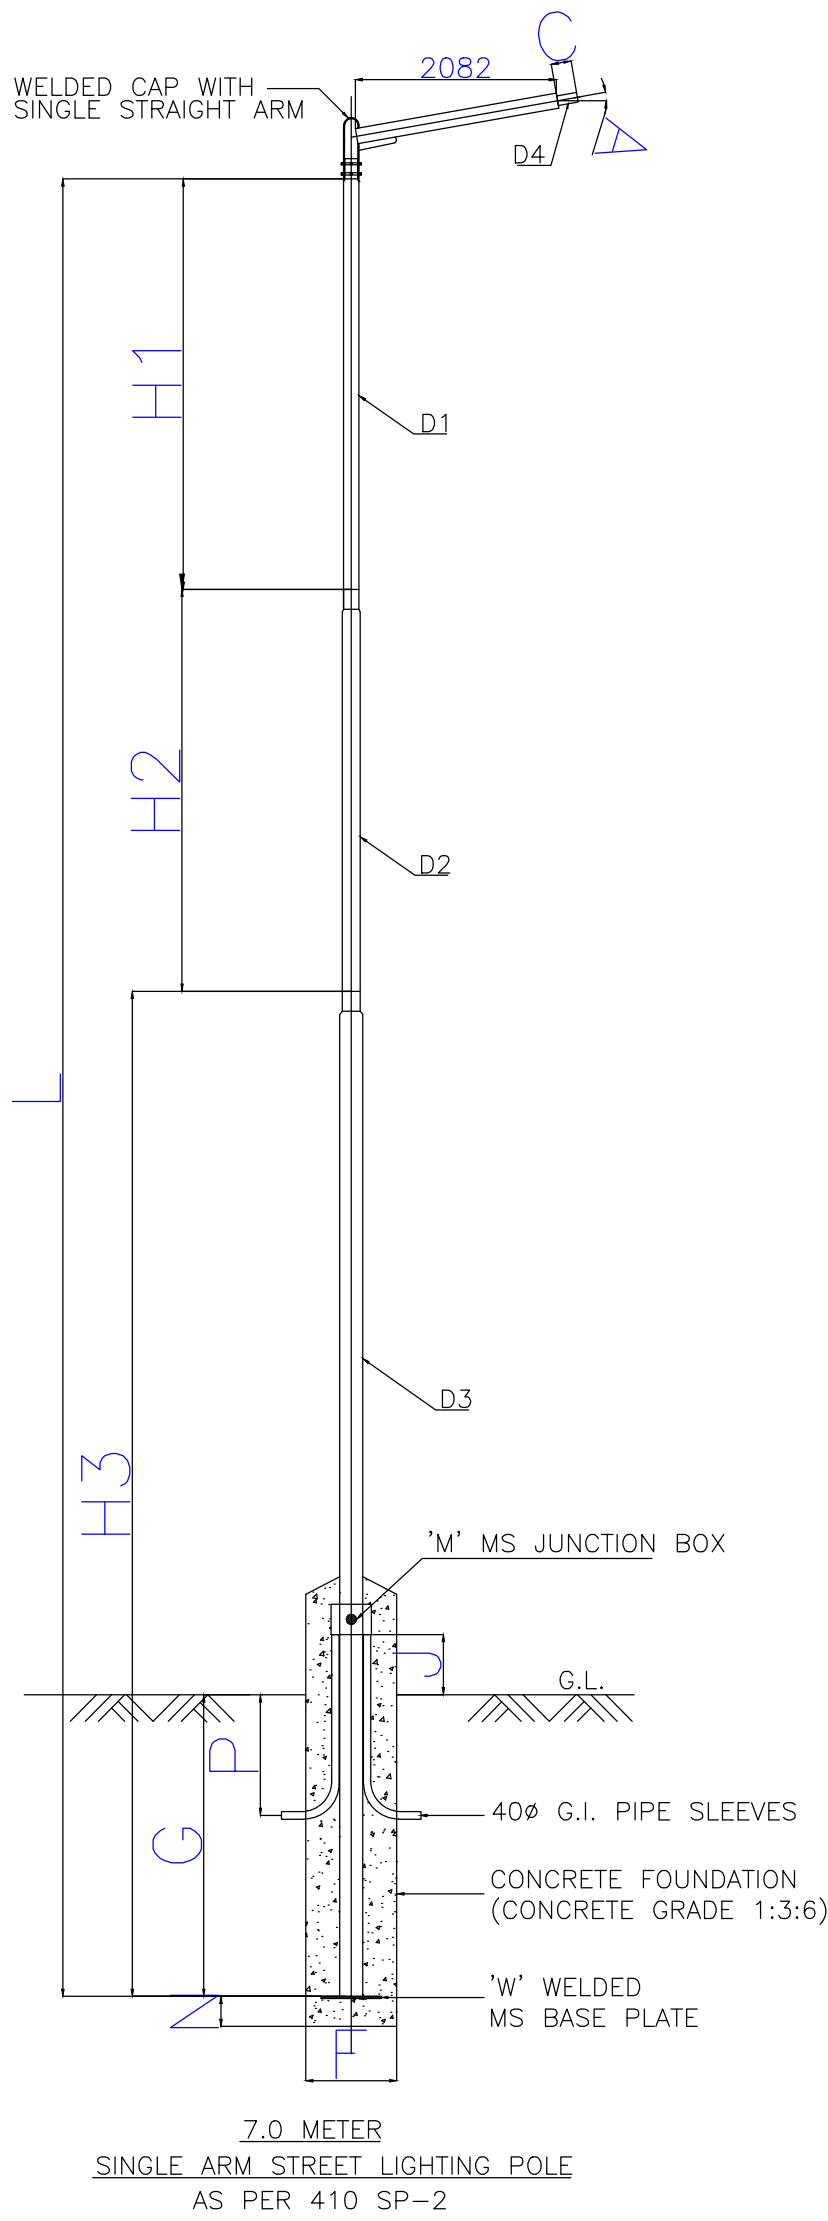


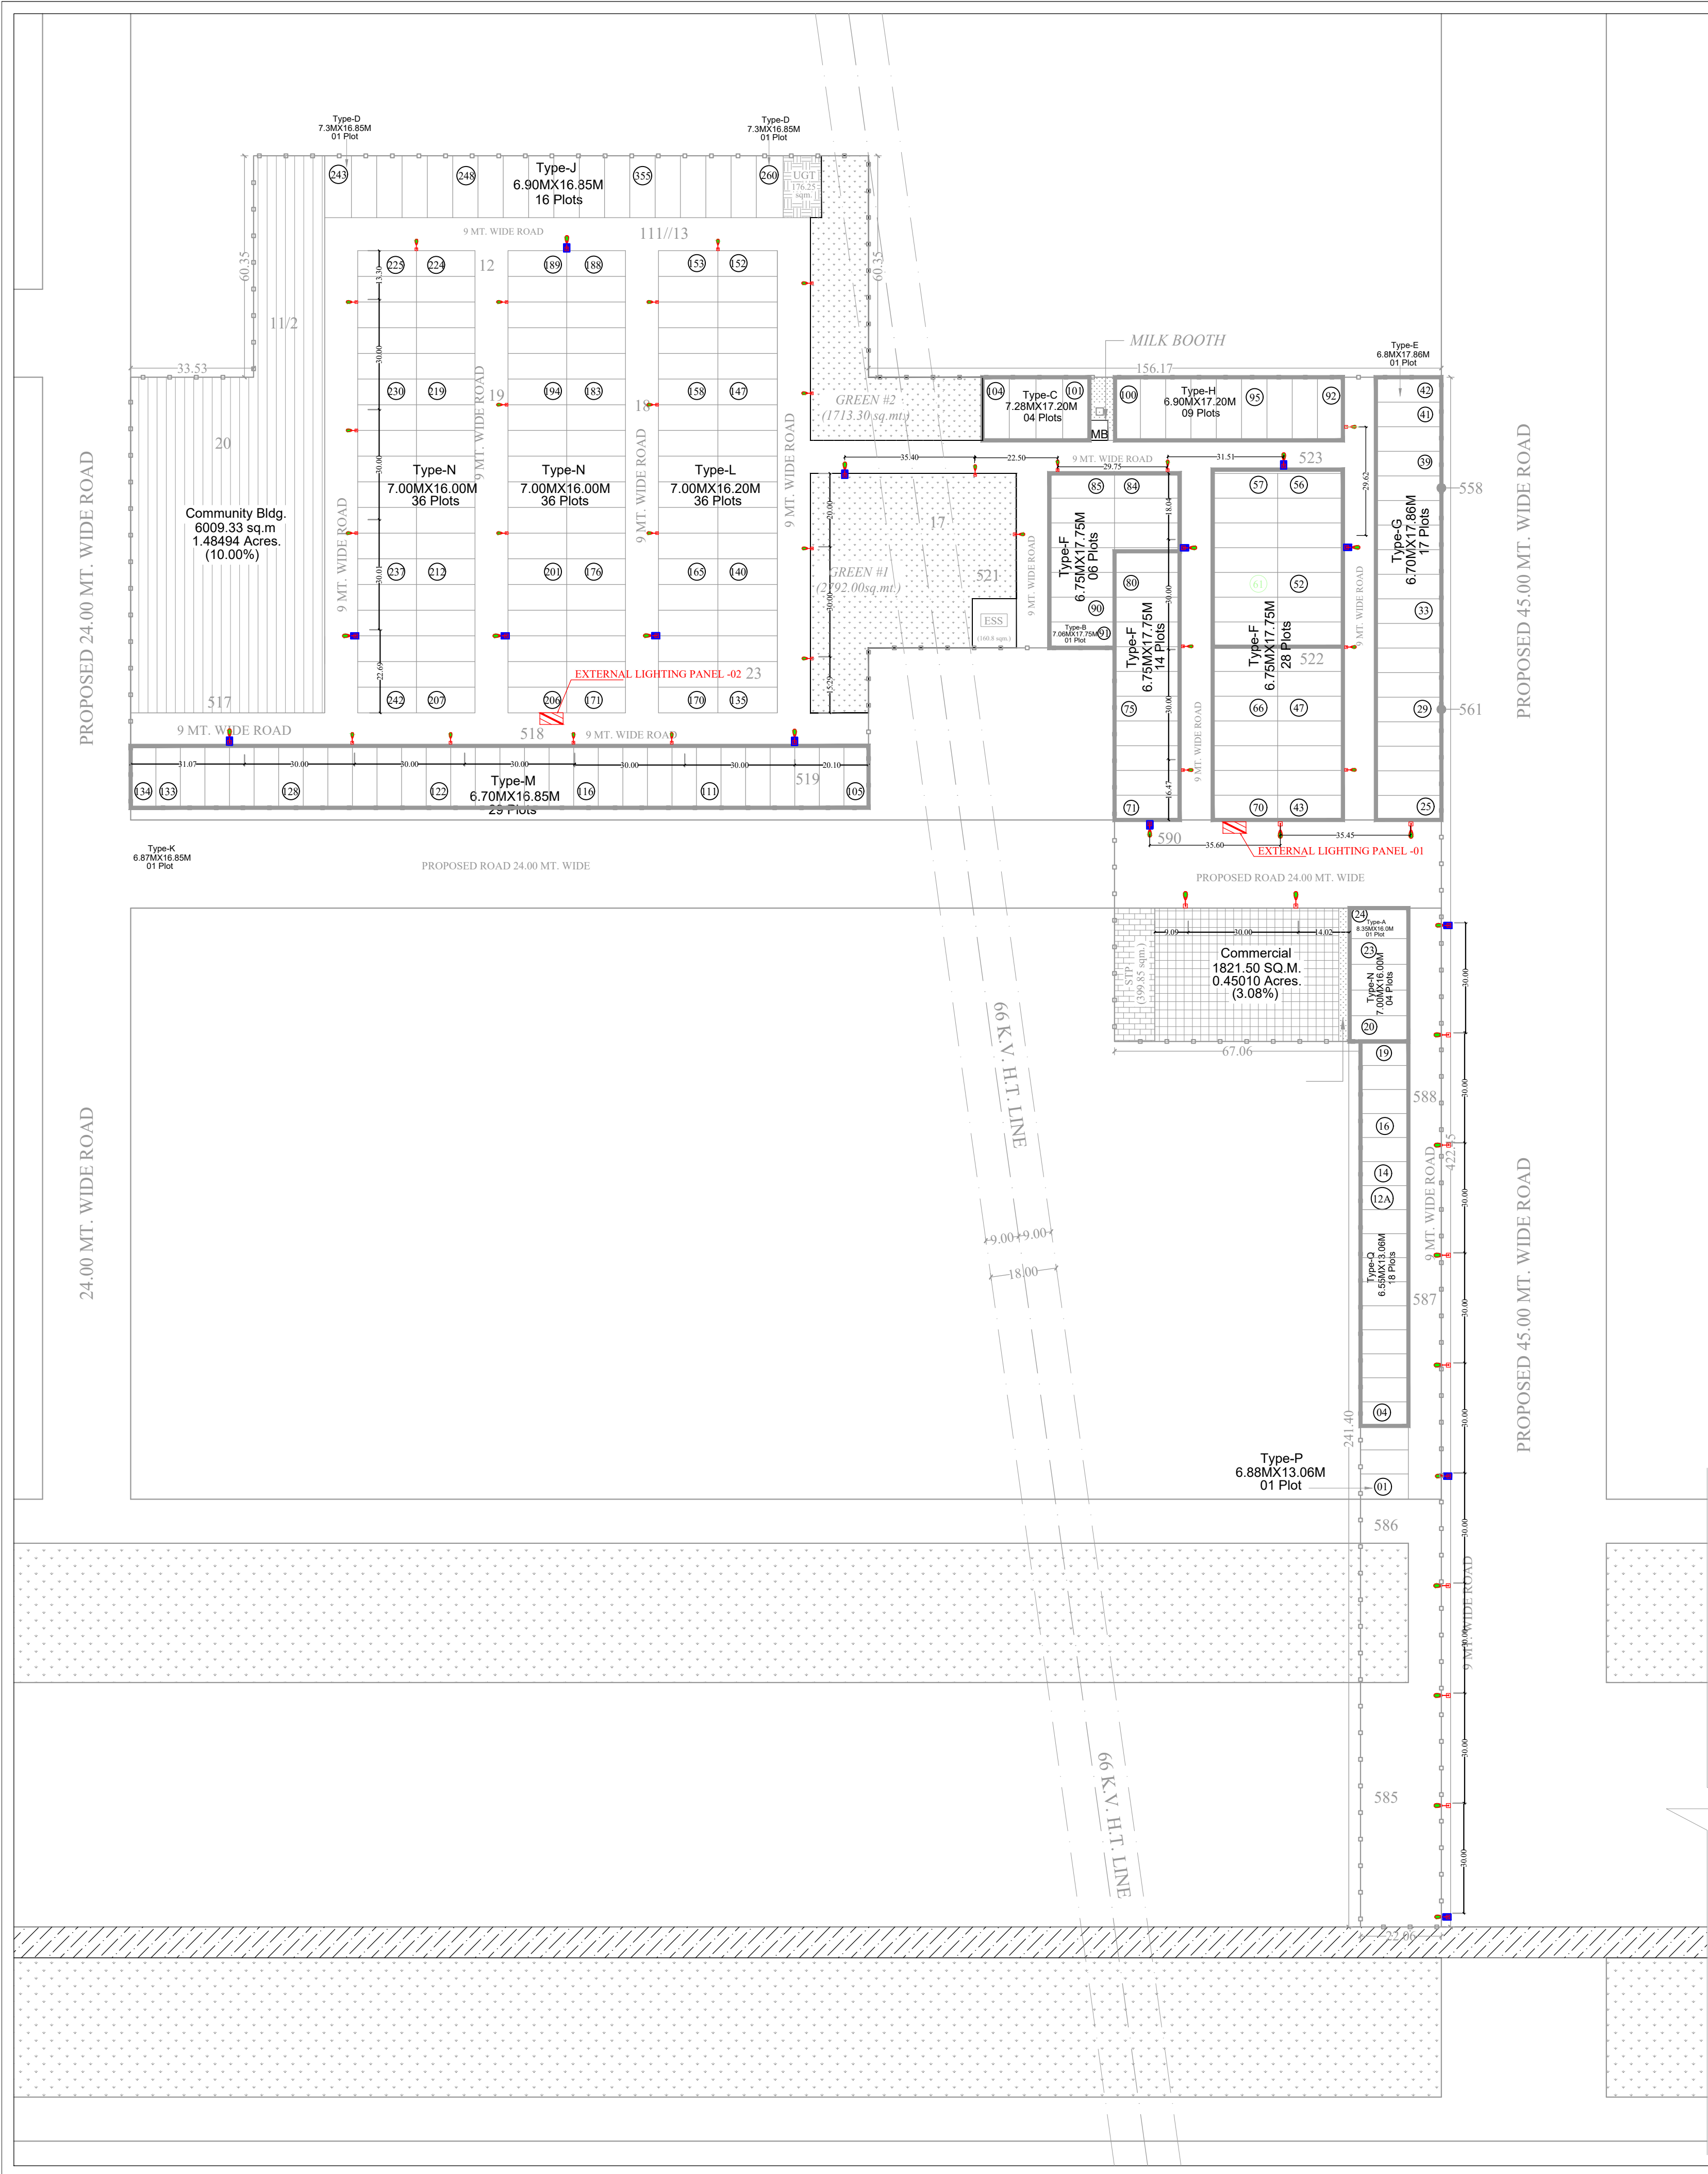


ALL DIMENTIONS ARE IN "MM".

| HEIGHT        | SECTION | BRACKET | NIPPLE | BASE PLATE | HEIGHT OF G.L. | FOUND. ANGLE | FOUND. WIDTH | JUNCTION BOX | N   | P   | J   | APPROX. OVERALL WEIGHT | POLE WEIGHT                                                                | TOTAL  |
|---------------|---------|---------|--------|------------|----------------|--------------|--------------|--------------|-----|-----|-----|------------------------|----------------------------------------------------------------------------|--------|
|               |         |         |        |            |                |              |              |              |     |     |     |                        |                                                                            |        |
| L             | D3      | B       | C      | "w"        | G              | A            | F            | "w"          | 150 | 600 | 300 | 73 KG                  | Pole - 73kg<br>Base Plate - 4.3kg<br>Nipple - 0.800kg<br>End Bracket - 5kg | 83.1kg |
| H3            | D2      | D4      |        |            |                |              |              |              |     |     |     |                        |                                                                            |        |
| H2            | D1      |         |        |            |                |              |              |              |     |     |     |                        |                                                                            |        |
| H1            |         |         |        |            |                |              |              |              |     |     |     |                        |                                                                            |        |
| MIDDLE BOTTOM |         |         |        |            |                |              |              |              |     |     |     |                        |                                                                            |        |
| TOP           |         |         |        |            |                |              |              |              |     |     |     |                        |                                                                            |        |
|               |         |         |        |            |                |              |              |              |     |     |     |                        | VARIABLE AS PER POLE Wt.                                                   |        |

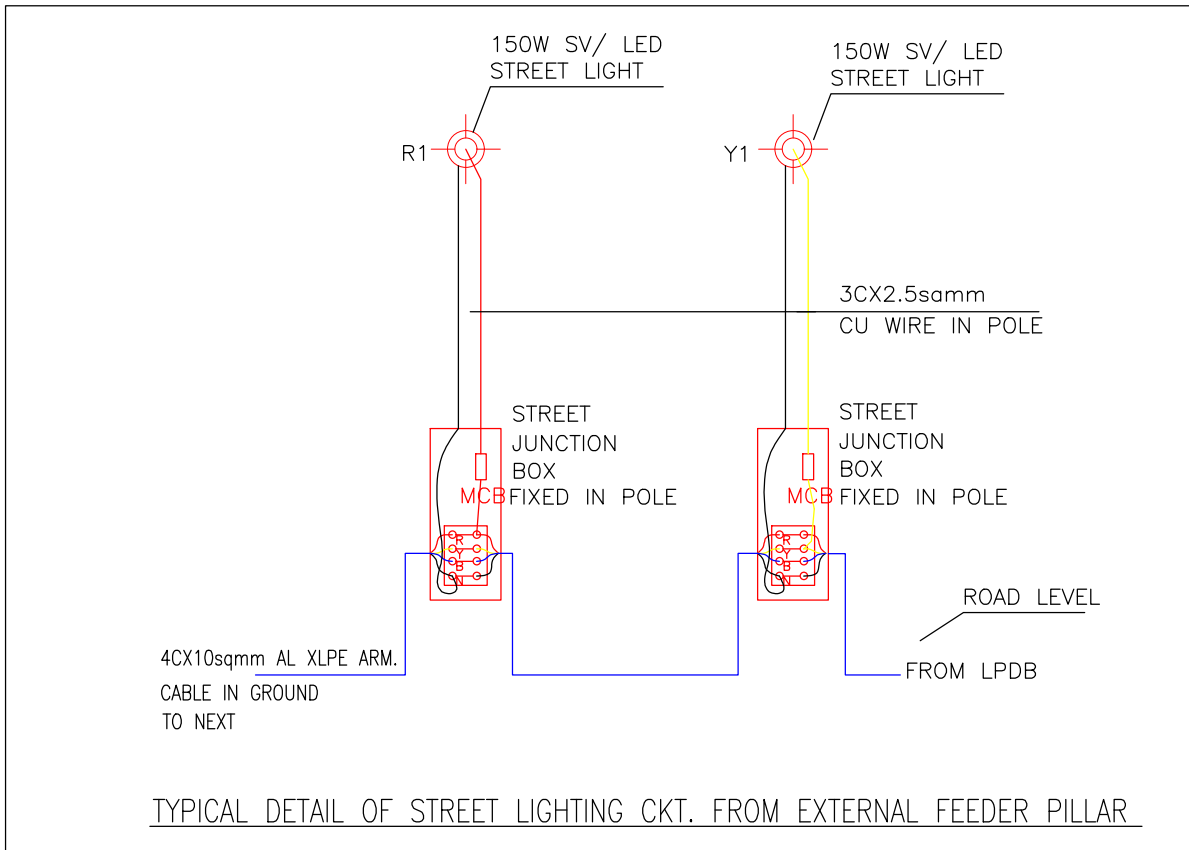

| LEGEND |                             |
|--------|-----------------------------|
| SYMBOL | TYPE                        |
|        | 150W (7mt.) SINGLE ARM POLE |
|        | SOLAR ARM POLE              |
|        | GATE LIGHT                  |

| LEGEND |                                     |
|--------|-------------------------------------|
| SYMBOL | TYPE                                |
|        | METER PANEL                         |
|        | FEEDER PILLAR                       |
|        | LT CABLE ROUTE FOR OPEN-ABLE TRENCH |
|        | HUMME PIPE ROAD CROSSING            |
|        | PSS TO METER BOARD CABLE            |
|        | EARTHING PIT                        |

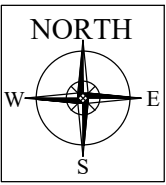

**Project :**  
**DEEN DAYAL JAN AWAS YOJNA (DDJAY)**  
**AT KURUKSHETRA, HARYANA**

**Title :**  
**EXTERNAL LIGHTING LAYOUT**

**Sub title :**

**Drawing Released For :**

☐ APPROVAL ☒ SUBMISSION

☐ ADVANCE COPY ☐ CONSTRUCTION

**Drg. No :** SS II - SE - EL 01

**Scale :** **Drawn By :**

**Date :** OCTOBER 2019 **Design By :**

**Ckd By :**

**CLIENT :**  
**M/S. SAMSUNG OVERSEAS LTD.**

**MKG ENGINEERING SERVICES PVT. LTD.**  
First Floor, A-8, Paryavaran Complex,  
Indira Gandhi National Open Univ. Road,  
New Delhi - 110030, INDIA  
Tel: +91-11-29532720 / 29532257  
E-mail: mail@mkgconsultants.com; mkgconsultants@gmail.com  
Visit Us: www.mkgconsultants.com  
MORE THAN 25 YEARS OF EXCELLENCE IN PUBLIC HEALTH ENGINEERING