

# SEWERAGE SCHEME

PROJECT:-  
REVISED BUILDING PLANS OF COMMERCIAL SITE  
MEASURING 2.0 ACRE  
(LICENCE NO. 56 OF 2007 DATED 23.01.2007) IN  
SECTOR-24, DHARUHERA, BEING DEVELOPED BY.  
M/S DWARKADHISH PROJECTS PVT. LTD.

DWG.TITLE  
SEWERAGE SCHEME

DRG. NO.  
SPE-05


Dwarkadhis Projects Pvt. Ltd

Authorised Signatory

SIG. OF OWNER



SIG. OF ARCHITECT

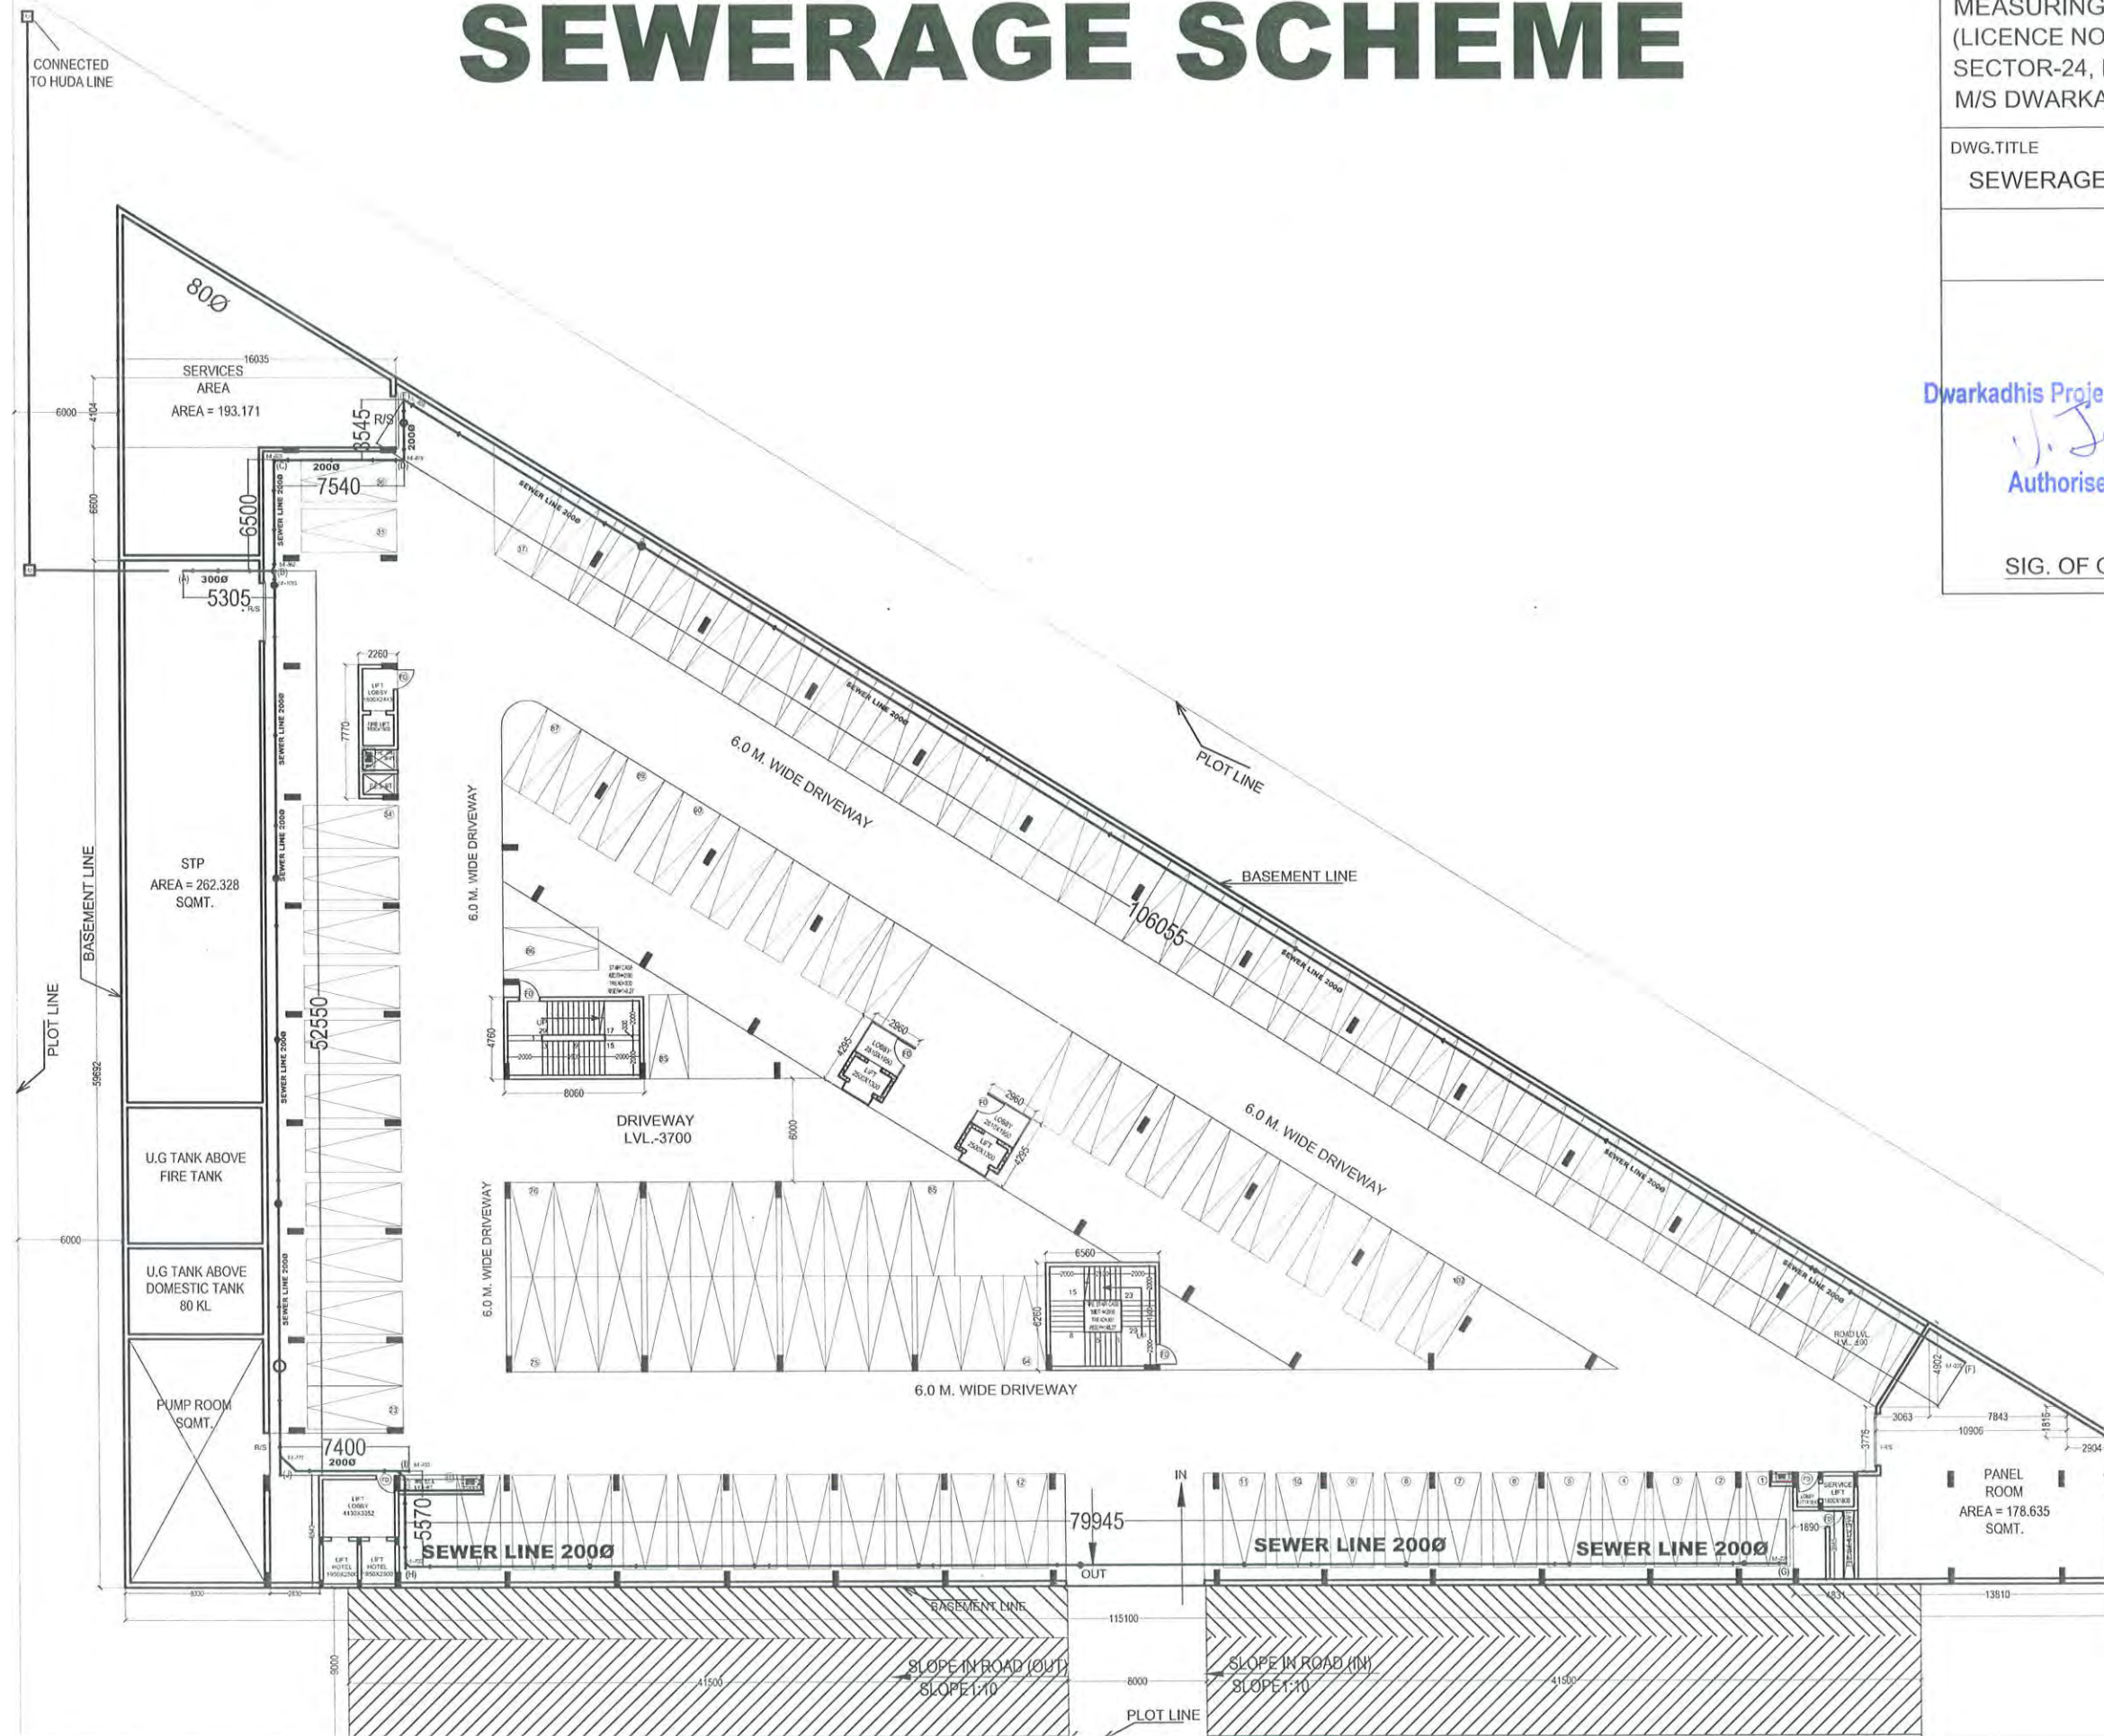

BASEMENT FLOOR WITH MECHANICAL PARKING  
PARKING 102+102 (MECHANICAL PARKING)

# FIRE HYDRANT

PROJECT:-  
REVISED BUILDING PLANS OF COMMERCIAL SITE  
MEASURING 2.0 ACRE  
(LICENCE NO. 56 OF 2007 DATED 23.01.2007) IN  
SECTOR-24, DHARUHERA, BEING DEVELOPED BY.  
M/S DWARKADHISH PROJECTS PVT. LTD.

DWG. TITLE  
FIRE HYDRANT


DRG. NO.  
SPE-02

Dwarkadhis Projects Pvt. Ltd.  
*U. Jain*  
Authorised Signatory



SIG. OF OWNER

SIG. OF ARCHITECT

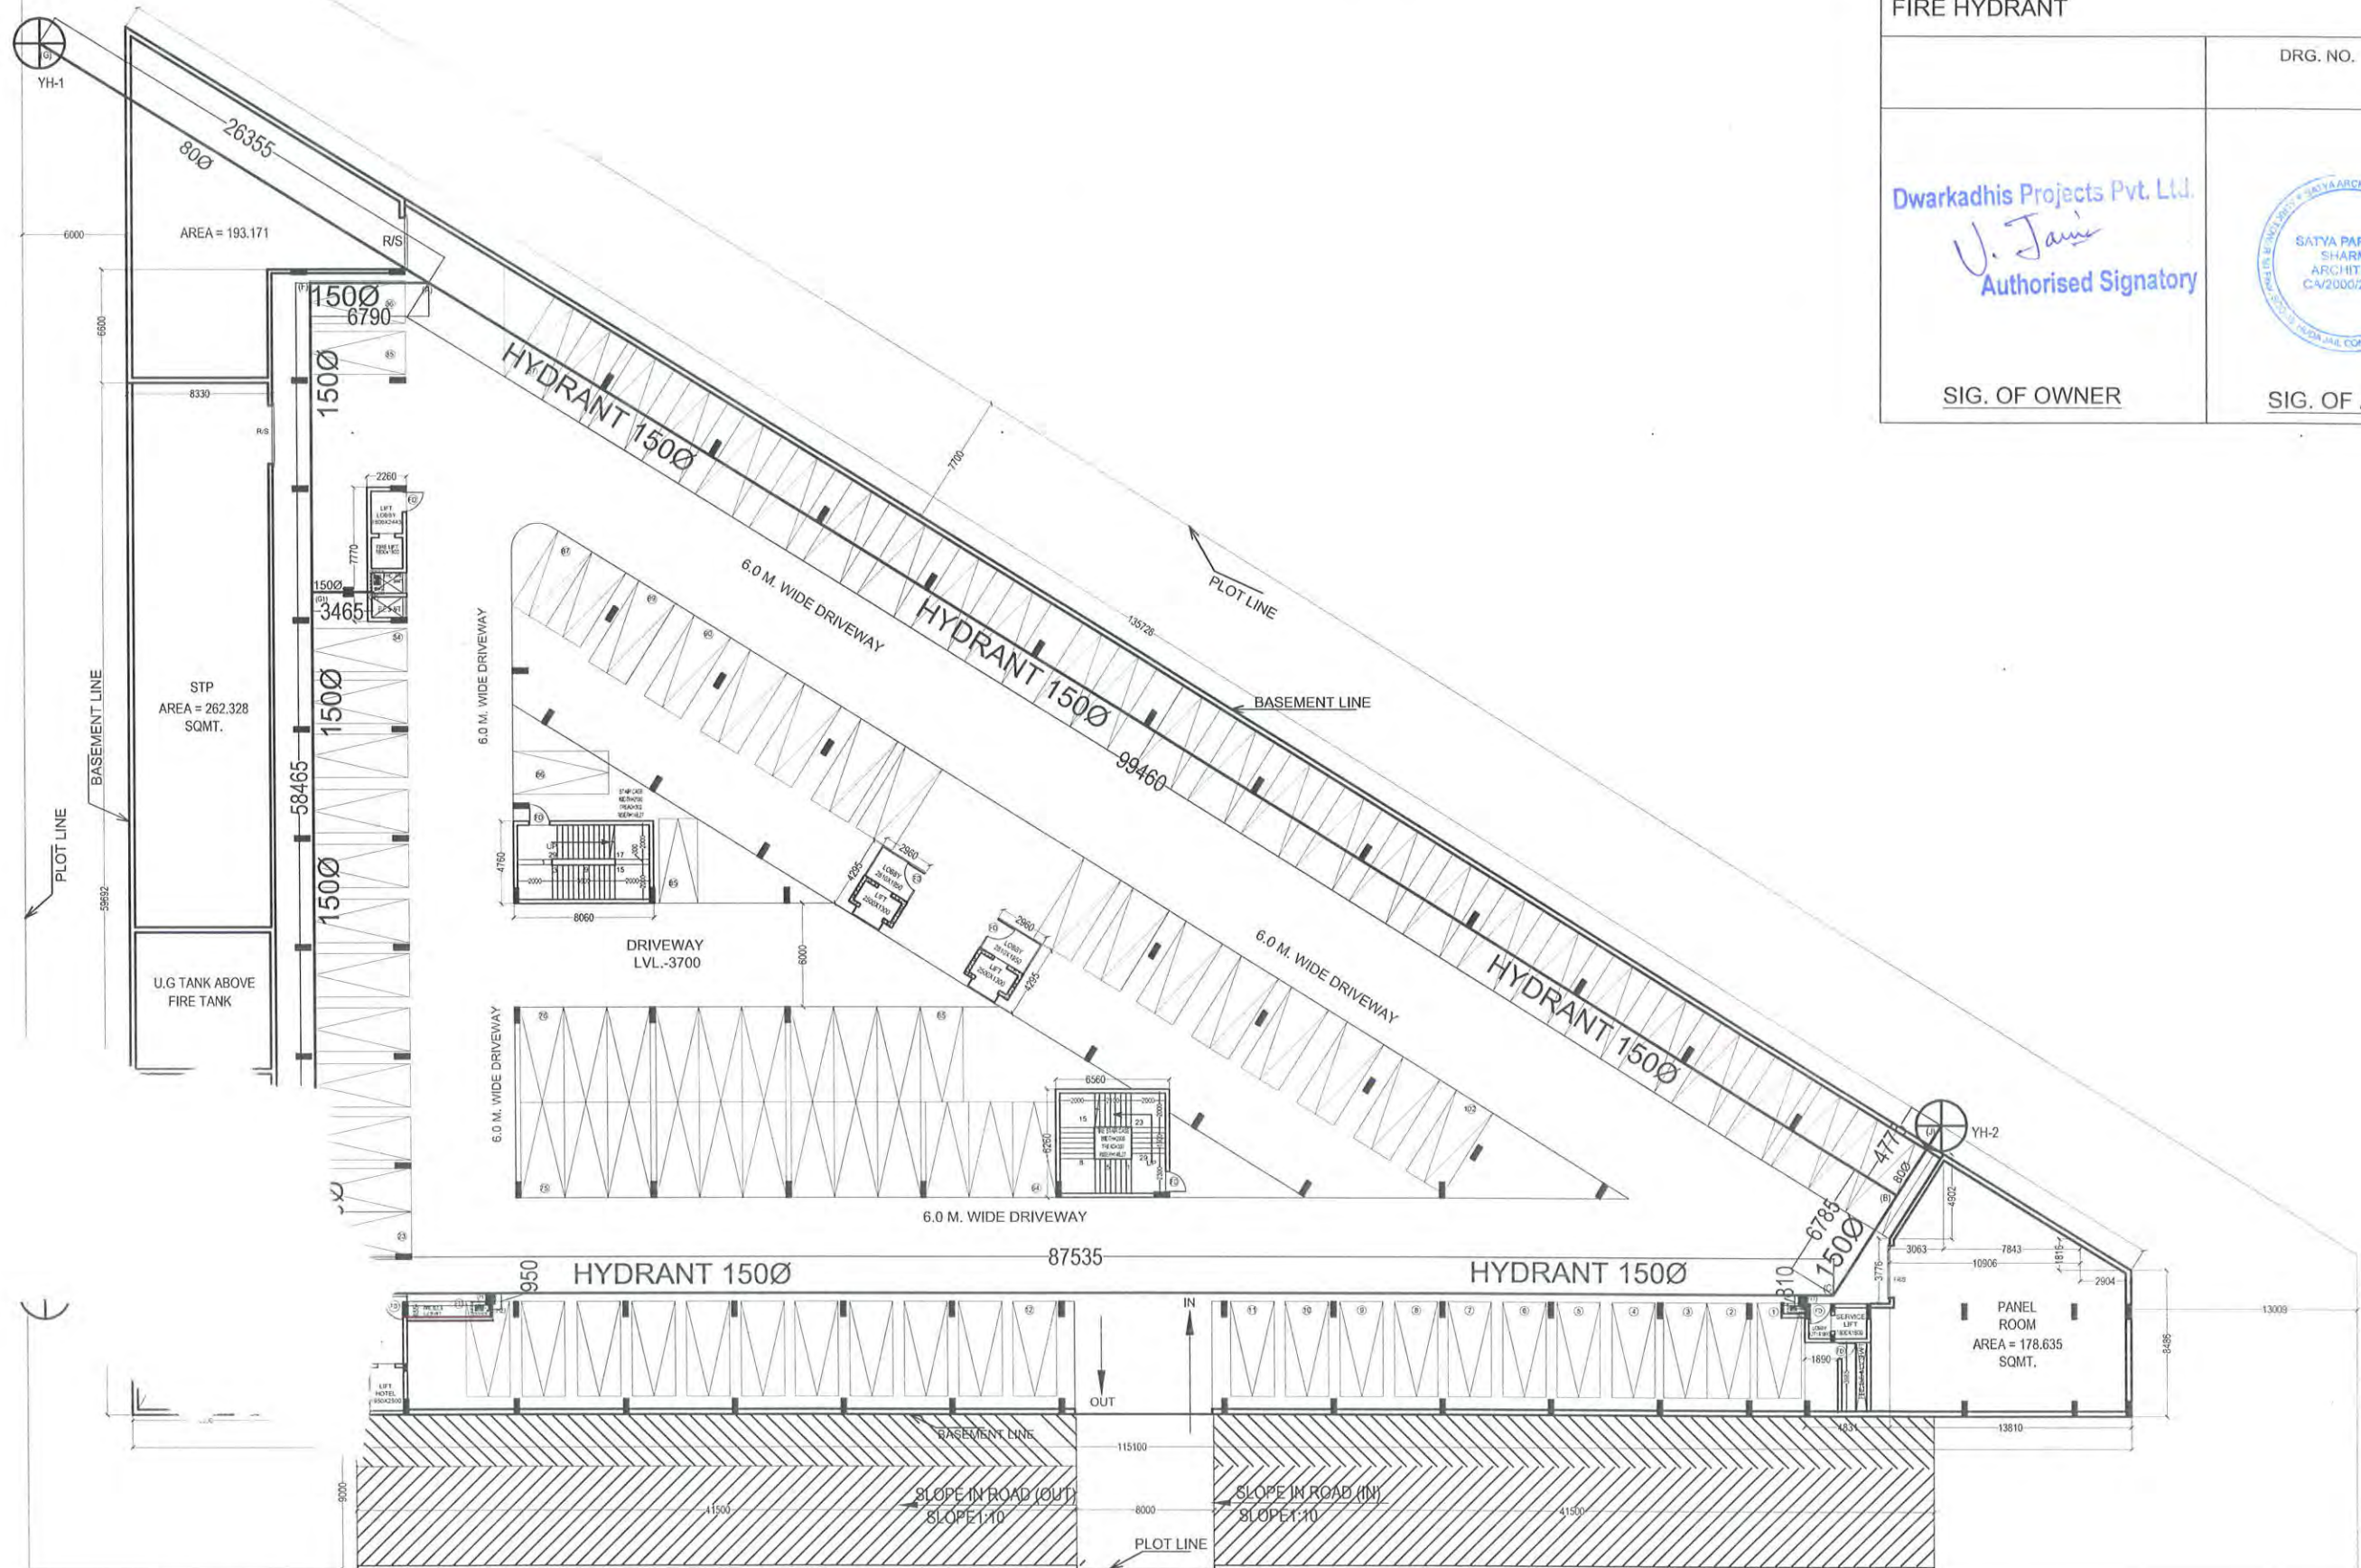

BASEMENT FLOOR WITH MECHANICAL PARKING  
PARKING 102+102 (MECHANICAL PARKING)

# STREET LIGHT PLAN

PROJECT:-  
REVISED BUILDING PLANS OF COMMERCIAL SITE  
MEASURING 2.0 ACRE  
(LICENCE NO. 56 OF 2007 DATED 23.01.2007) IN  
SECTOR-24, DHARUHERA, BEING DEVELOPED BY.  
M/S DWARKADHISH PROJECTS PVT. LTD.


DWG. TITLE  
STREET LIGHTING PLAN

DRG. NO.

SPE-07

## LEGEND : ( Electrical & Fire Alarm System )

| S. No. | SYMBOL | DESCRIPTION  | NOS | WATT |
|--------|--------|--------------|-----|------|
| 1.     | ST     | STREET LIGHT | 19  | 30   |

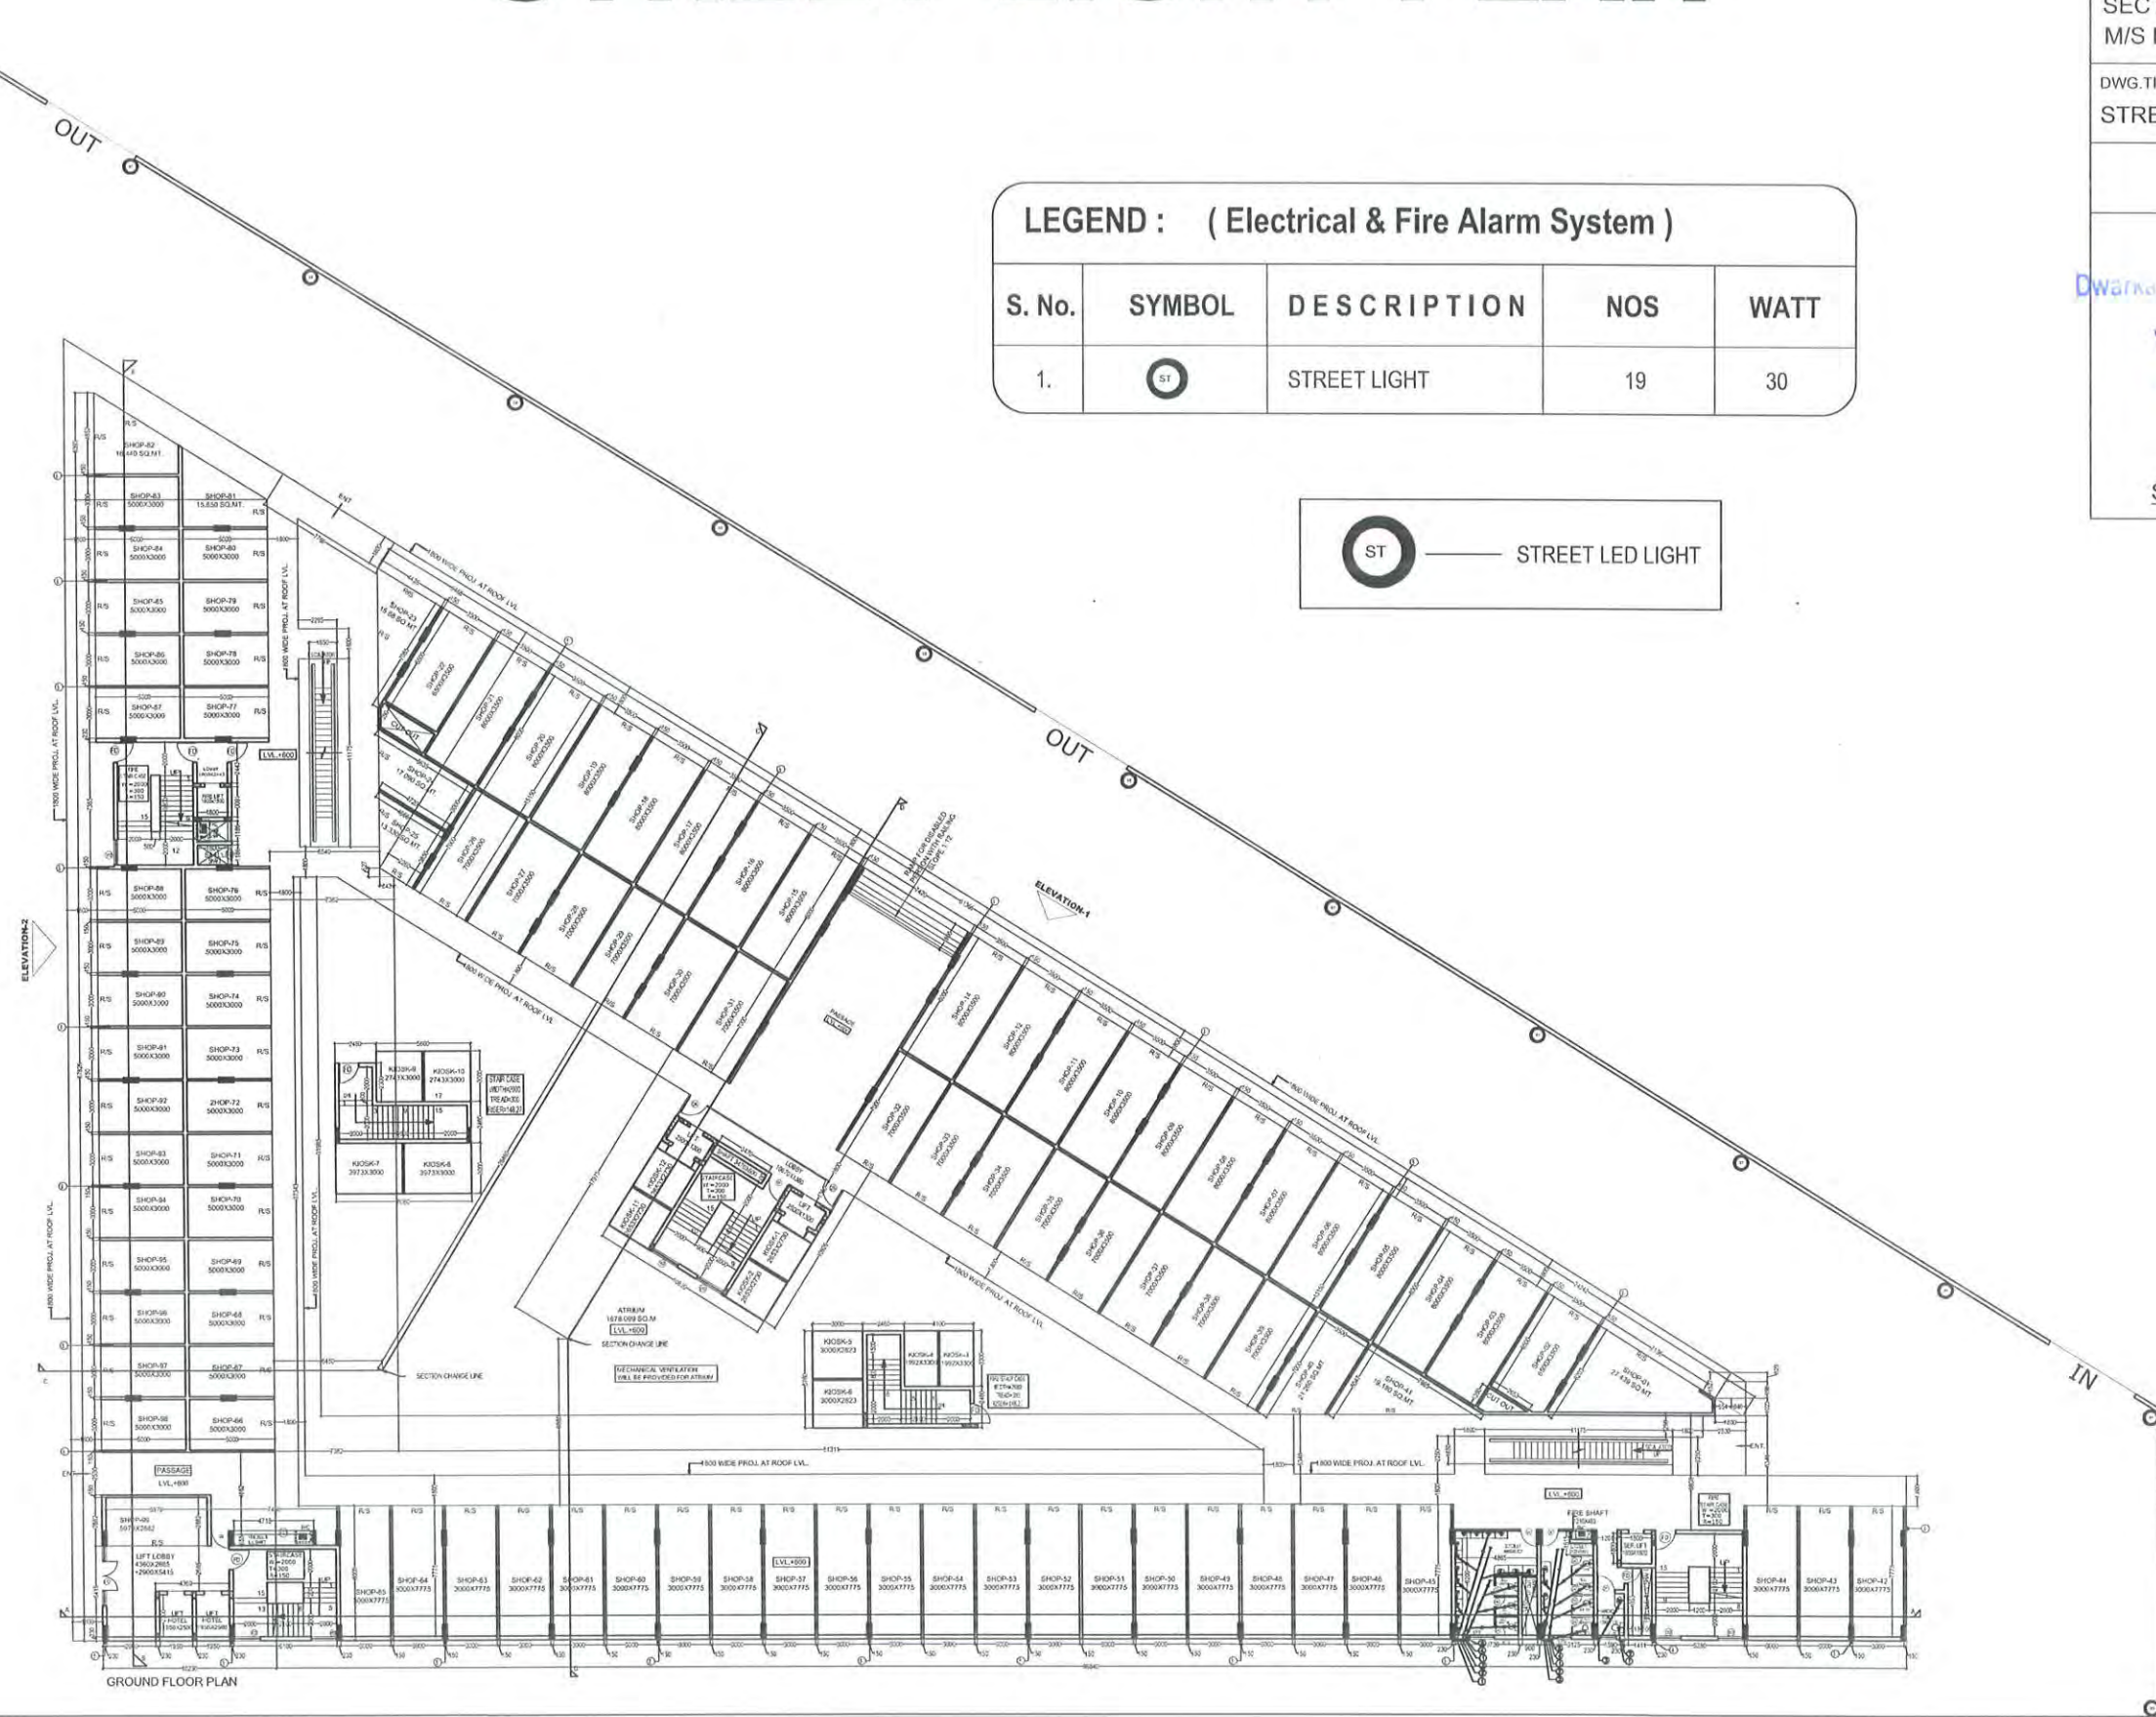

Dwarkadhish Projects Pvt. Ltd.  
J. Jain  
Authorised Signatory

SIG. OF OWNER



SIG. OF ARCHITECT

# WATER SUPPLY RECYCLING

PROJECT:-  
REVISED BUILDING PLANS OF COMMERCIAL SITE  
MEASURING 2.0 ACRE  
(LICENCE NO. 56 OF 2007 DATED 23.01.2007) IN  
SECTOR-24, DHARUHERA, BEING DEVELOPED BY.  
M/S DWARKADHISH PROJECTS PVT. LTD.

DWG.TITLE  
WATER SUPPLY RECYCLING


DRG. NO.  
SPE-03

Dwarkadhis Projects Pvt. Ltd.  
*U. Jain*  
Authorised Signatory

SIG. OF OWNER



SIG. OF ARCHITECT

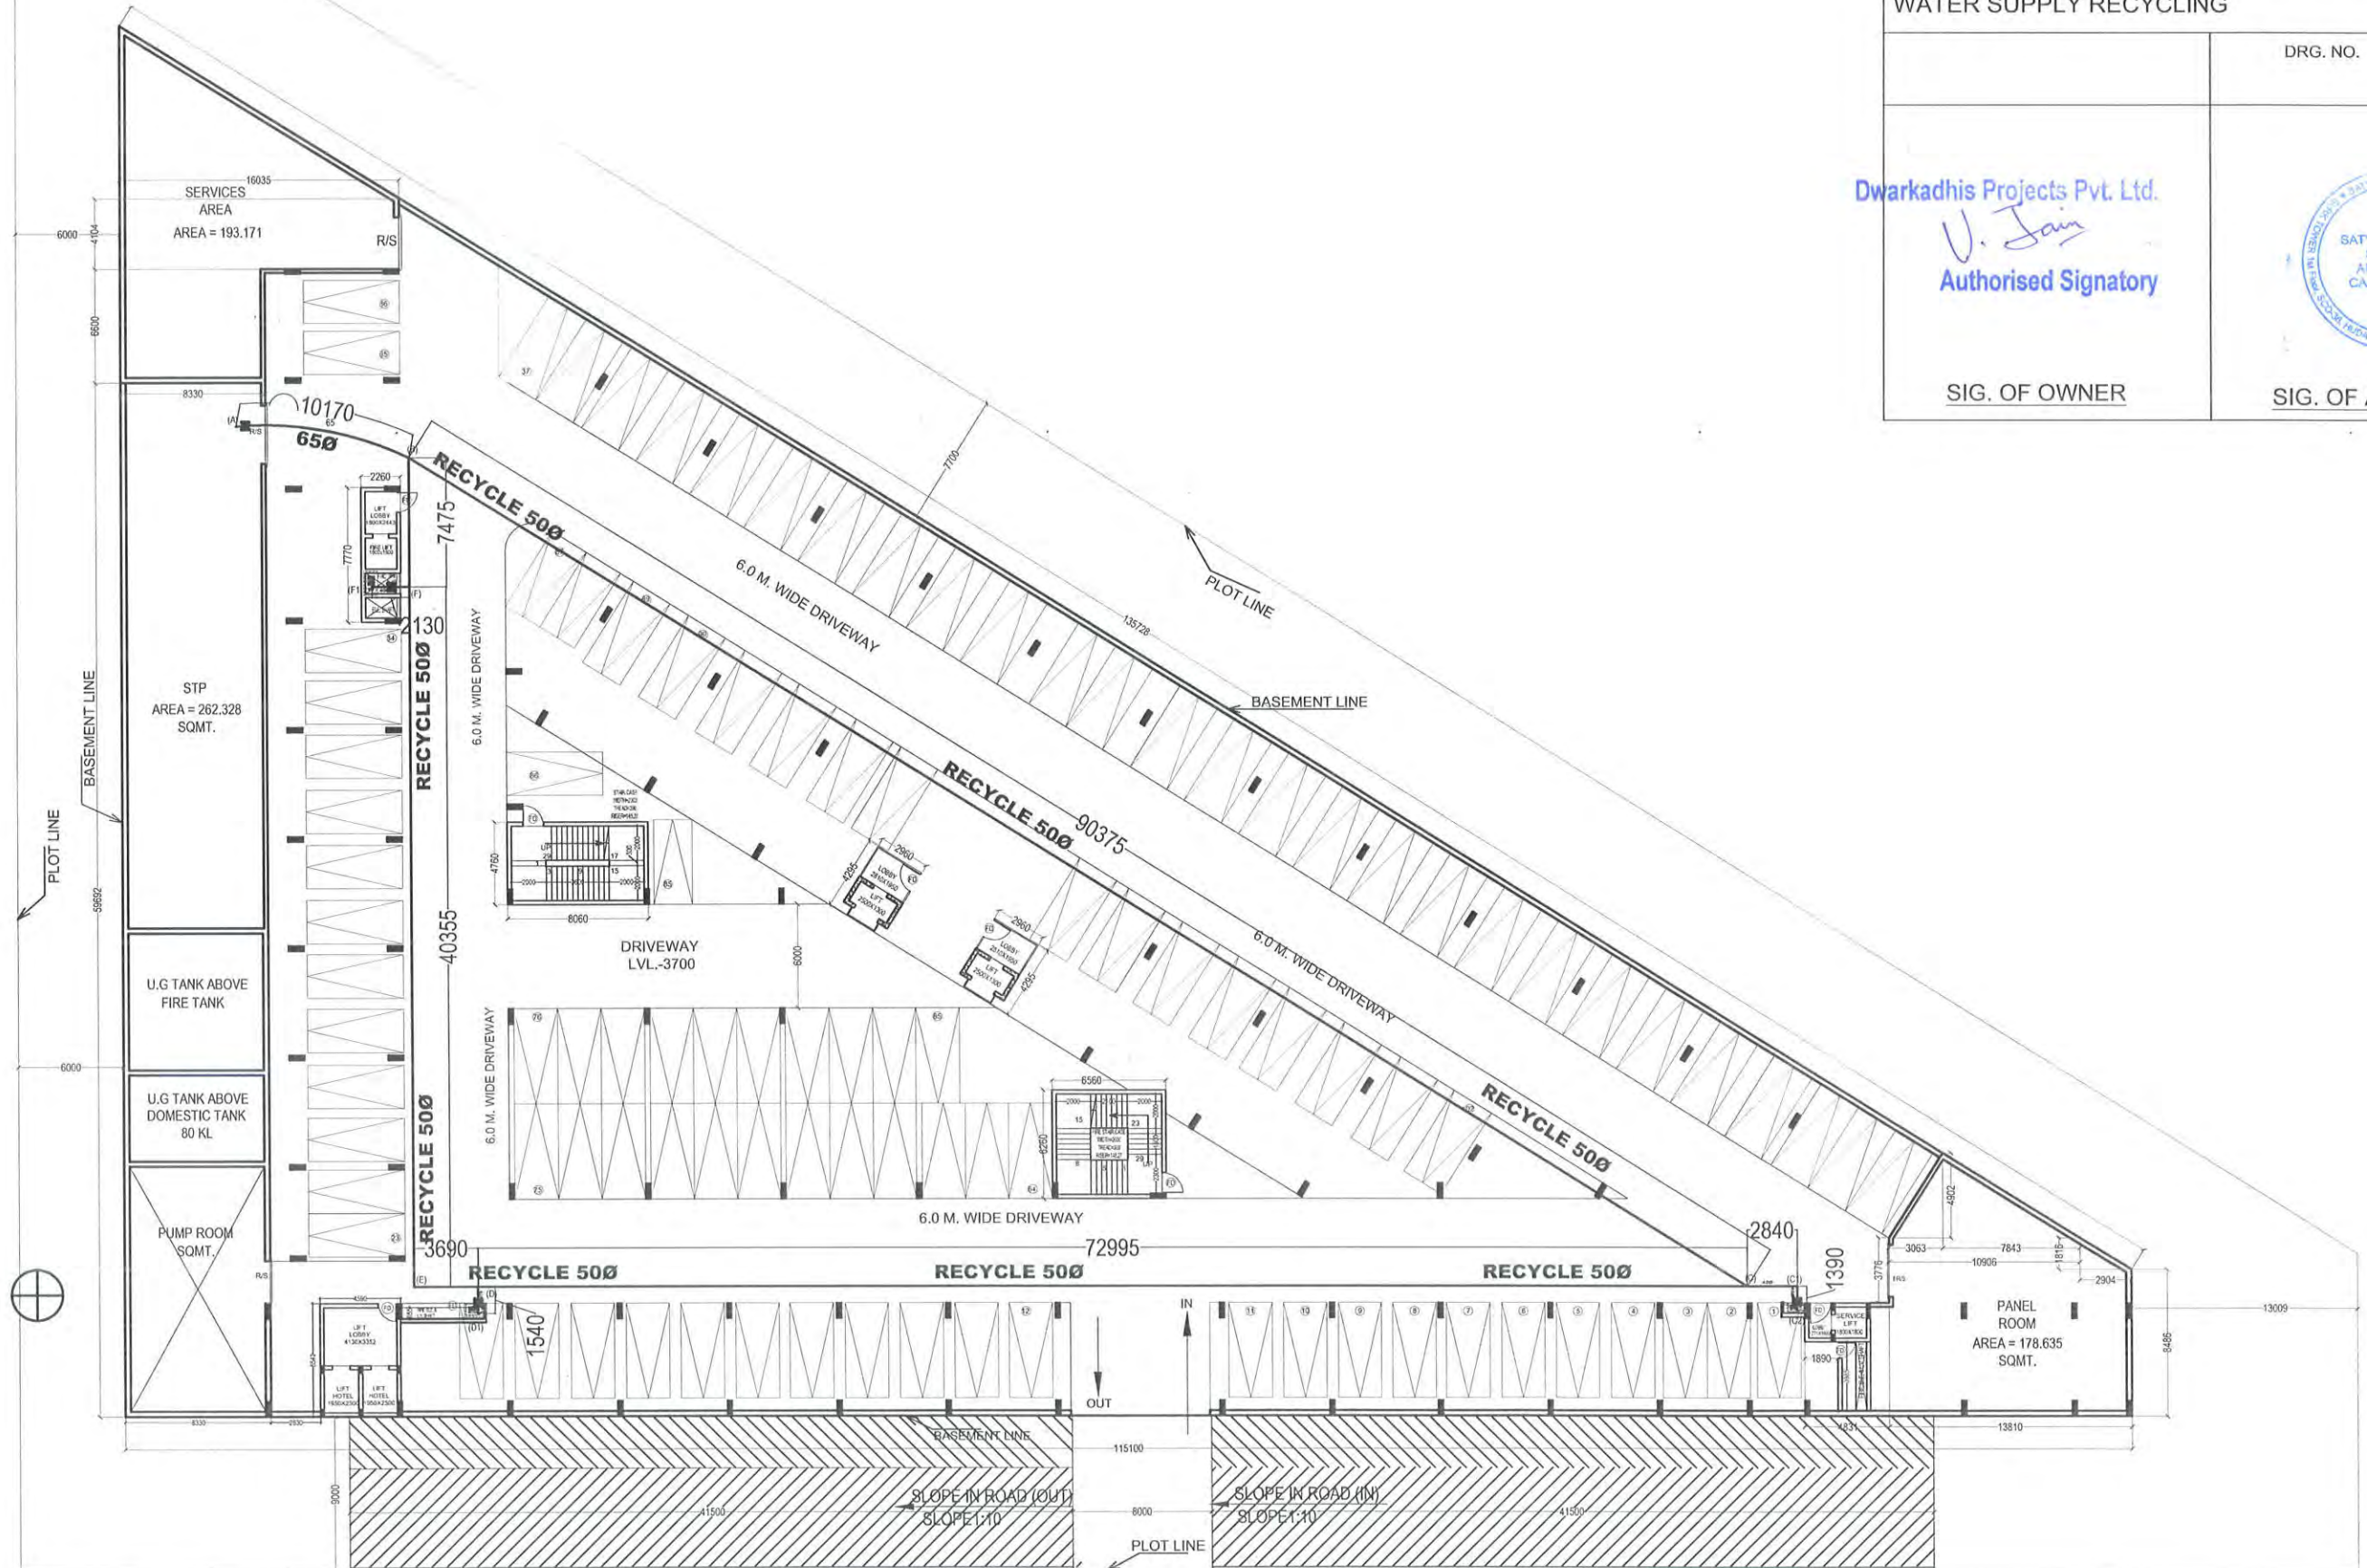

BASEMENT FLOOR WITH MACHANICAL PARKING  
PARKING 102+102( MACHANICAL PARKING)

# WATER SUPPLY DOMESTIC

PROJECT:-  
REVISED BUILDING PLANS OF COMMERCIAL SITE  
MEASURING 2.0 ACRE  
(LICENCE NO. 56 OF 2007 DATED 23.01.2007) IN  
SECTOR-24, DHARUHERA, BEING DEVELOPED BY.  
M/S DWARKADHISH PROJECTS PVT. LTD.

DWG.TITLE  
WATER SUPPLY DOMESTIC


DRG. NO.  
SPE-04

Dwarkadhis Projects Pvt. Ltd.  
U. Jani  
Authorised Signatory



SIG. OF OWNER

SIG. OF ARCHITECT

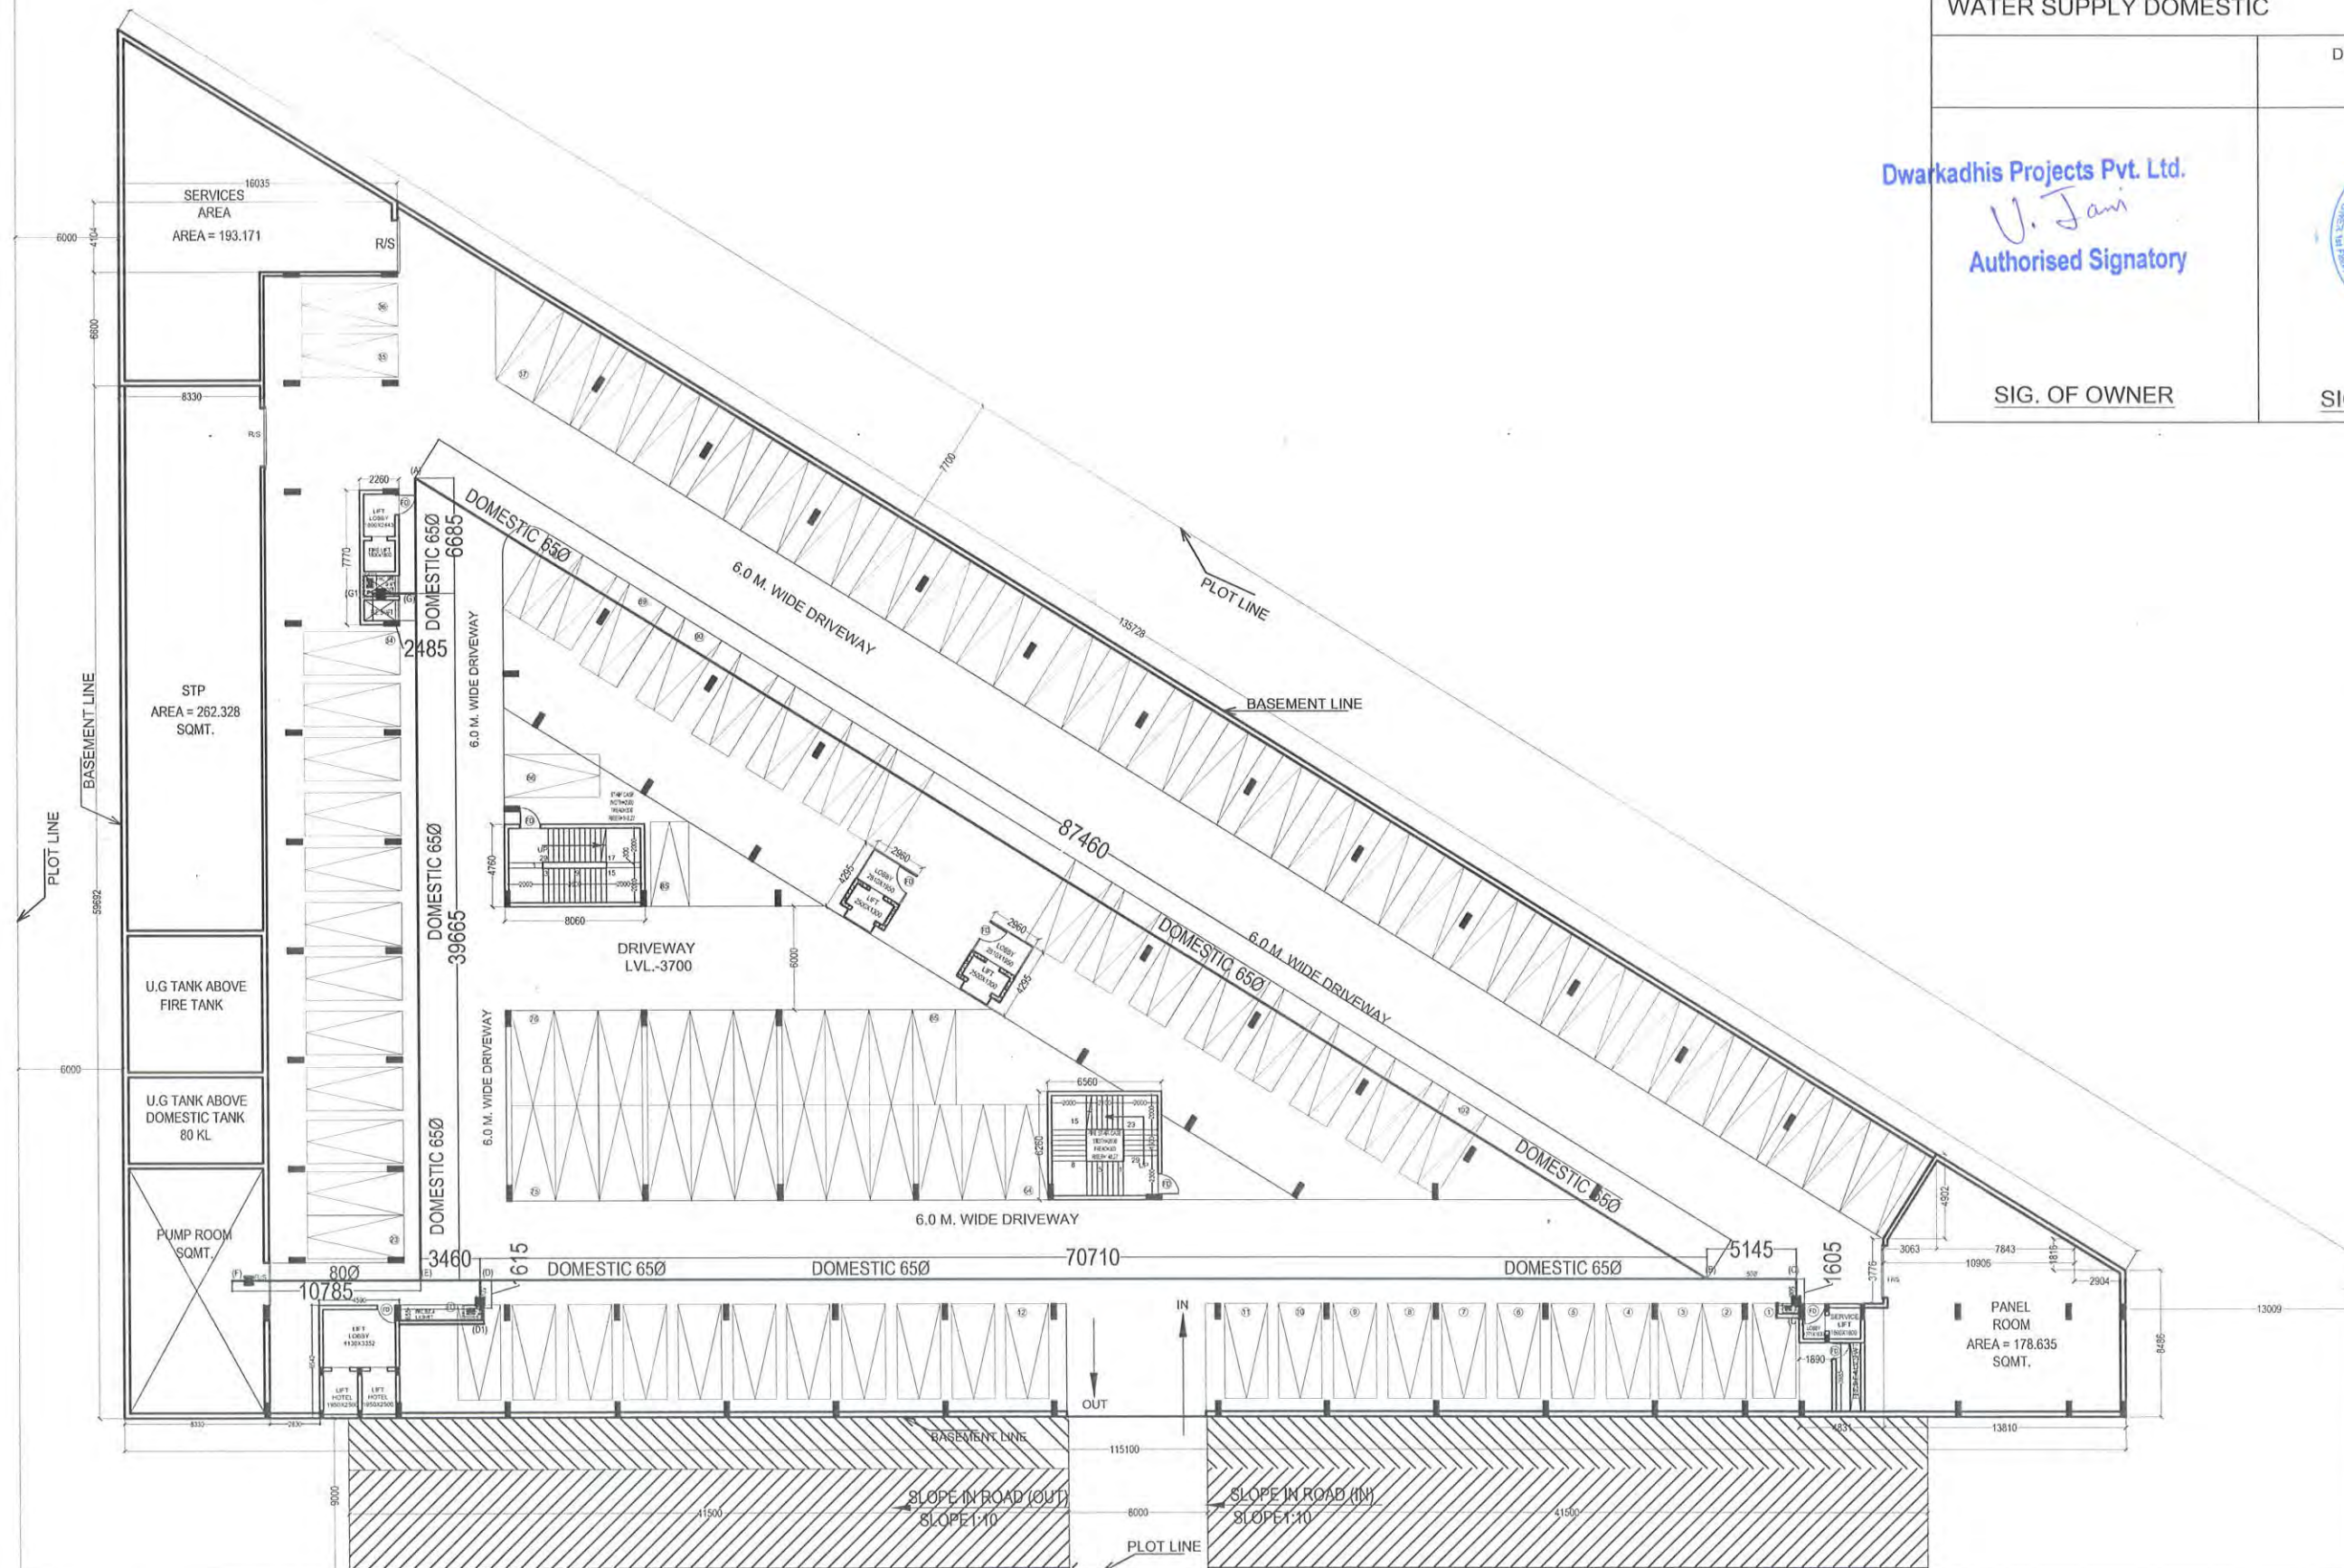

BASEMENT FLOOR WITH MECHANICAL PARKING  
PARKING 102+102 (MECHANICAL PARKING)

# STORM WATER SCHEME

PROJECT:-  
REVISED BUILDING PLANS OF COMMERCIAL SITE  
MEASURING 2.0 ACRE  
(LICENCE NO. 56 OF 2007 DATED 23.01.2007) IN  
SECTOR-24, DHARUHERA, BEING DEVELOPED BY.  
M/S DWARKADHISH PROJECTS PVT. LTD.

DWG. TITLE  
STORM WATER SCHEME


DRG. NO.  
SPE-06

Dwarkadhis Projects Pvt. Ltd.  
*U. Jain*  
Authorised Signatory


SIG. OF OWNER



SIG. OF ARCHITECT

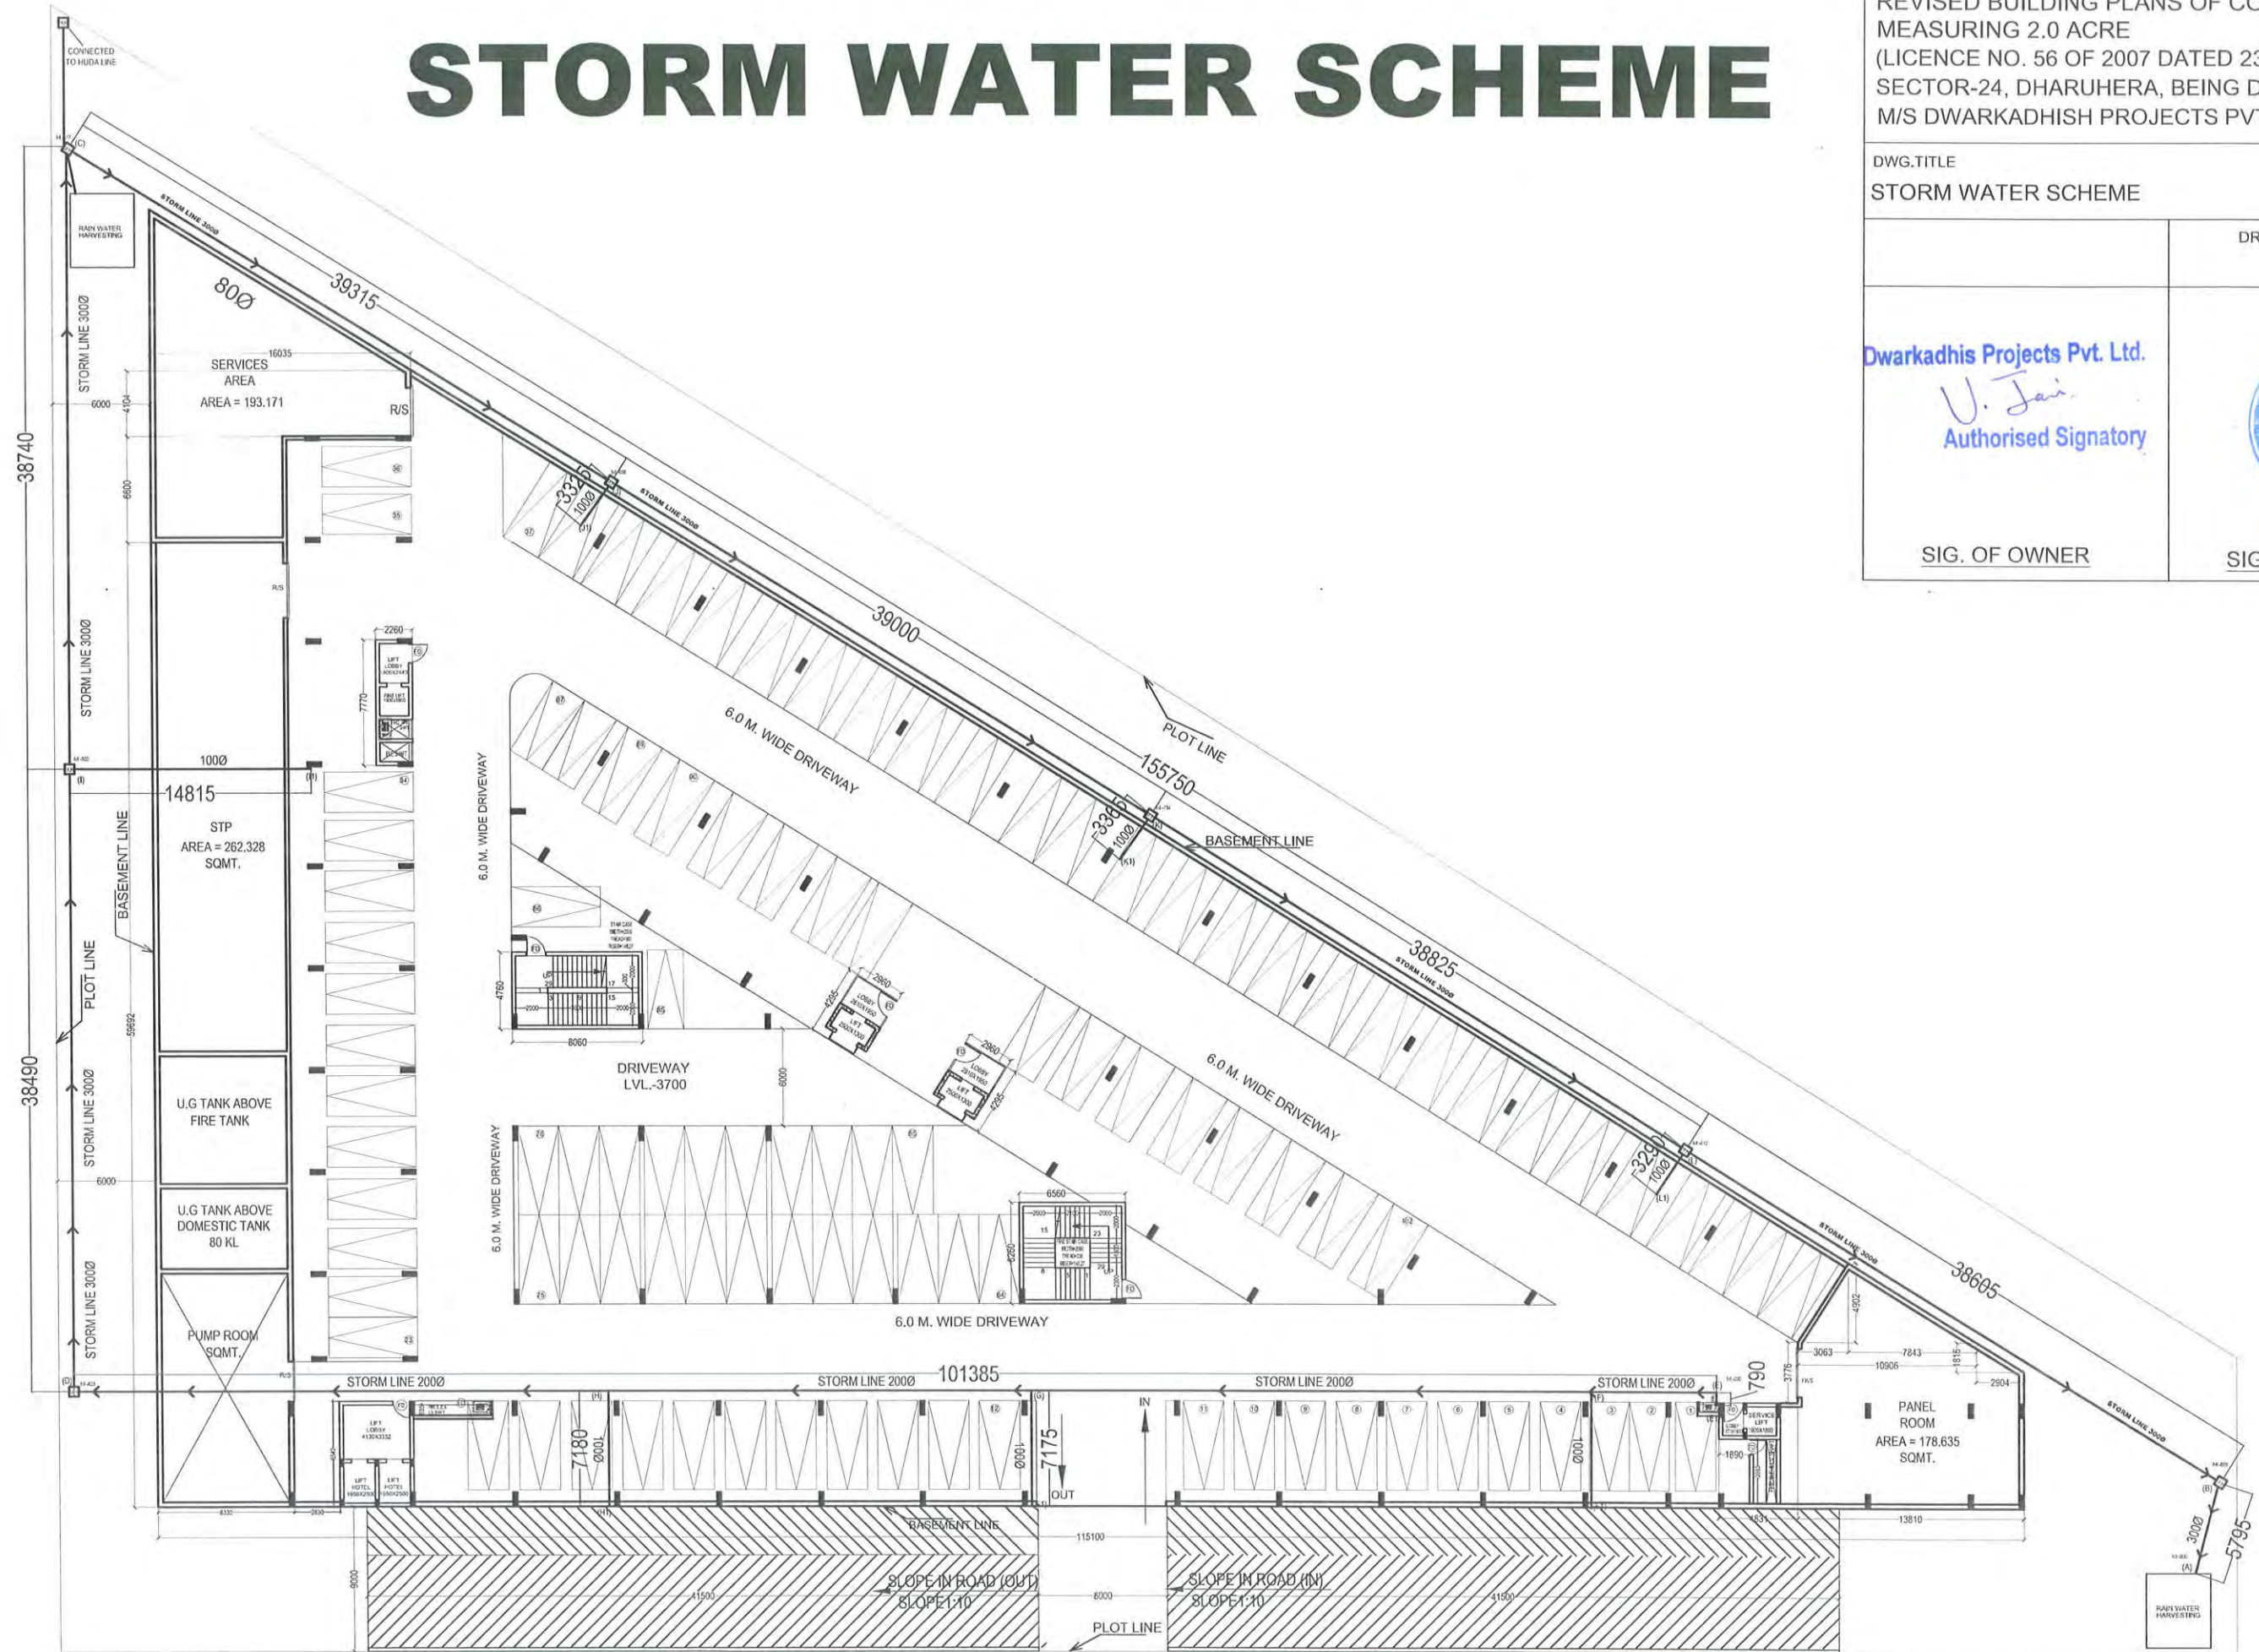

BASEMENT FLOOR WITH MECHANICAL PARKING  
PARKING 102+102 (MECHANICAL PARKING)

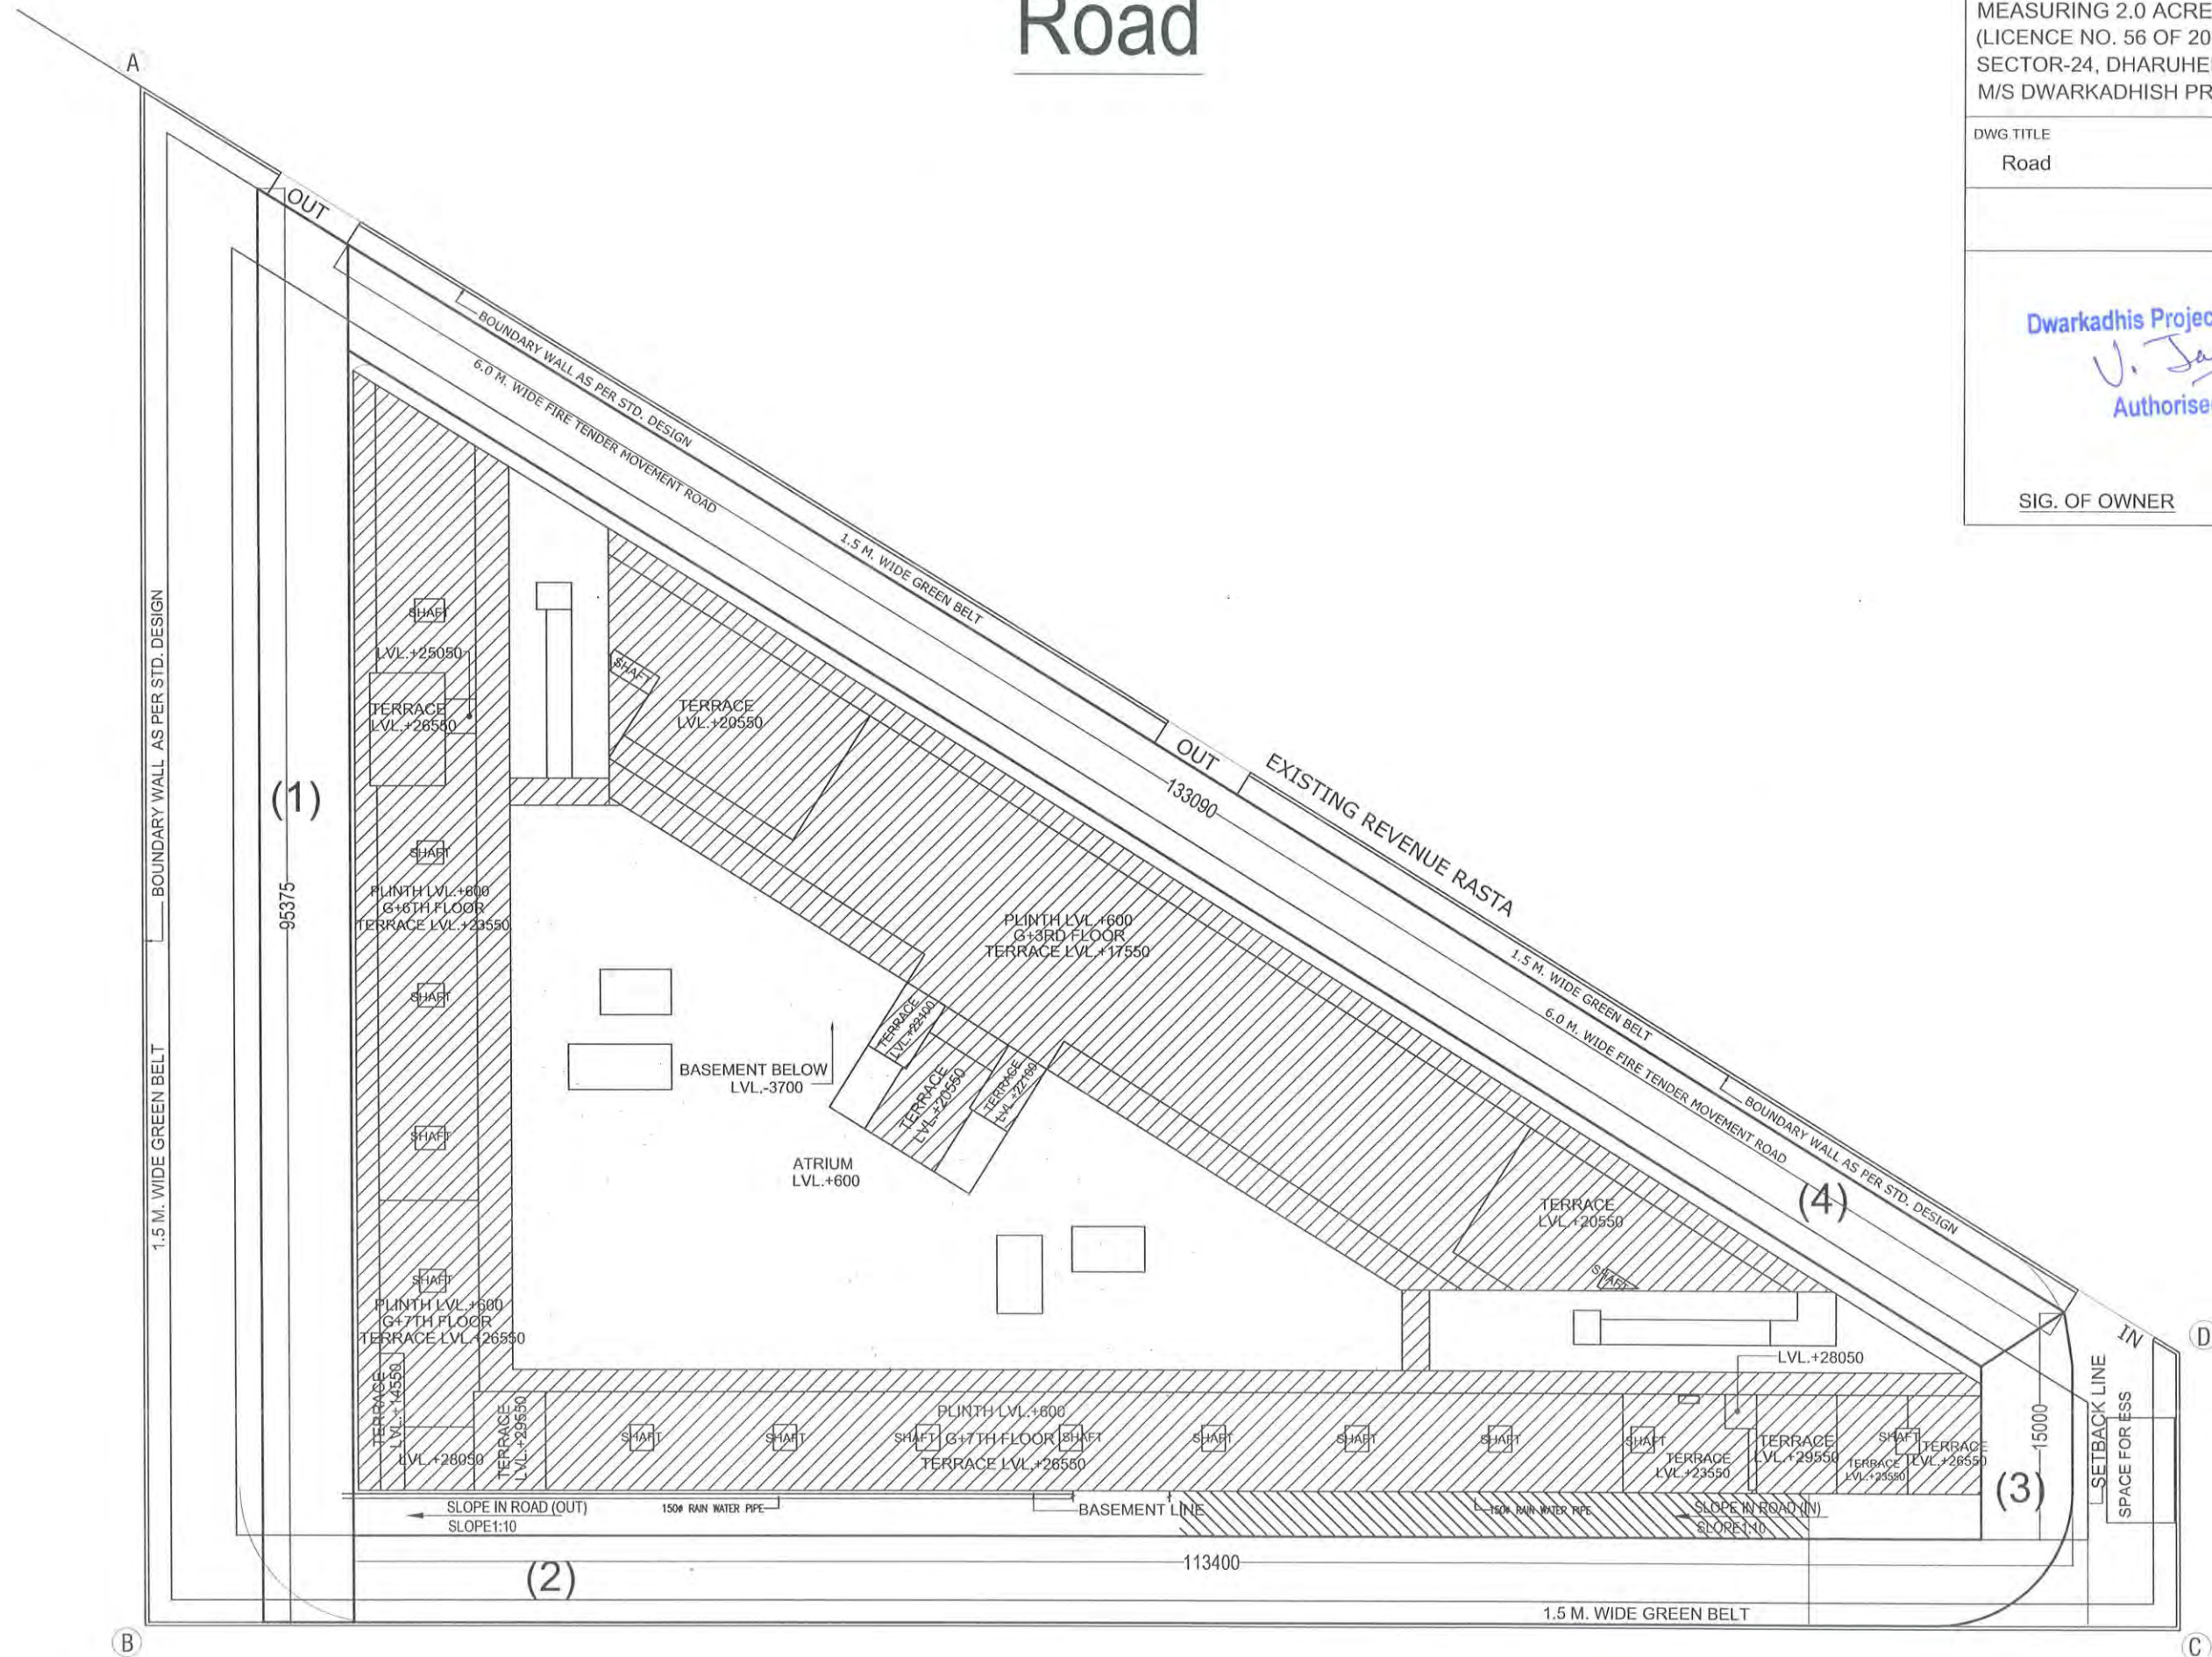SIG. OF ARCHITECT

(RAM ANAND BASSI) A.D.  
 (BALWANT SINGH) S.D.  
 Checked and found ok for Public Health  
 (Internal) Service only subject to comments in  
 forwarding letter No. SE(HQ) 3384 Dt. 23.01.2007  
 Superintending Engineer (HO)  
 HUDA, Panchkula.


A.D. F.O. (HQ)  
 DFS PKL  
 Member B.P.C.

| DOOR WINDOW SCHEDULE |          |              |
|----------------------|----------|--------------|
| S.N.                 | TYPE     | SIZE         |
| 1.                   | DW       | = 2320X2400  |
| 2.                   | R/S      | = 3000X3000  |
| 3.                   | FD       | = 2000X2400  |
| 4.                   | D        | = 1000X2100  |
| 5.                   | D1       | = 900X2100   |
| 6.                   | D2 / D3A | = 750X2100   |
| 7.                   | D3       | = 1200X2100  |
| 8.                   | D4       | = 1200X2100  |
| 9.                   | D5       | = 1800X2100  |
| 10.                  | D6       | = 2000 X2100 |
| 11.                  | D7       | = 950 X2100  |
| 12.                  | D8       | = 950 X2100  |
| 13.                  | D9       | = 2000X2100  |
| 14.                  | W1       | = 1500X2100  |
| 15.                  | W2       | = 1500X900   |
| 16.                  | W3       | = 1800X1800  |
| 17.                  | V/PV1    | = 2500X1200  |


|   |                          |
|---|--------------------------|
| ① | 100% SOIL WASTE PIPE     |
| ② | 100% SOIL VENT PIPE      |
| ③ | 100% WASTE & VENT PIPE   |
| ④ | DOMESTIC WATER SUPPLY DN |
| ⑤ | FLUSHING WATER SUPPLY DN |
| ⑥ | DOMESTIC WATER SUPPLY UP |
| ⑦ | FLUSHING WATER SUPPLY UP |
| ⑧ | 100% RAIN WATER PIPE     |

NOTE:-  
 1. MECHANICAL VENTILATION WILL BE PROVIDED FOR ATRIUM

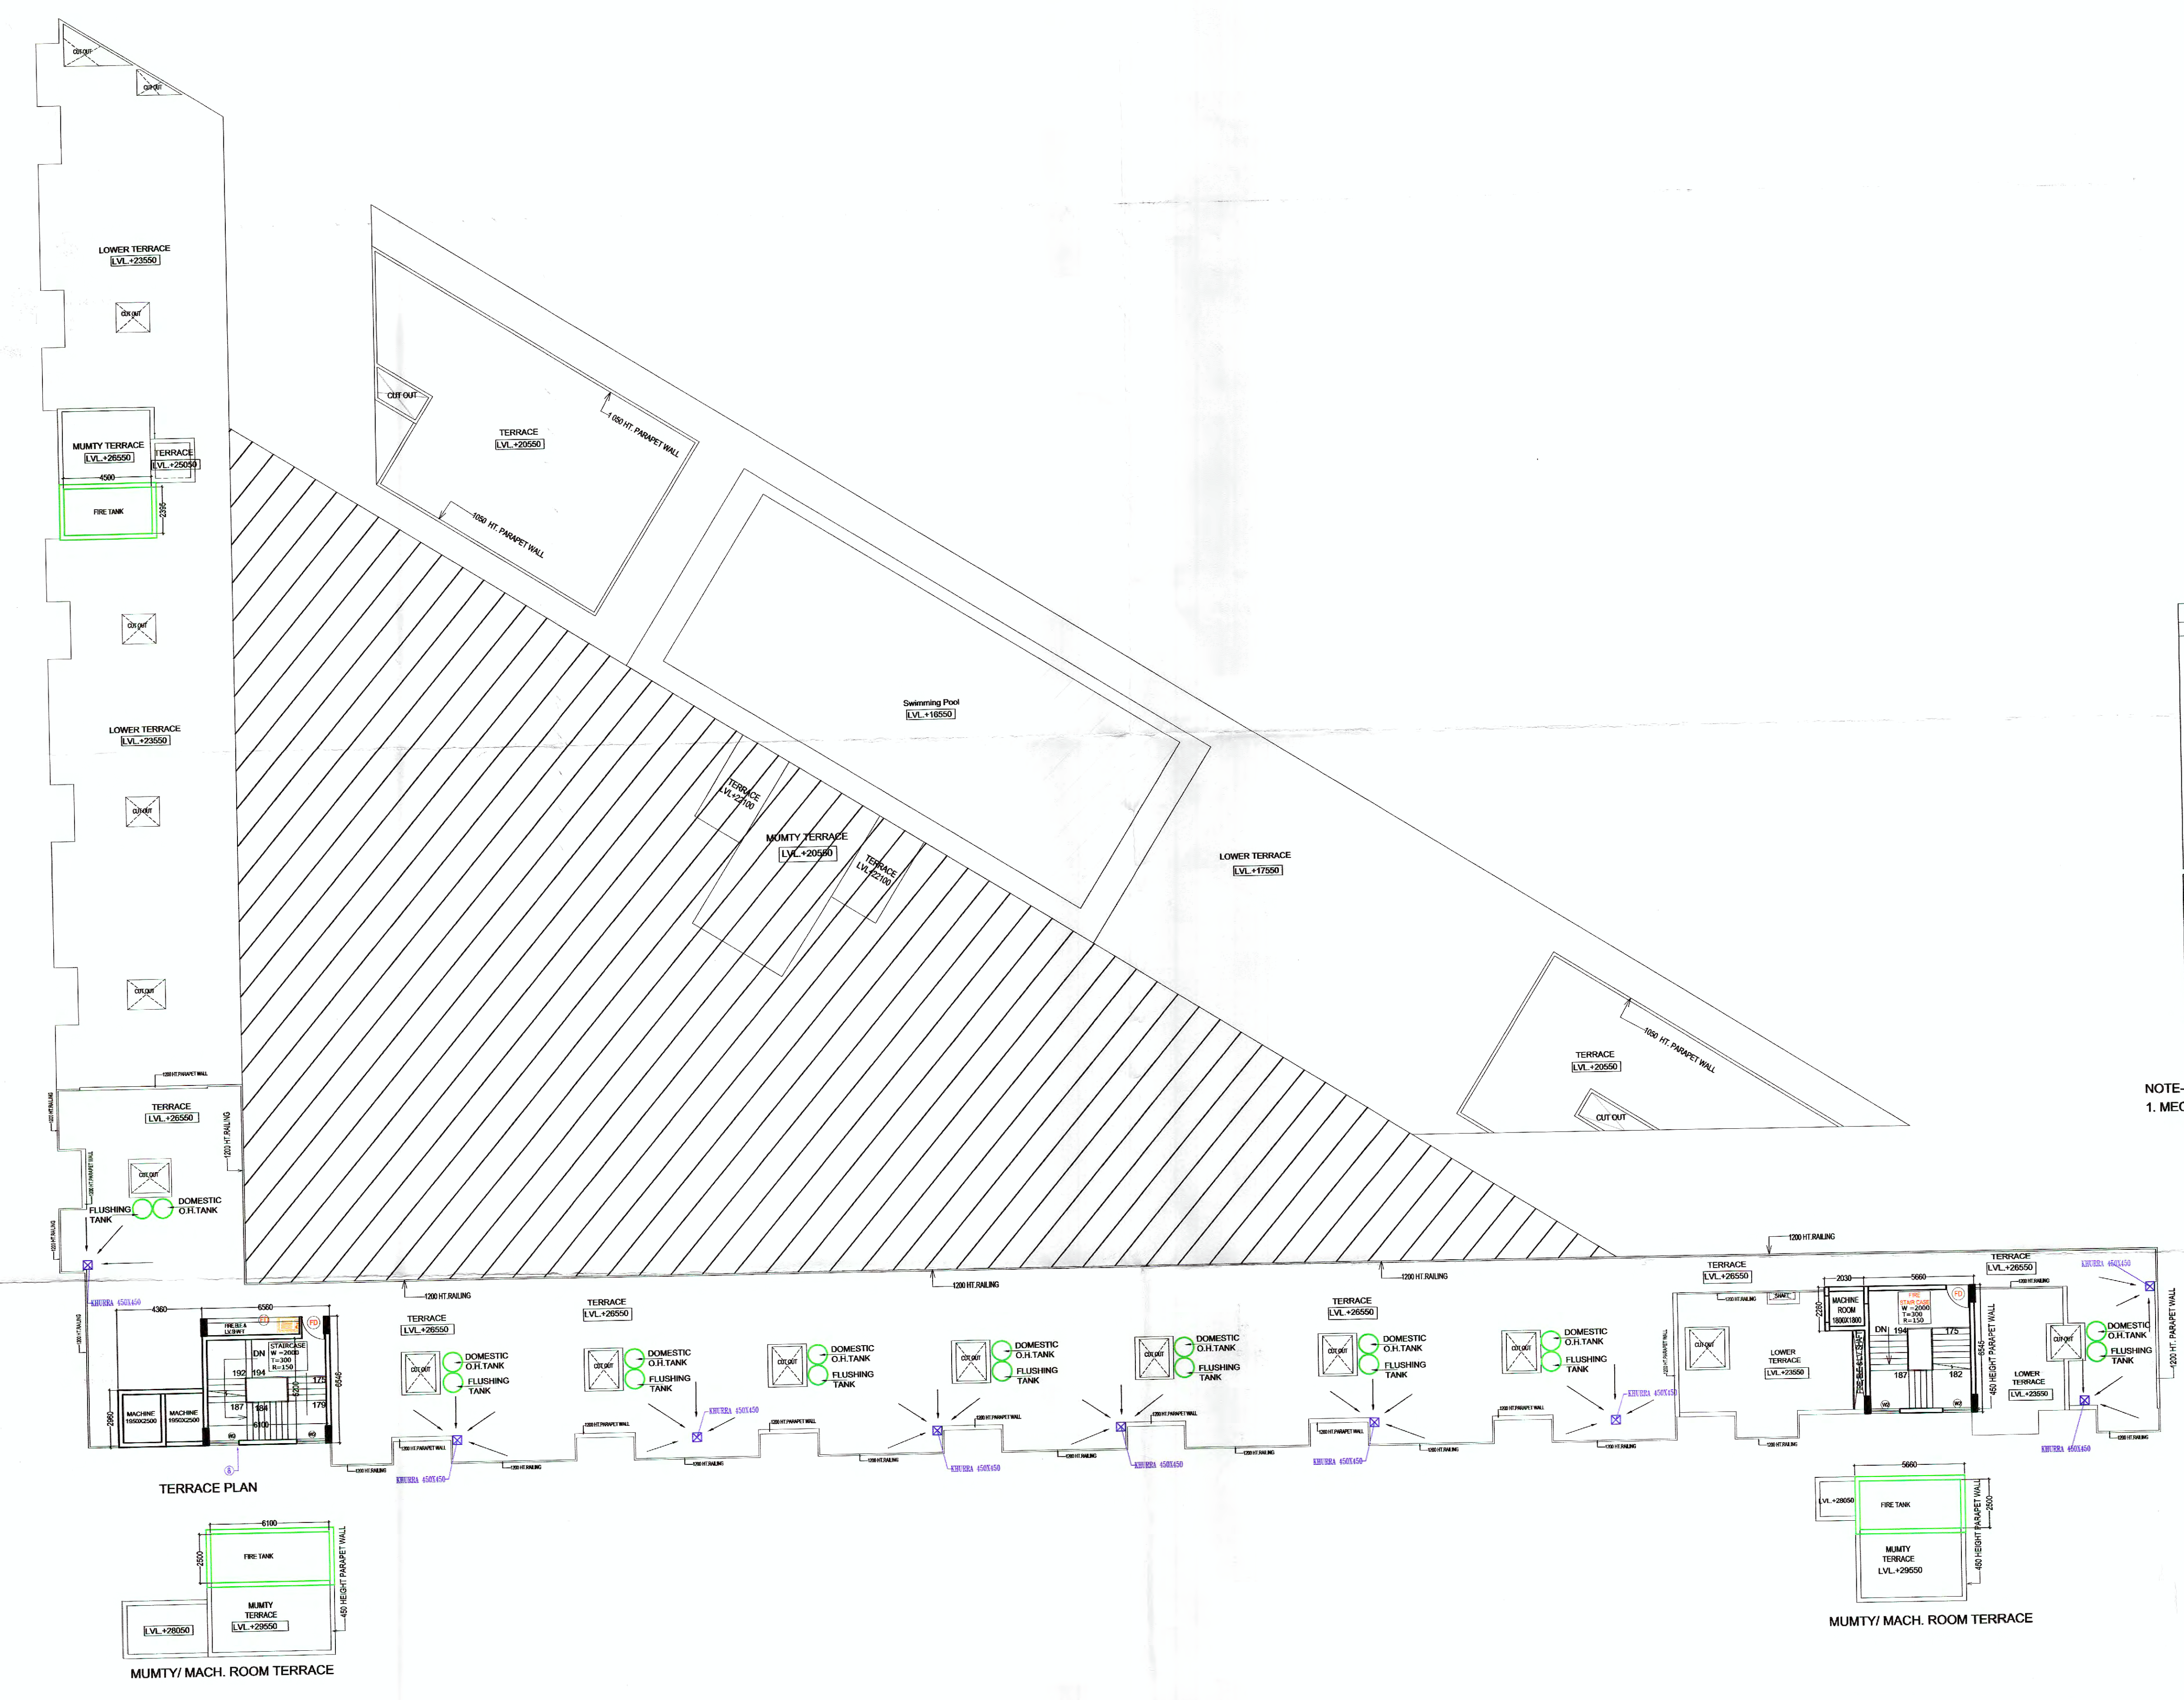


PROJECT:-  
 REVISED BUILDING PLANS OF COMMERCIAL SITE  
 MEASURING 2.0 ACRE  
 (LICENCE NO. 56 OF 2007 DATED 23.01.2007) IN  
 SECTOR-24, DHARUHERA, BEING DEVELOPED BY.  
 M/S DWARKADHISH PROJECTS PVT. LTD.

|                                                                 |                                                       |
|-----------------------------------------------------------------|-------------------------------------------------------|
| DWG TITLE<br>TERRACE PLAN                                       | DRG. NO.<br>A-16                                      |
| SCALE 1:175                                                     |                                                       |
| Dwarkadhis Projects Pvt. Ltd.<br>V. Jau<br>Authorised Signatory | SATYA PARKASH<br>SHARMA<br>ARCHITECT<br>CA/2000/26278 |
| SIG. OF OWNER                                                   | SIG. OF ARCHITECT                                     |

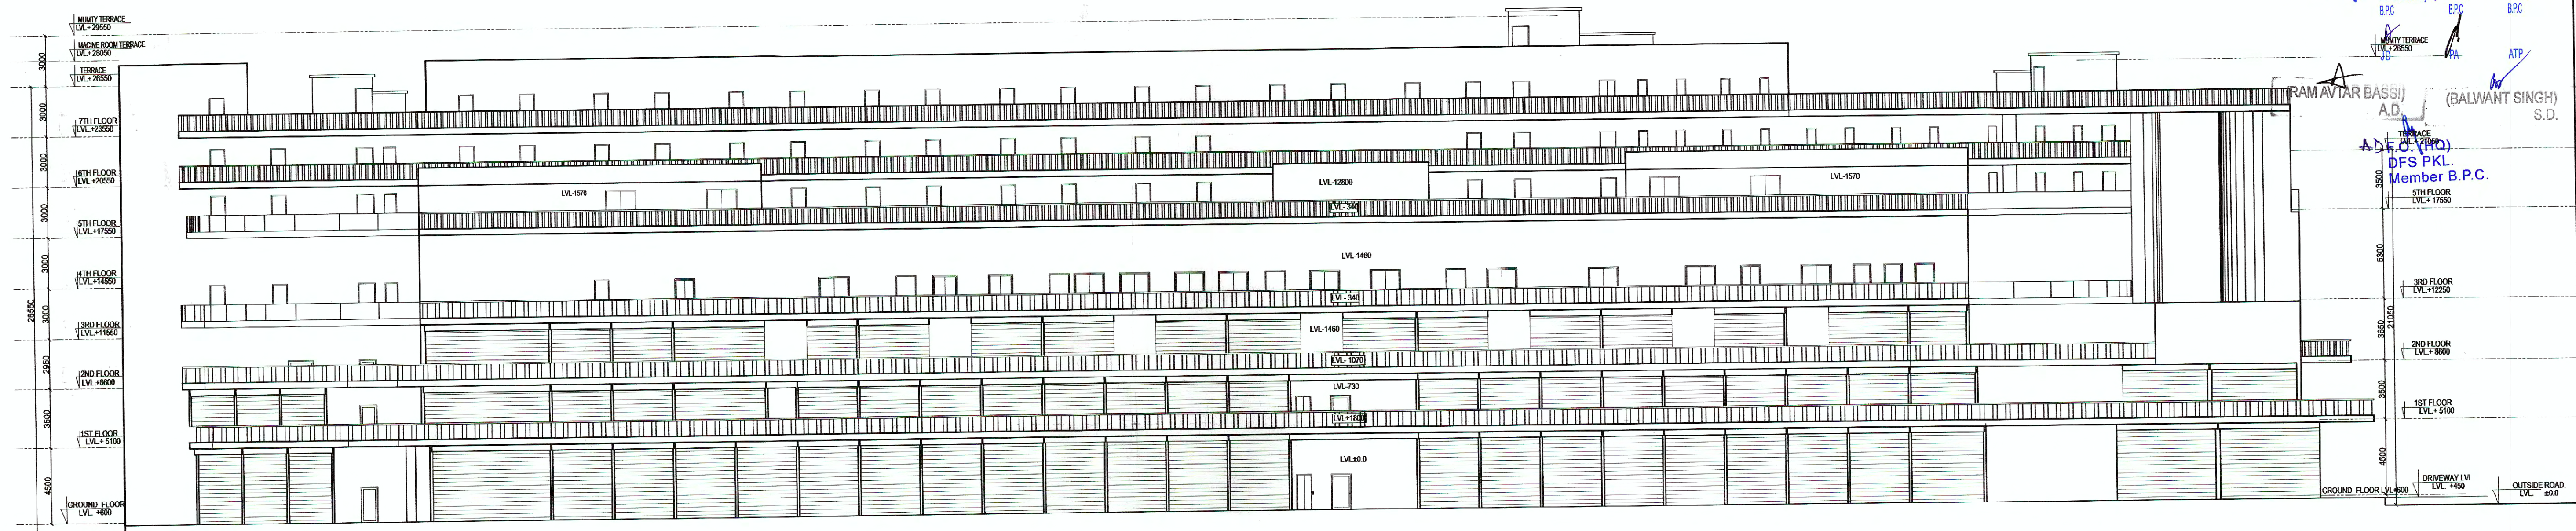

ELEVATION-1

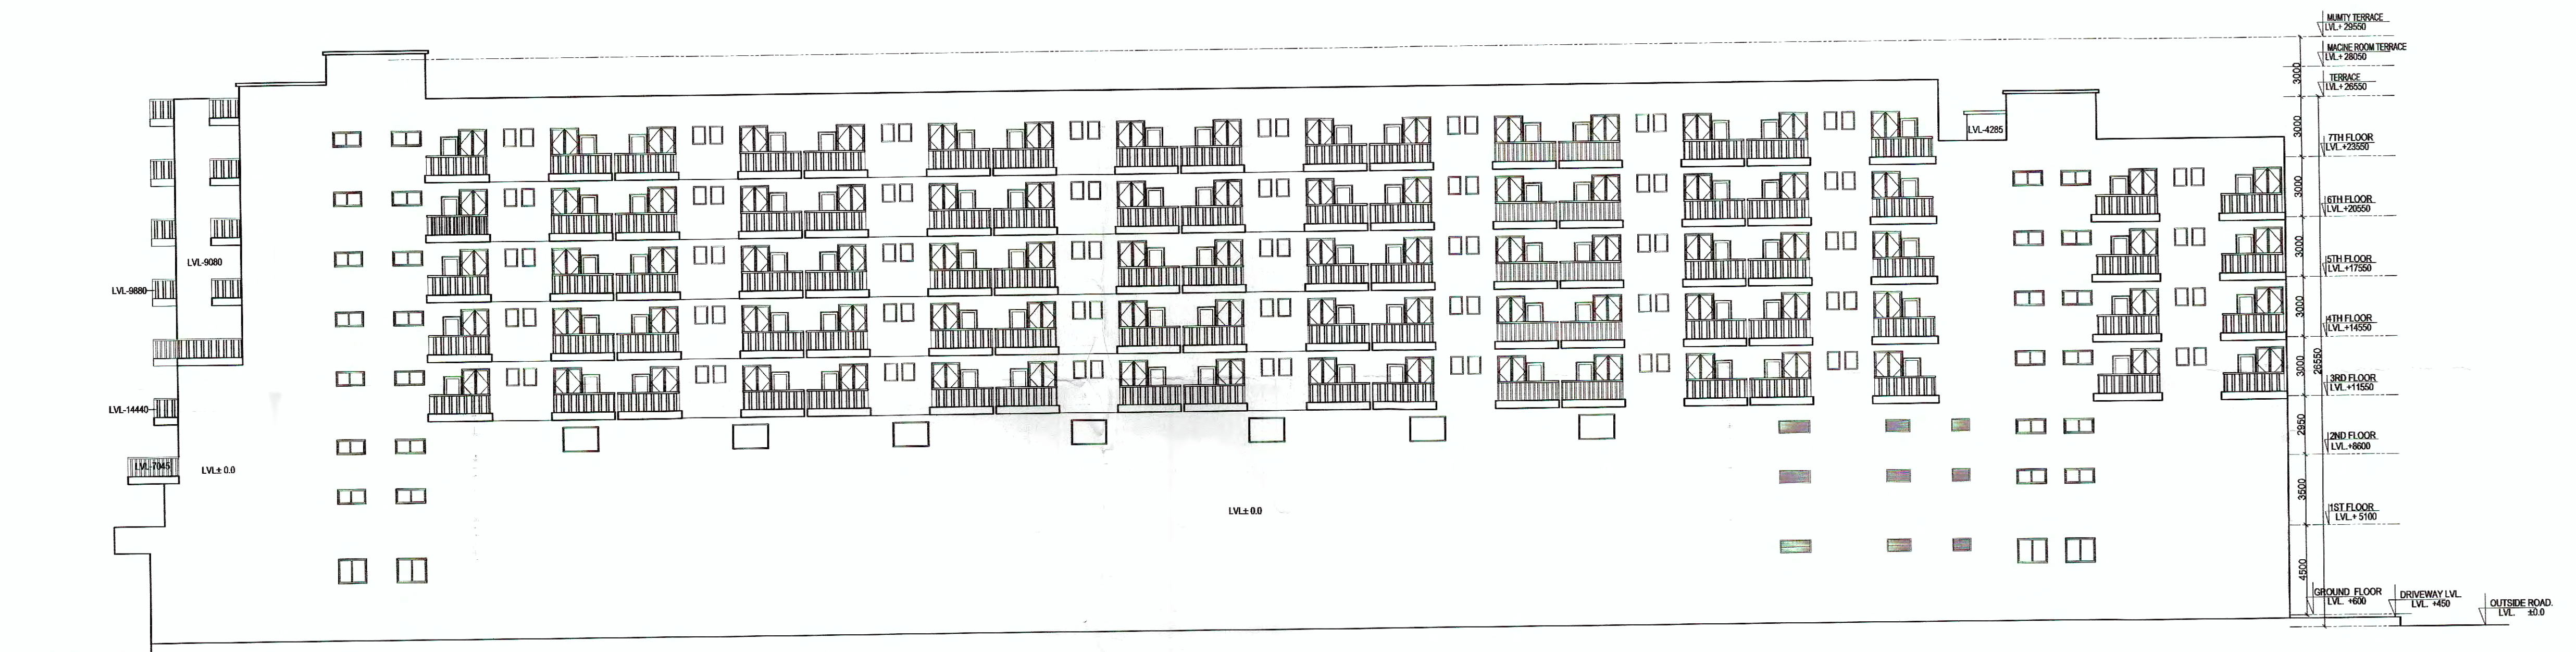

ELEVATION AT 3



ELEVATION-2

PROJECT:-  
REVISED BUILDING PLANS OF COMMERCIAL SITE  
MEASURING 2.0 ACRE  
(LICENCE NO. 56 OF 2007 DATED 23.01.2007) IN  
SECTOR-24, DHARUHERA, BEING DEVELOPED BY:  
M/S DWARKADHISH PROJECTS PVT. LTD.

DWG. TITLE  
ELEVATIONS

DRG. NO. A-17

Dwarkadhis Projects Pvt. Ltd.  
U. Jain  
Authorised Signatory

SIG. OF OWNER

SIG. OF ARCHITECT