


NH - 8

GREEN BELT

24.00M WIDE ROAD

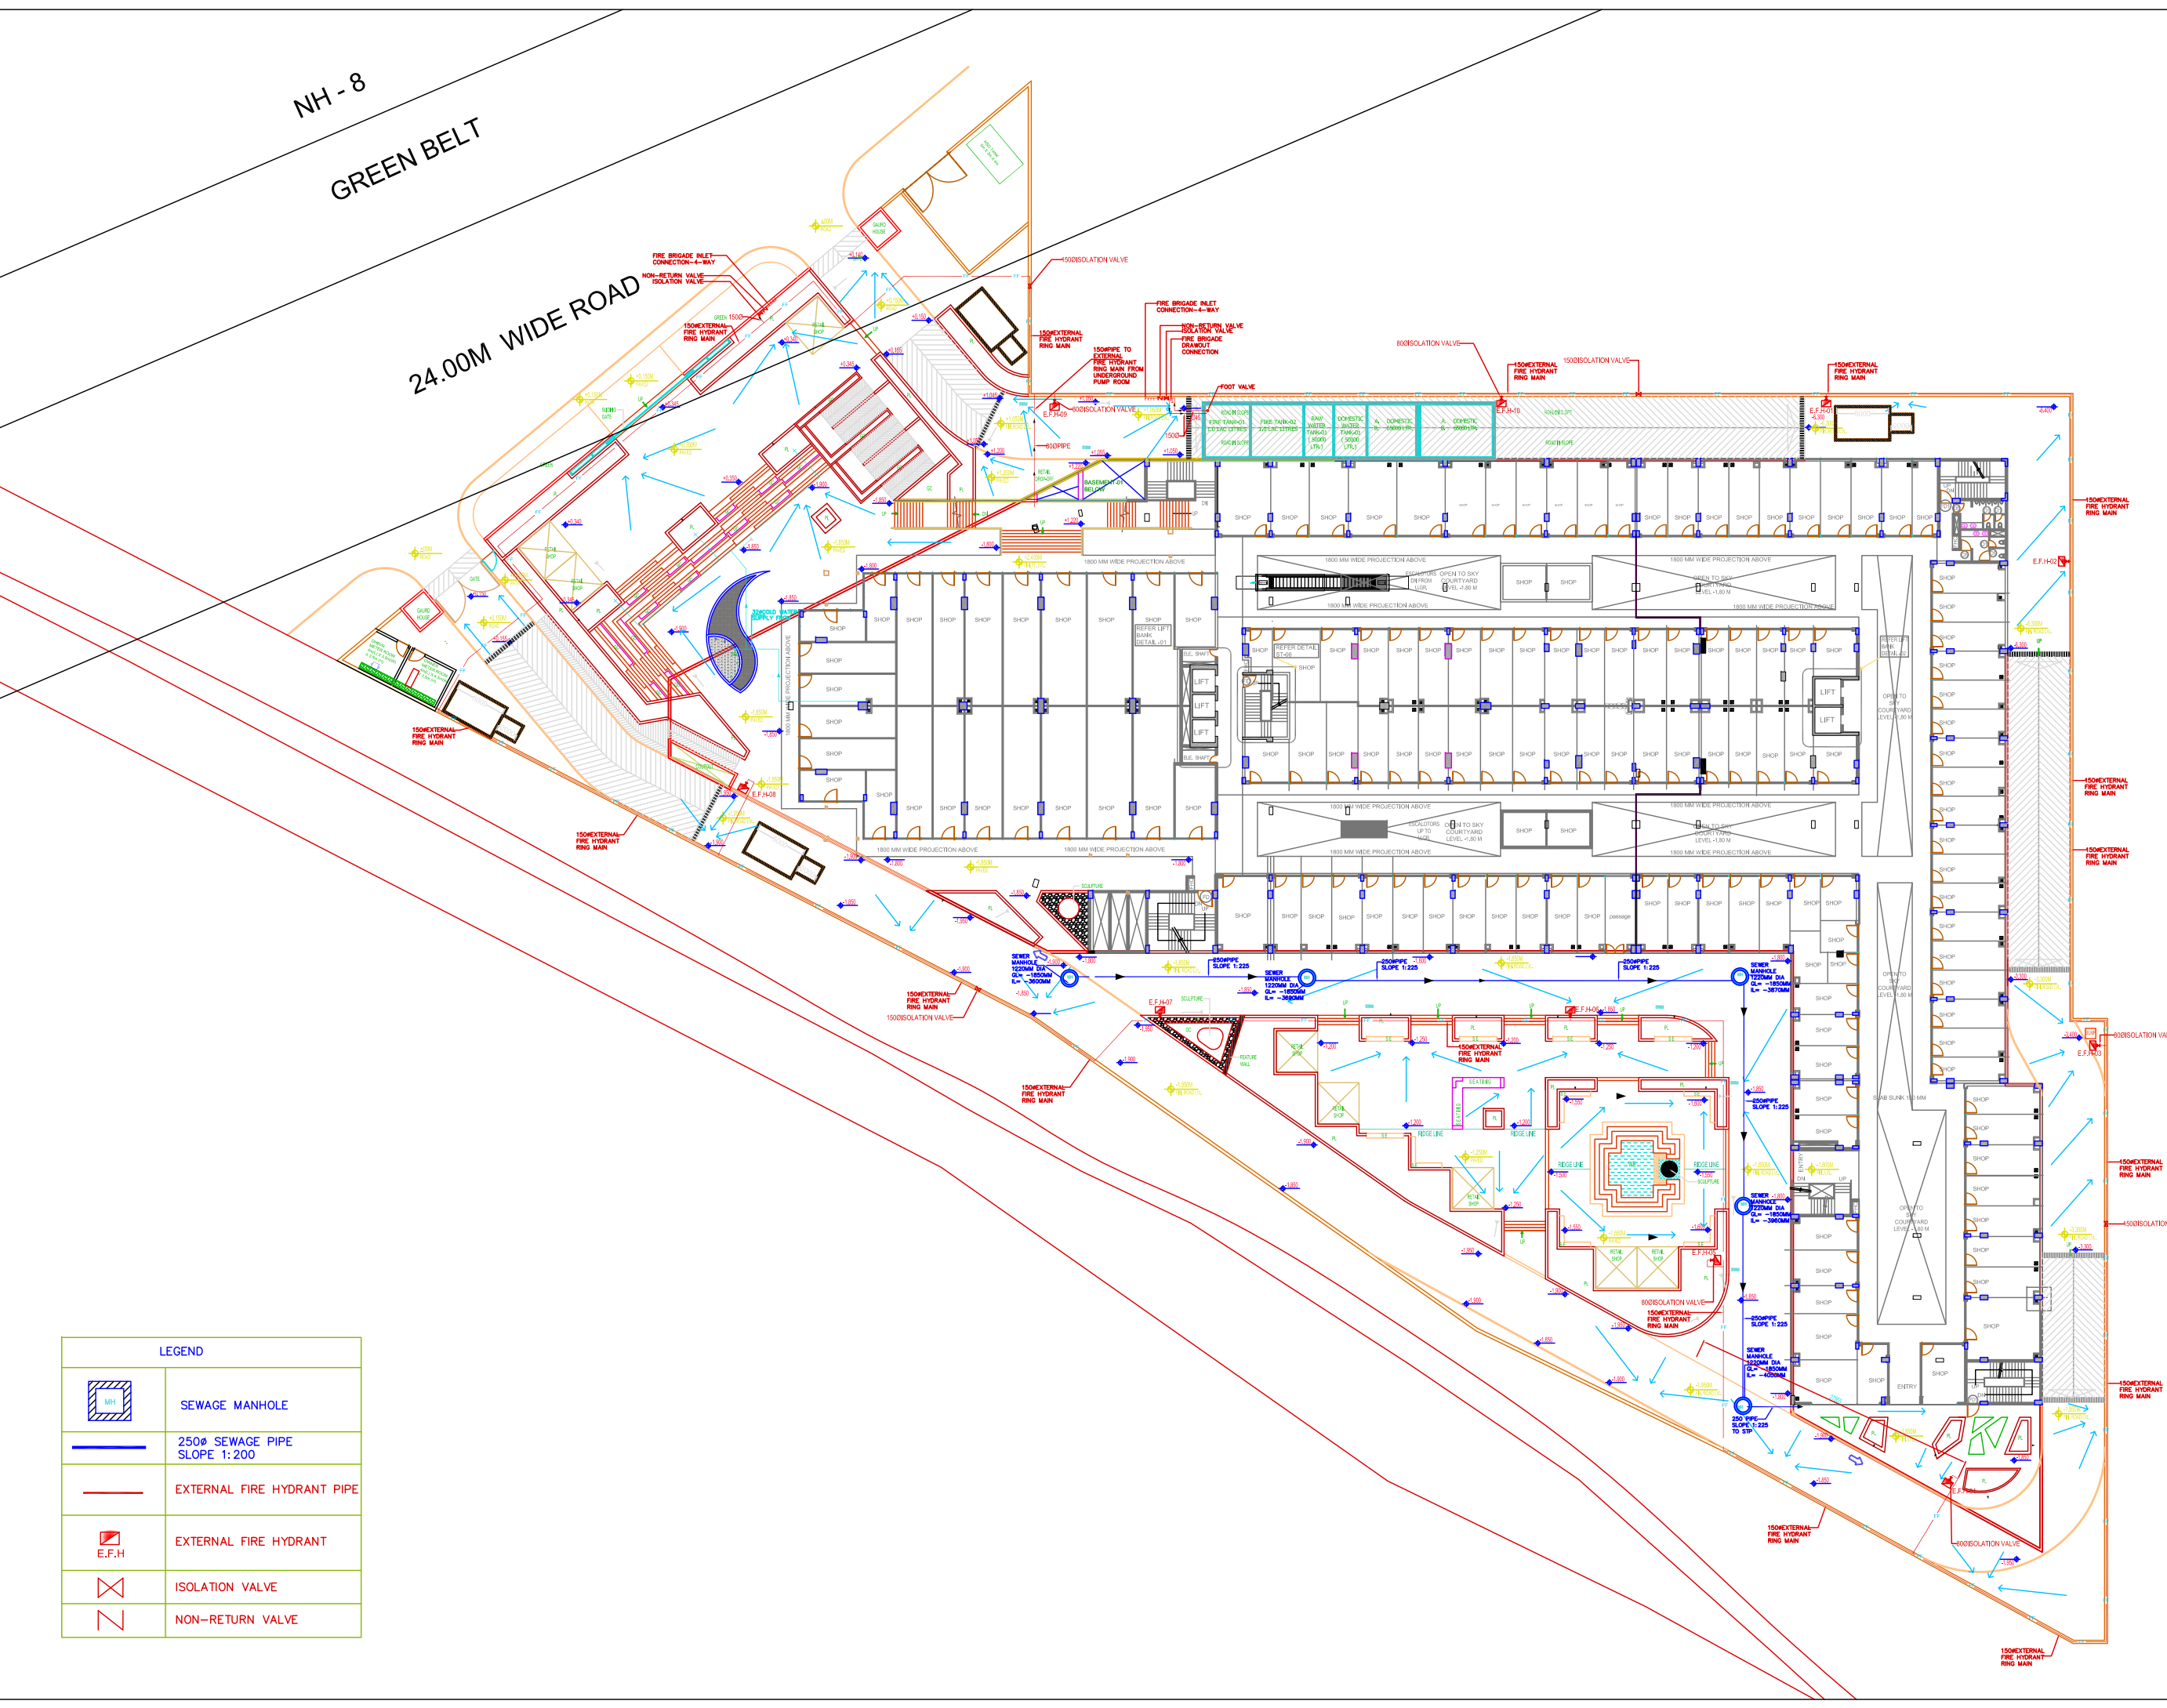

LEGEND	
	SEWAGE MANHOLE
	250 ϕ SEWAGE PIPE SLOPE 1:200
	EXTERNAL FIRE HYDRANT PIPE
	EXTERNAL FIRE HYDRANT
	ISOLATION VALVE
	NON-RETURN VALVE

- Notes :-
1. ALL DIMENSIONS ARE IN MM. UNLESS NOTED OTHERWISE.
 2. ALL LEVELS ARE IN MM. UNLESS NOTED OTHERWISE.
 3. DO NOT SCALE AND FOLLOW WRITTEN DIMENSIONS ONLY.
 4. THIS DRAWING SHOULD BE READ IN CONJUNCTION WITH RELEVANT STRUCTURAL AND SERVICES DRAWINGS. ANY DISCREPANCY SHOULD BE BROUGHT TO THE NOTICE OF THE ARCHITECTS FOR FINAL DECISIONS BEFORE THE COMMENCEMENT OF WORK.
 5. ALL EXTERNAL WALLS ARE 230MM THICK, AND ALL INTERNAL WALLS ARE 100MM UNLESS NOTED OTHERWISE.

REV.	DATE	DESCRIPTION
REVISIONS		

NOTE: THIS DRAWING IS THE PROPERTY OF "JPS DESIGN STUDIO" AND MAY NOT BE COPIED OR USED FOR ANY OTHER PURPOSE WITHOUT PERMISSION OF ITS PRINCIPLES.

MEP CONSULTANTS:

 GUPTA CONSULTANTS & ASSOCIATES
 202, 203, 204, 999, 1000.

STRUCTURAL CONSULTANTS:
 SUDHA TECHNICAL CONSULTANTS
 E-mail: sudha2014@gmail.com
 PHONE: +91-0810212128

ARCHITECTS:
JPS DESIGN STUDIO
 FLAT NO. T-3, MANISH TWIN PLAZA, PLOT NO. 2,
 SECTOR 4, DWARKA, DELHI-110078
 PHONE: 8 01141410230, EMAIL: jpsdesignstudio@gmail.com

CLIENT:-
GREEN HEIGHTS PROJECTS PVT LTD
 Sec-M1D, MANESAR


DRAWING TITLE
**SITE PLAN
 FIRE FIGHTING LAYOUT**

DRAWING NO.	SCALE:
DRAWN	DATE:
CHECKED	DATE:
APPR.	

NH - 8

GREEN BELT

24.00M WIDE ROAD

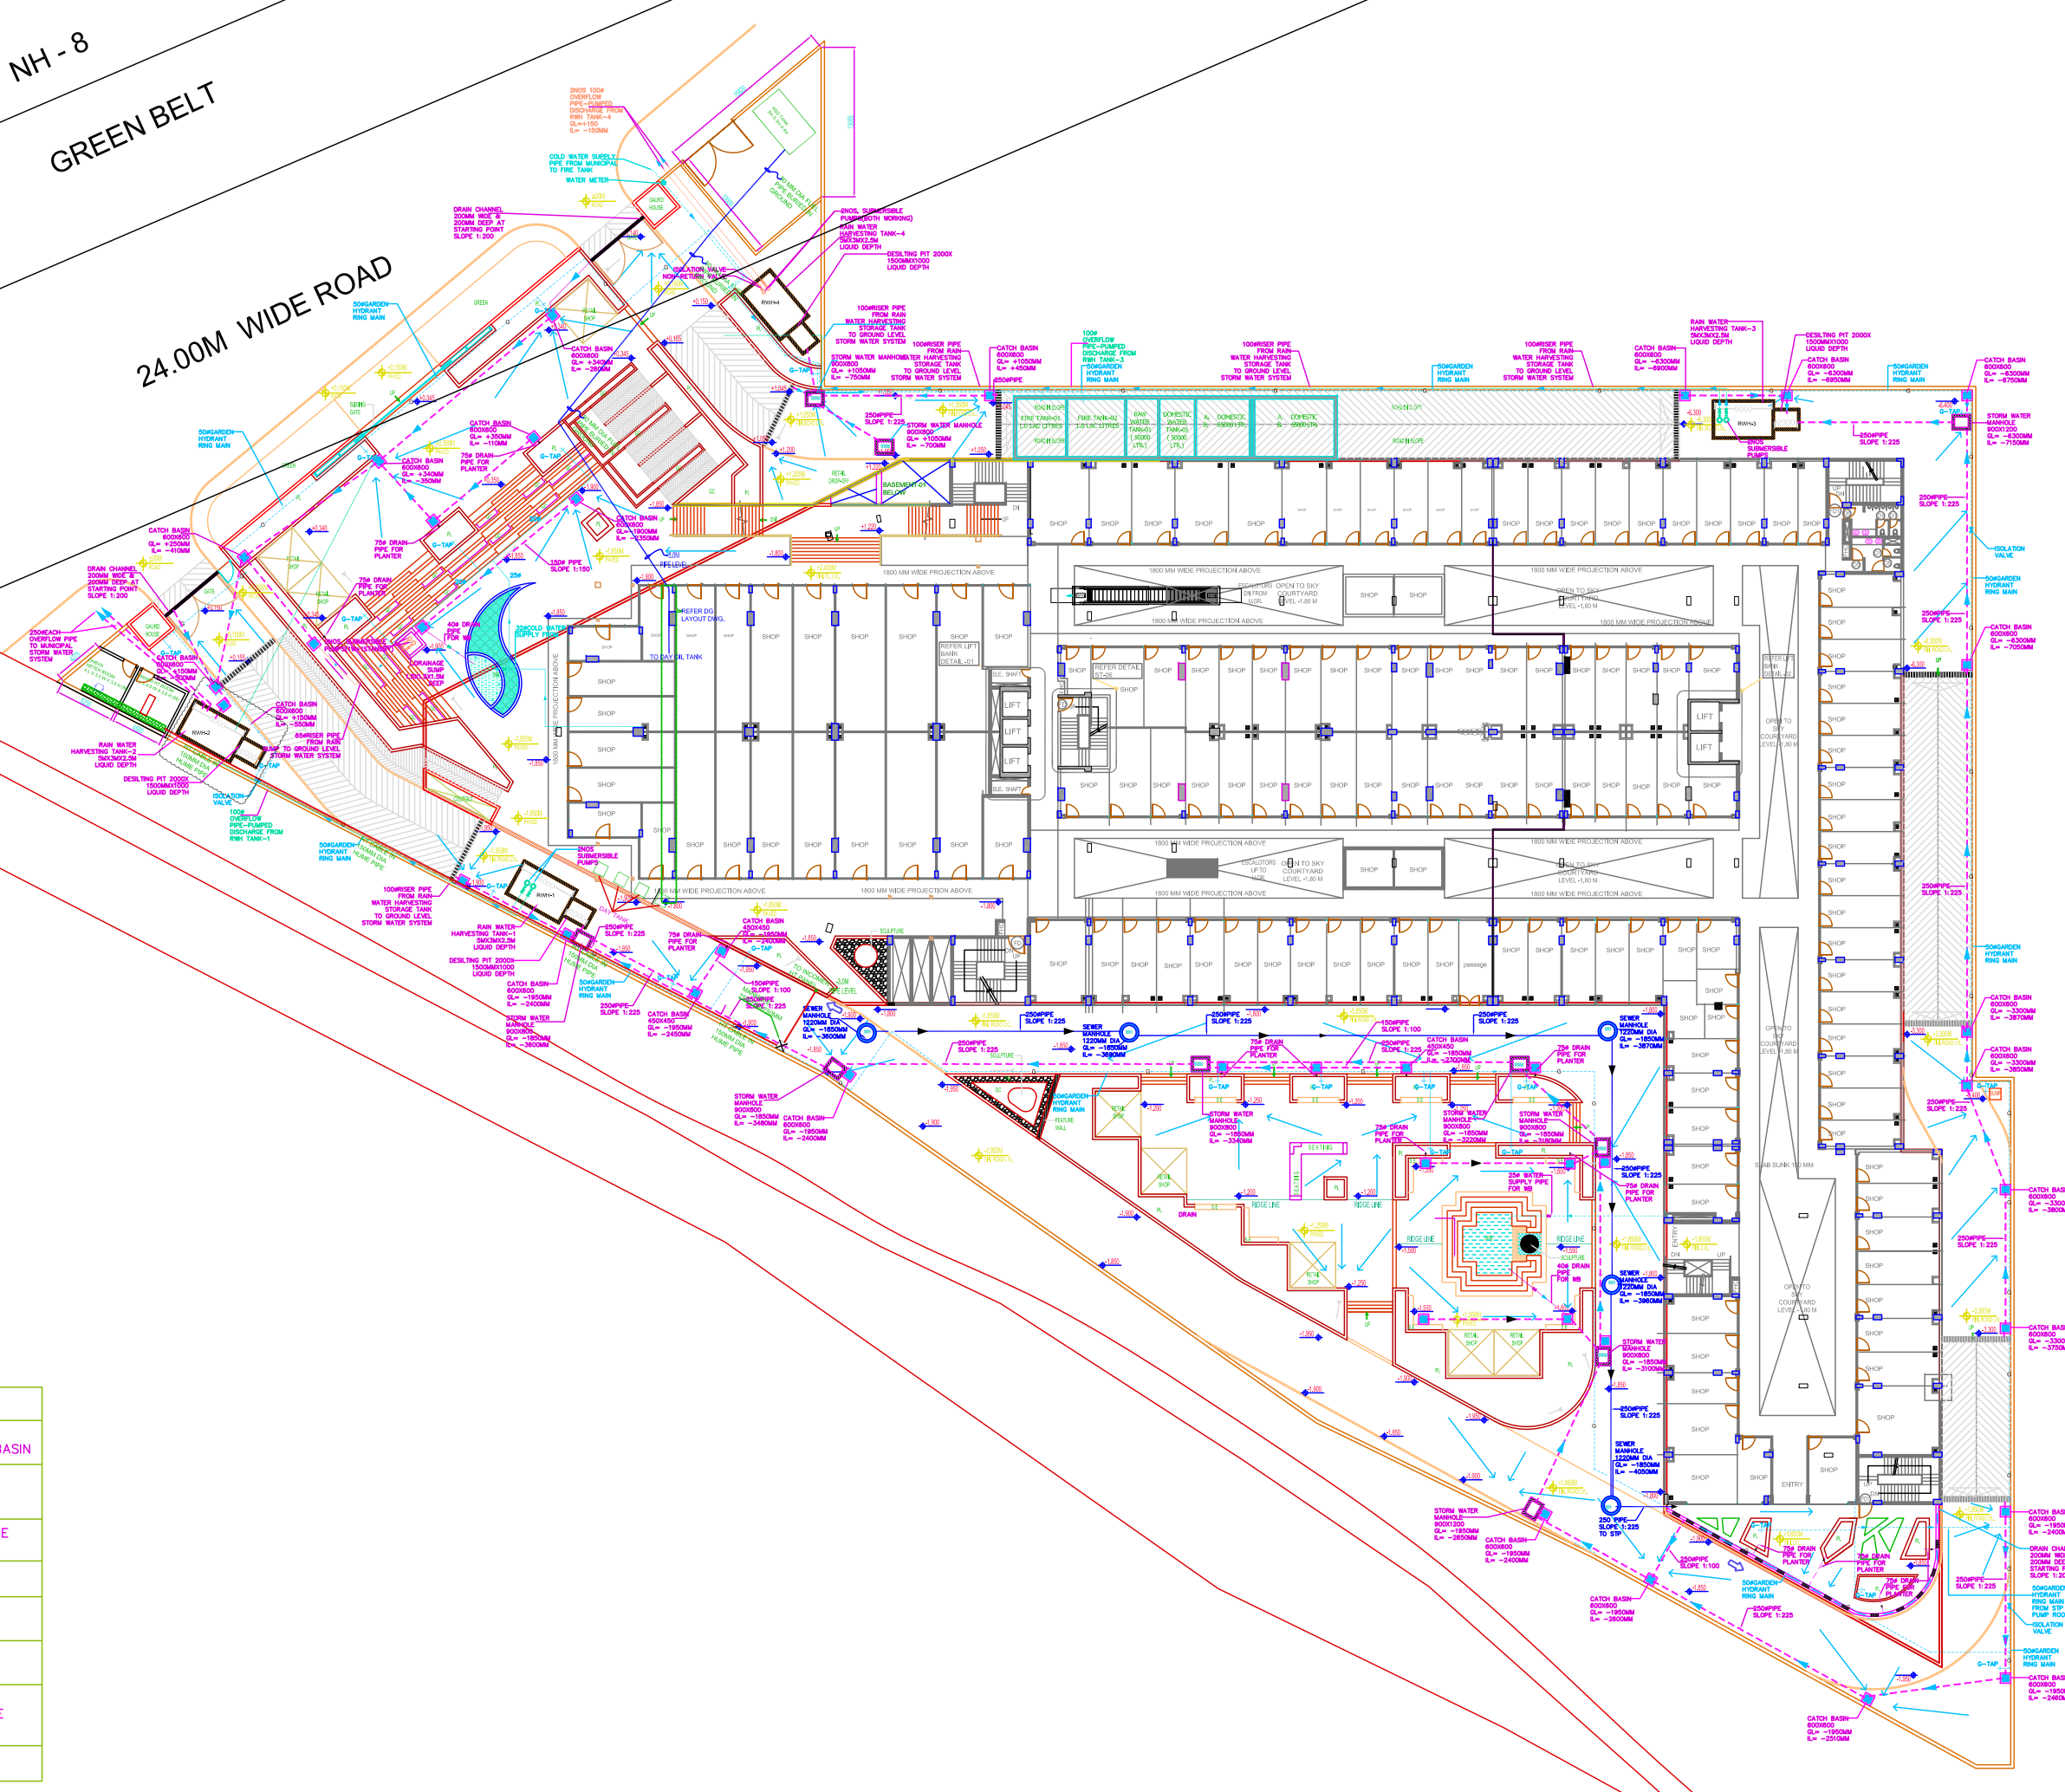

LEGEND	
	STORM WATER CATCH BASIN
	SEWAGE MANHOLE
	250 ϕ STORM WATER PIPE SLOPE 1:225
	250 ϕ SEWAGE PIPE SLOPE 1:200
	GARDEN HYDRANT PIPE
	G-TAP
	STORM WATER MANHOLE

- Notes :-
1. ALL DIMENSIONS ARE IN MM. UNLESS NOTED OTHERWISE.
 2. ALL LEVELS ARE IN MM. UNLESS NOTED OTHERWISE.
 3. DO NOT SCALE AND FOLLOW WRITTEN DIMENSIONS ONLY.
 4. THE DRG. SHOULD BE READ IN CONJUNCTION WITH RELEVANT STRUCTURAL AND SERVICES DRGS. ANY DISCREPANCY SHOULD BE BROUGHT TO THE NOTICE OF THE ARCHITECTS FOR FINAL DECISIONS BEFORE THE COMMENCEMENT OF WORK.
 5. ALL EXTERNAL WALLS ARE 230MM THICK, AND ALL INTERNAL WALLS ARE 100 THK. UNLESS NOTED OTHERWISE.

REV.	DATE	DESCRIPTION
REVISIONS		

NOTE: THIS DRAWING IS THE PROPERTY OF "JPS DESIGN STUDIO" AND MAY NOT BE COPIED OR USED FOR ANY OTHER PURPOSE WITHOUT PERMISSION OF ITS PRINCIPALS.

MEP CONSULTANTS:

 SUDHA TECHNICAL CONSULTANTS
 E-mail: sudhatech@gmail.com
 PHONE: 91-8860212128

ARCHITECTS:
JPS DESIGN STUDIO
 FLAT NO. T-3, MANISH TWIN PLAZA, PLOT NO. 2,
 SECTOR 4, DWARKA, DELHI-110078
 PHONE: 811141410230, EMAIL: jpsdesignstudio@gmail.com

CLIENT:-
GREEN HEIGHTS PROJECTS PVT LTD
 Sec-M1D, MANESAR

DRAWING TITLE
SITE PLAN PLUMBING LAYOUT

DRAWING NO.	SCALE:
DRAWN	DATE:
CHECKED	DATE:
APPR.	


- NOTES :-
1. ALL DIMENSIONS ARE IN MM, UNLESS NOTED OTHER WISE.
 2. ALL LEVELS ARE IN MM, UNLESS NOTED OTHER WISE.
 3. DO NOT SCALE ANY DRG. FOLLOW WRITTEN DIMENSIONS ONLY.
 4. THIS DRG. SHOULD BE READ IN CONJUNCTION WITH RELEVANT STRUCTURAL AND SERVICE DRGS. ANY DISCREPANCY SHOULD BE BROUGHT TO THE NOTICE OF THE ARCHITECTS FOR FINAL DECISIONS BEFORE THE COMMENCEMENT OF WORK.

PLUMBING LEGEND:-

(1)	1100 WASTE & VENT PIPE
(2)	1100 SOIL & VENT PIPE
(3)	CWS DROP PIPE
(4)	RISER TO OHT.
(5)	FLOOR TRAP
(6)	FLOOR DRAIN
(7)	32Ø DROP PIPE
(8)	40Ø DROP PIPE
(9)	110Ø PIPE
(10)	160ØRWP
(11)	FLOOR CLEAN OUT
(12)	DROP CONN. WITH DOOR BEND
(13)	FWS DROP PIPE
(14)	FWS RISER PIPE

PLUMBING LEGEND:-

CWS	COLD WATER SUPPLY PIPE
CWR	COLD WATER RISER PIPE
FWS	FLUSHING WATER SUPPLY PIPE
FWR	FLUSHING WATER RISER PIPE

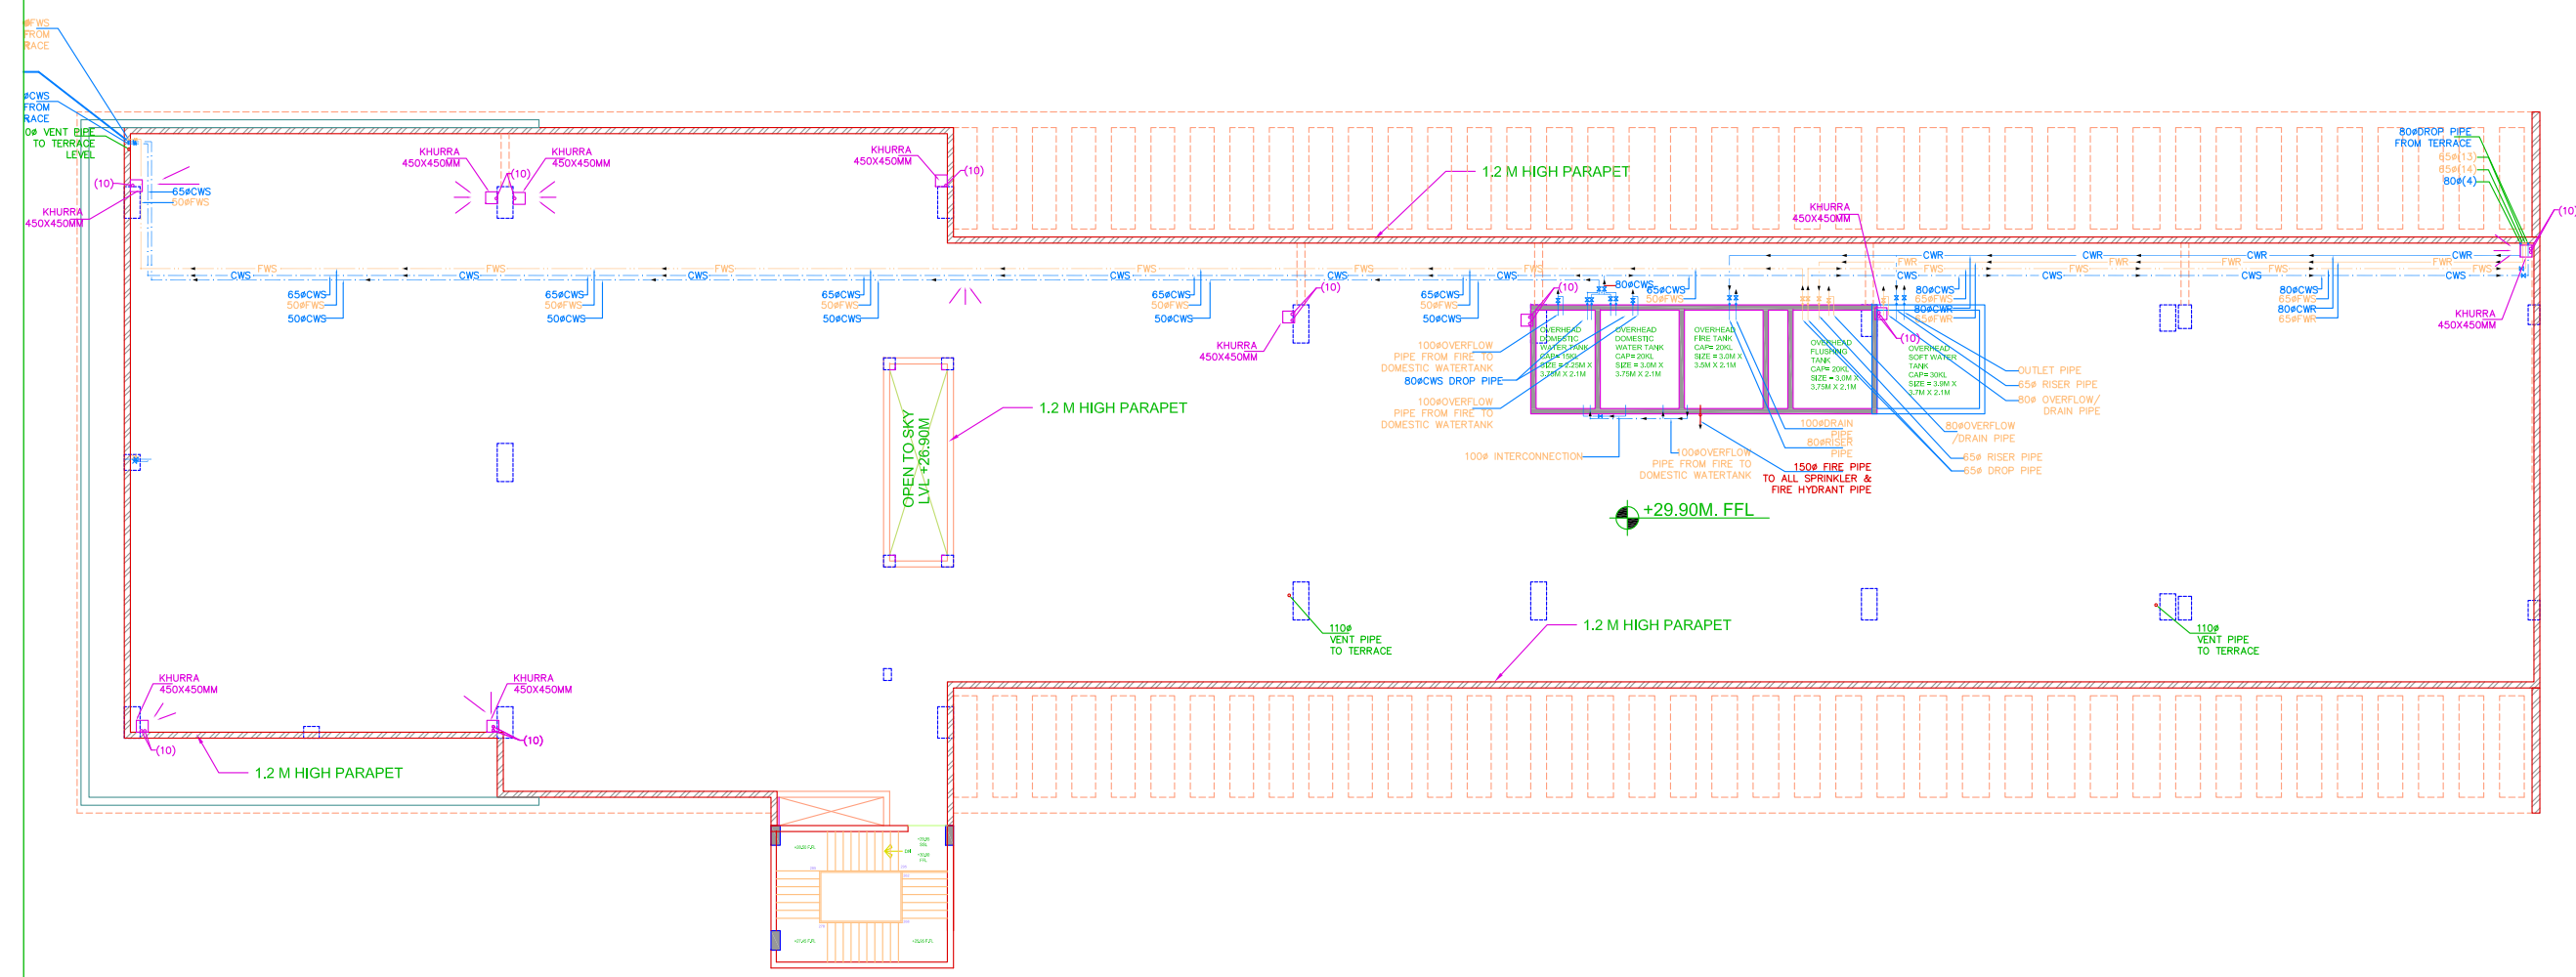

TERRACE FLOOR PLAN
LVL. +29.90 M
SCALE - 1:200

REV.	DATE	DESCRIPTION
REVISIONS		
MEP CONSULTANTS:		

STRUCTURAL CONSULTANTS:
SUDHA TECHNICAL CONSULTANTS
E-mail :- mail@gmail.com
PHONE :- 91-9810211218

ARCHITECTS:
JPS DESIGN STUDIO
FLAT NO. T-3, MANISH TWIN PLAZA, PLOT NO. 2,
SECTOR 4, DWARKA, DELHI-110078
PHONE # 01141410230, EMAIL:
jpsdesignstudios@gmail.com

CLIENT:-
GREEN HEIGHT PROJECTS PVT. LTD.
M1D, MANESAR GURGAON

DRAWING NO.

DRAWN		SCALE:	
CHECKED		DATE:	
APPR.			