


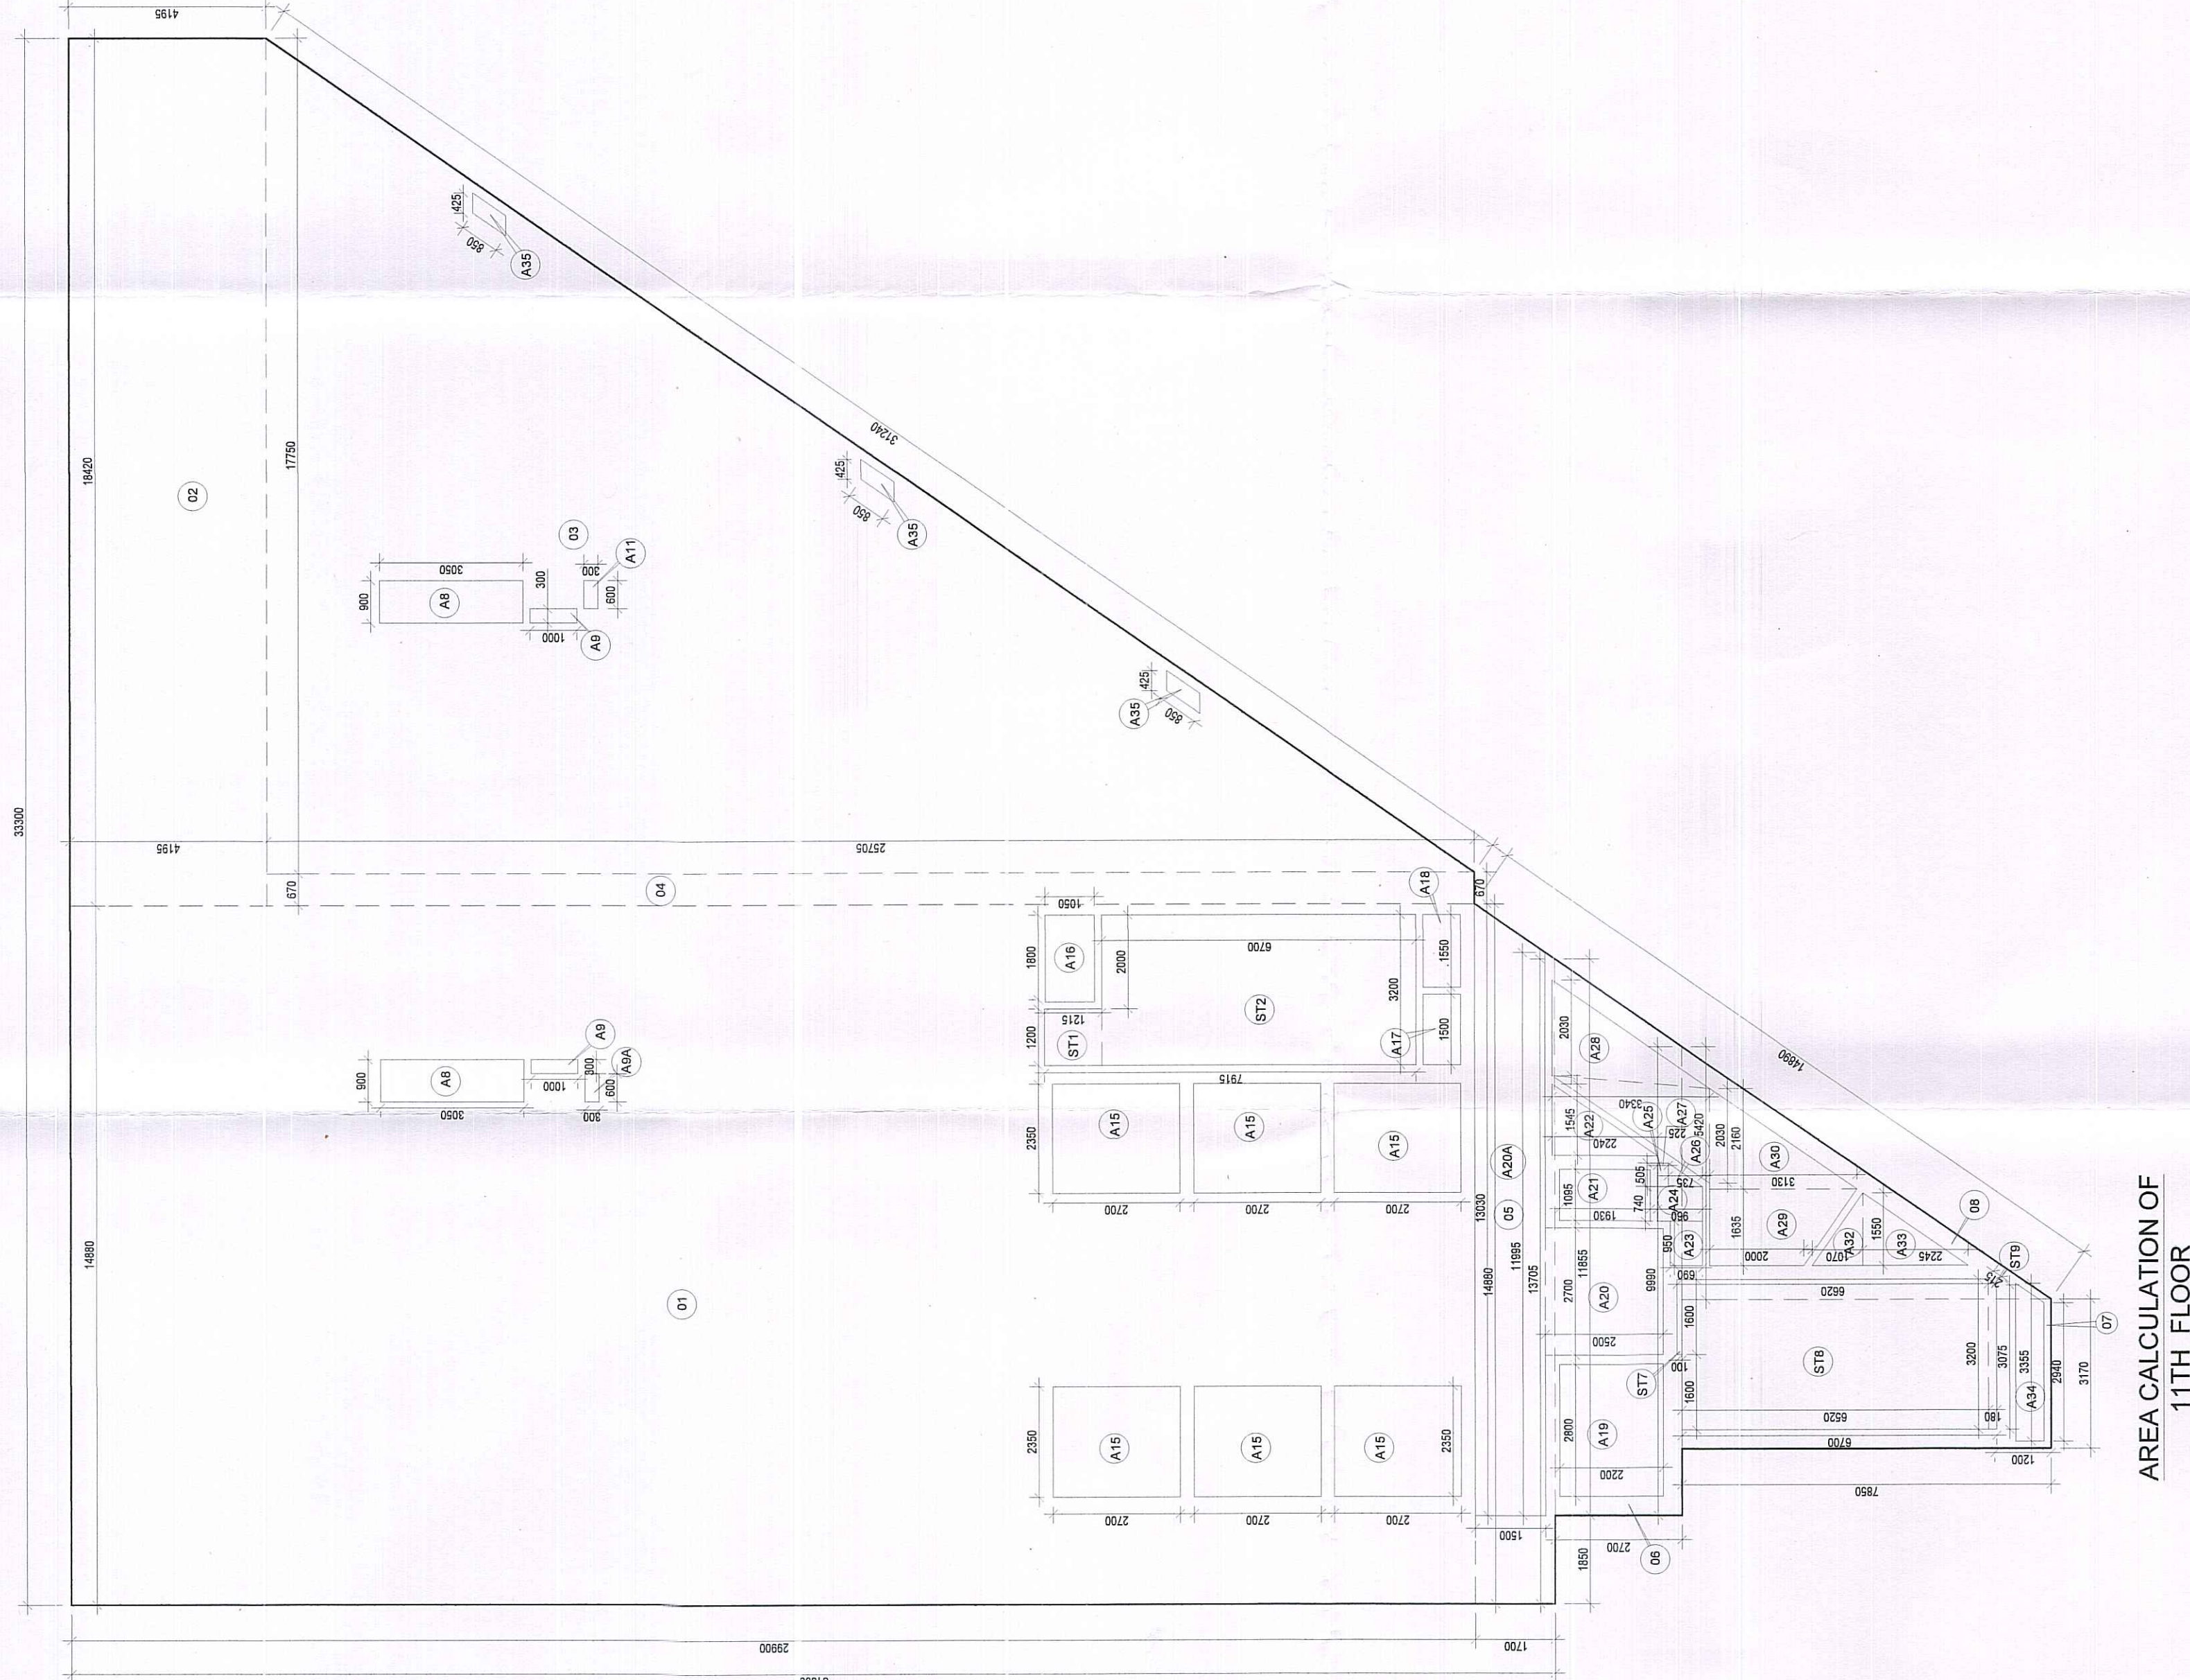

AREA CALCULATION OF THE FLOOR									
(All Dimensions are in meter & in Feet)									
BASELINE		NO.1		WITHIN		OUTSIDE		AREA (SQ. METERS)	
1	14.880	2	21.900	3	21.900	4	21.900	5	444.571
6	14.880	7	14.880	8	14.880	9	14.880	10	222.285
11	3.05	12	17.750	13	21.900	14	21.900	15	228.112
16	3.05	17	14.880	18	14.880	19	14.880	20	222.285
21	14.880	22	14.880	23	14.880	24	14.880	25	222.285
26	3.05	27	14.880	28	14.880	29	14.880	30	222.285
31	3.05	32	14.880	33	14.880	34	14.880	35	222.285
36	3.05	37	14.880	38	14.880	39	14.880	40	222.285
626	3.05	627	14.880	628	14.880	629	14.880	630	222.285
631	3.05	632	14.88						

ALL FLOOR MECHANICAL VENTILATED LIGHTED & 100% POWER BACKUP. AIR CONDITIONING SYSTEM IS BEING PROVIDED. DG POWER BACKUP IS BEING PROVIDED. TOILET ARE MECHANICAL VENTILATED. ALL LIFT'S SHALL HAVE POWER BACK-UP. ALL ELECTRICAL INSTALLATION SHALL BE AS PER PREVIOUS S&P PROVISION CODE. FIRE FIGHTING S&P REQUIREMENTS WILL BE AS PER RELEVANT CODE. BASEMENT AREA SHALL HAVE MECHANICALLY VENTILATED AS PER RELEVANT CODE. ALL TOILETS ARE VENTILATED AS PER RAHWATA BUILDING CODE 2017. BUILDINGS SHALL BE AIR CONDITIONER. BUILDINGS SHALL BE PROVIDED BY RELEVANT CODE. BUILDING IS BEING DESIGNED AS PER RELEVANT CODE. BUILDING STRUCTURES AS PER RELEVANT STRUCTURES AS PER RELEVANT CODE. SOIL AS PANELS OF REQUIRED CAPACITY SHALL BE PROVIDED AS PER HAZ DAZING NORMS. ALL HANDICAP FIGHTING WITH RAILING. ALL FIRE FIGHTING INSTALLATIONS SHALL BE AS PER PROVISION OF RELEVANT CODE. THE RAHWATA HARVESTING SYSTEM SHALL BE PROVIDED AS PER CENTRAL GROUND WATER AUTHORITY NORMS.

PROJECT: PROPOSED BUILDING PLAN OF COMMERCIAL
COMPLEX SITE AREA 1.196 ACRES
(4843.03 SQM) IN SECTOR 28, GURUGRAM

SANCTIONED

Vide Memo No.....Dated 20/12/2013

OWNER'S
ACQUISITIVE INFRADEVELOPERS PVT. LTD.,
WITH LODHA DEVELOPERS LIMITED.

<i>[Signature]</i>	DTP (HQ)	Member	BPAC
<i>[Signature]</i>		Chairman	BPAC

For ACQUISITIVE INFRADEVELOPMENT PVT. LTD.
Saurabh
Authorized Signatory

MAY-2026	Scale : 1:100	F30 (HO) Member
Drawing Title: -		Drawn By: -

Checked and found ok for Public Health
Tower 01
(Internal use only) subject to comments in T1-08
11TH FLOOR PLAN &
in SPECIALIZATION

Senior Engineering Engineer (HQ)
of Engineer-I
P. Panchkula

PLUMBING LEGEND:-	
1	100Ø SOL PIPE
2	100Ø WASTE PIPE
3	75Ø ANTI-SYPHONAGE PIPE
4	DOMESTIC WATER SUPPLY PIPE DOWN-TAKE TOP 4 FLOOR
5	DOMESTIC WATER SUPPLY PIPE DOWN-TAKE
6	FLUSHING WATER SUPPLY PIPE DOWN-TAKE
7	150Ø RAIN WATER PIPE
8	DOMESTIC WATER SUPPLY RISER
9	FLUSHING WATER SUPPLY RISER
10	150Ø RAIN WATER PIPE FOR BALCONY
COP	CLEAN OUT PLUG
■ FT	FLOOR TRAP WITH (150Ø SLEEVE OR 150X150MM CUTOUT)
■ FD	FLOOR DRAIN WITH (125Ø SLEEVE OR 125X125MM CUTOUT)
■ WC	WC DROP WITH (150Ø SLEEVE OR 150X150MM CUTOUT)

S No.	FIRE FIGHTING LEGEND:-
(A)	150Ø M.S FIRE HYDRANT RISER
(B)	80Ø M.S DRAIN PIPE
(C)	150Ø M.S SPRINKLER RISER
(Ca)	150Ø M.S SPRINKLER RISER
FHC	FIRE HOSE CABINET

[illegible]