


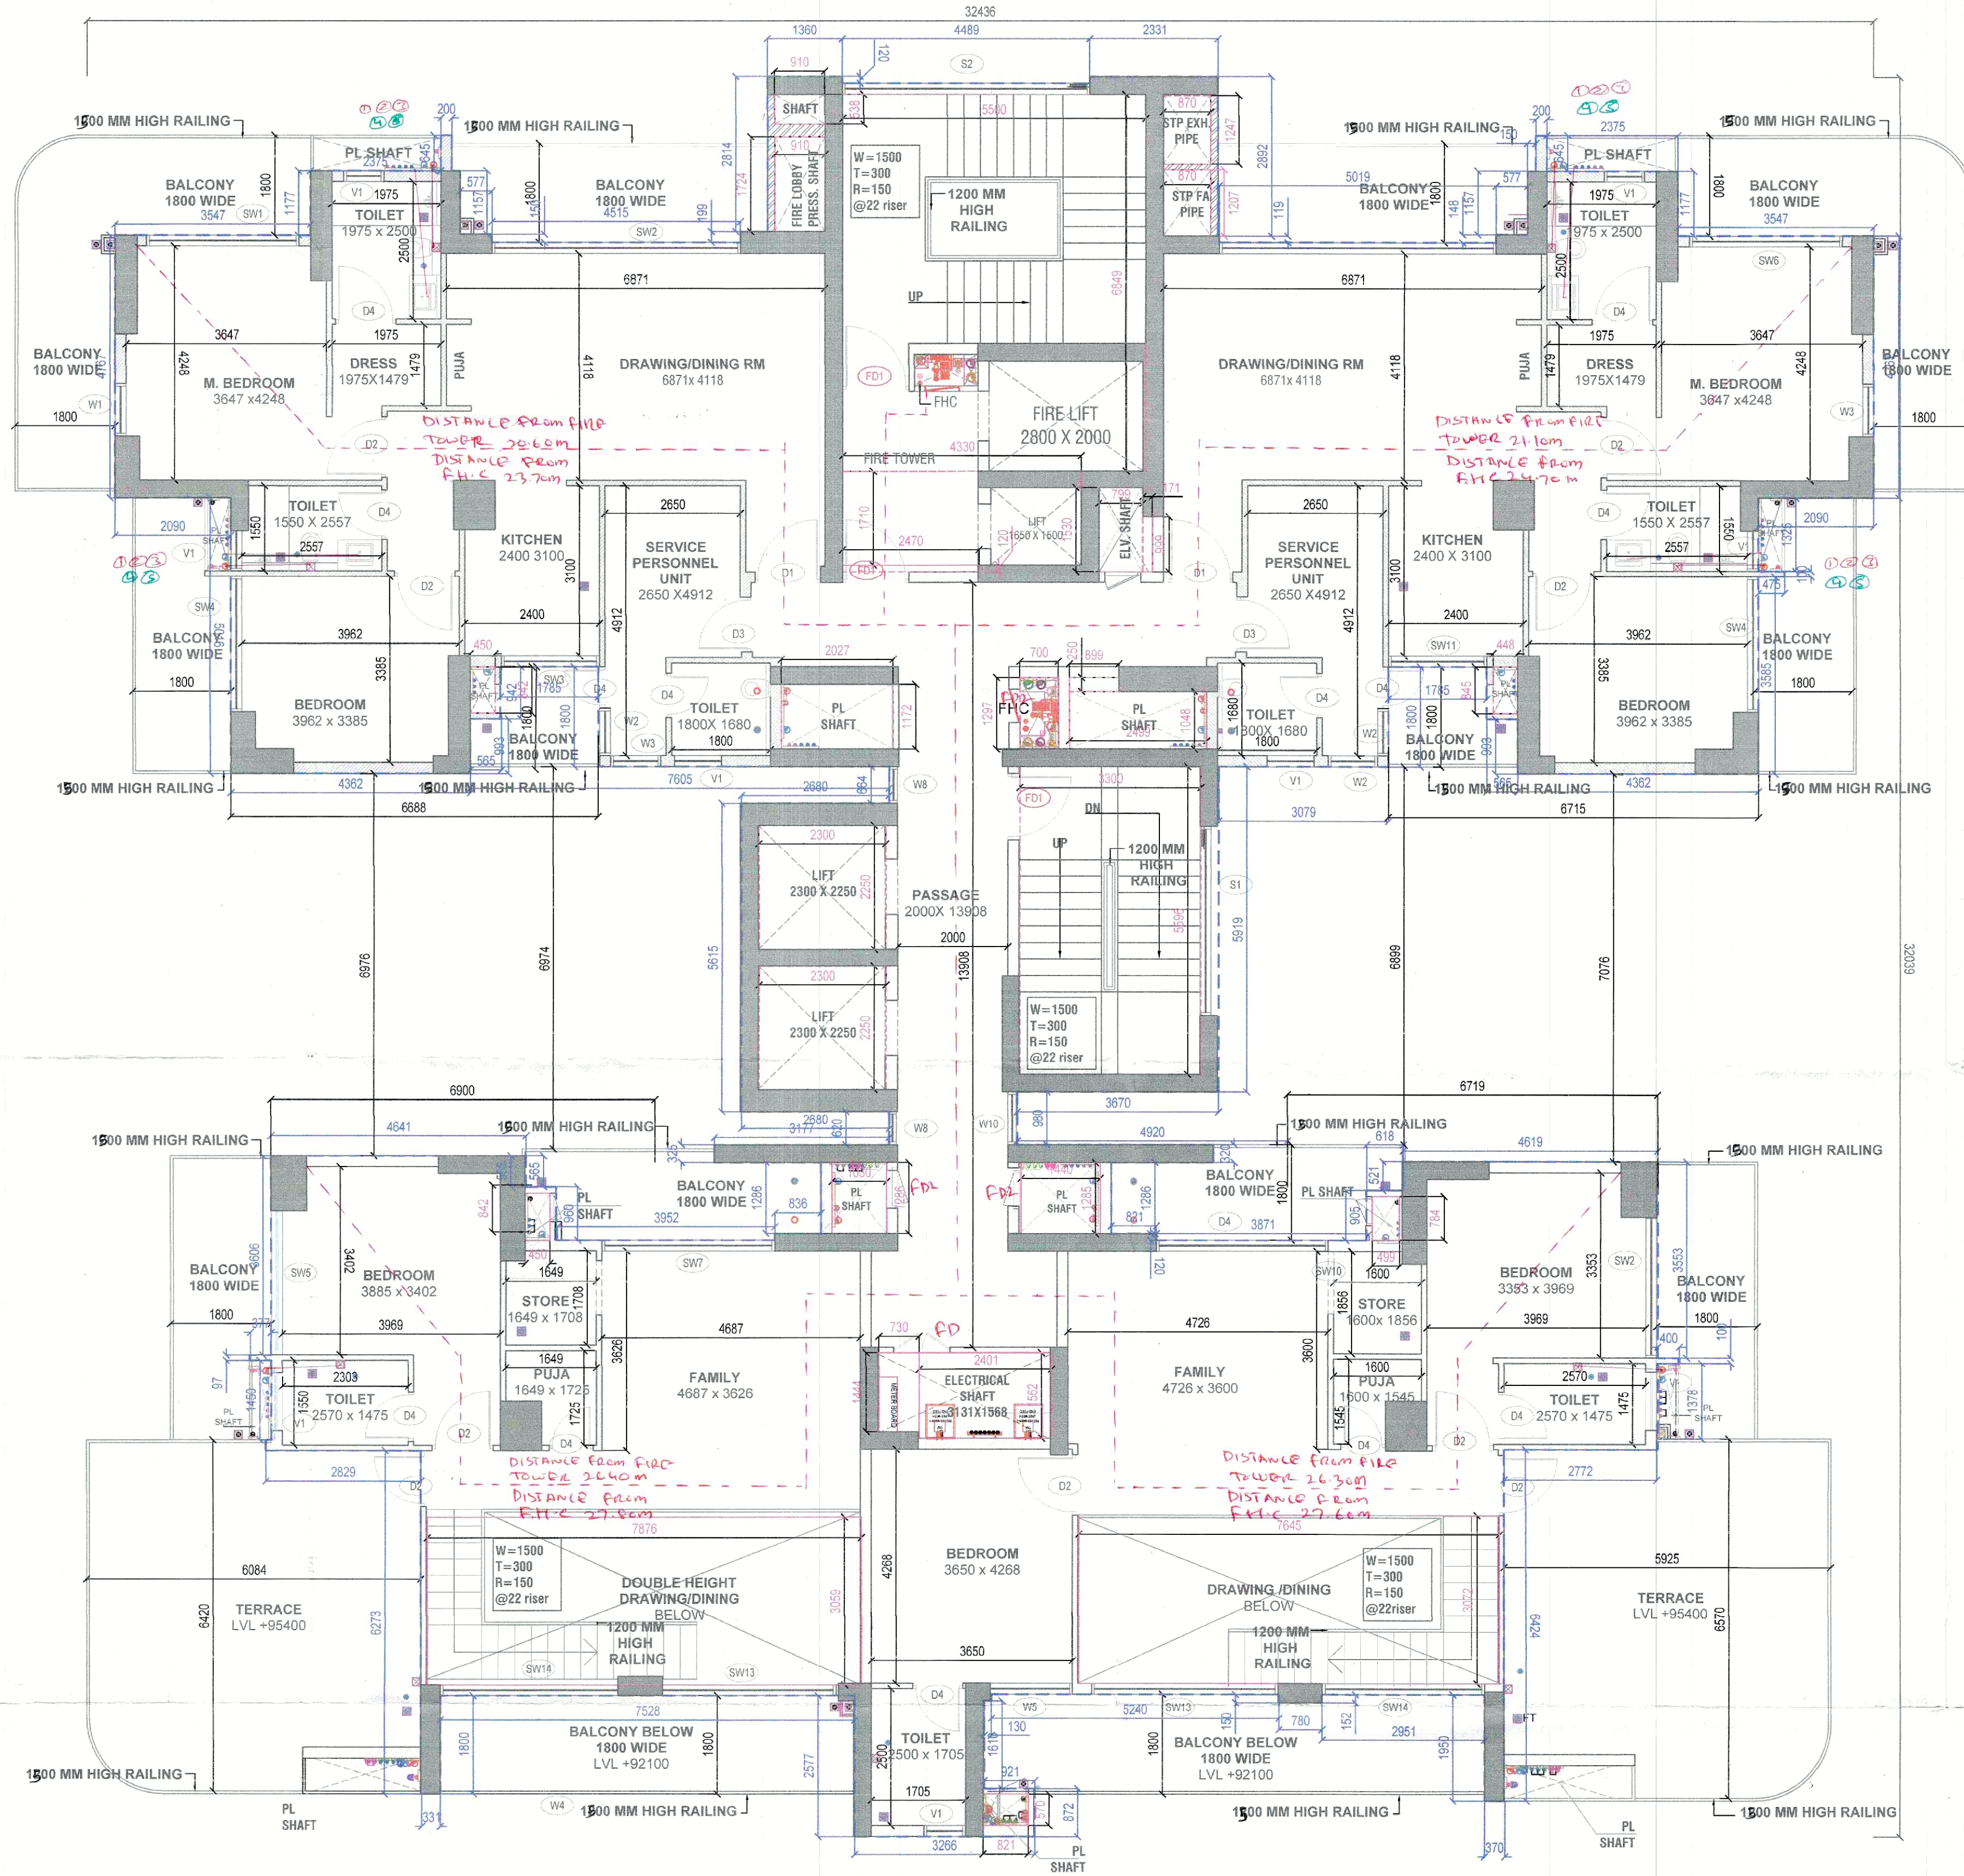

S.T.P. (HQ) S.T.P. (G) C.T.A. (H)
Member Secretary Member Chairman
B.P.A.C. B.P.A.C. B.P.A.C.

SANCTIONED
TO BE READ WITH THIS OFFICE
MEMO NO.:
DATED:

TYP. DOOR WINDOW SCHEDULE				
TYPE	WIDTH	CILL	UNTEL	HEIGHT
D-01	1200	-	2700	2700
D-02	900	-	2700	2700
D-03	1100	-	2700	2700
D-04	800	-	2700	2700
DW-01	1480	0/900	2700	2700
DW-02	1785	0/900	2700	2700
DW-03	1440	0/900	2700	2700
FD-01	1200	-	2700	2700
GL-01	2450	-	2700	2700
GL-02	650	-	2700	2700
GL-03	1120	-	2700	2700
SW-01	2764	-	2700	2700
SW-02	4515	-	2700	2700
SW-03	1785	-	2700	2700
SW-04	2465	-	2700	2700
SW-05	2604	-	2700	2700
SW-06	2738	-	2700	2700
SW-07	3195	-	2700	2700
SW-08	3395	-	2700	2700
SW-09	1535	-	2700	2700
SW-10	1482	-	2700	2700
SW-11	1785	-	2700	2700
SW-12	5020	-	2700	2700
SW-13	3230	-	2700	2700
SW-14	3156	-	2700	2700
V-01	750	1500	2700	1200
W-01	953	900	2700	1800
W-02	862	900	2700	1800
W-03	900	900	2700	1800
W-04	2531	900	2700	1800
W-05	1495	900	2700	1800
W-06	2451	900	2700	1800
W-07	1231	900	2700	1800
W-08	741	900	2700	1800
W-09	620	900	2700	1800
W-10	979	900	2700	1800
S-01	3435	1800	2700	900
S-02	4340	300	2250	1950
S-03	2950	1200	2250	1050

FIRE FIGHTING LEGEND	
SYMBOL	DESCRIPTION
(A)	150mm MS. SPRINKLER RISER PIPE (LOW ZONE)
(B)	150mm MS. SPRINKLER RISER PIPE (MIDDLE ZONE)
(C)	150mm MS. SPRINKLER RISER PIPE (HIGH ZONE)
(D)	150mm MS. FIRE HYDRANT RISER PIPE (LOW ZONE)
(E)	150mm MS. FIRE HYDRANT RISER PIPE (MIDDLE ZONE)
(F)	150mm MS. FIRE HYDRANT RISER PIPE (HIGH ZONE)
(G)	80mm DRAIN PIPE

LEGEND:-		
S.NO.	DESCRIPTION	SYMBOL
1.	1000 SOIL PIPE	(1)
2.	1000 WASTE PIPE	(2)
3.	750 ANTI-SIPHONAGE PIPE	(3)
4.	DOMESTIC WATER SUPPLY DN. TAKE PIPE	(4)
5.	FLUSHING WATER SUPPLY DN. TAKE PIPE	(5)
6.	750 BALCONY WASTE WATER PIPE	(6)
7.	1500 RAIN WATER PIPE	(7)
8.	DOMESTIC WATER DN. TAKE BOOSTER SUPPLY	(8)
9.	DOMESTIC WATER RISER PIPE	(9)
10.	FLUSHING WATER RISER PIPE	(10)
11.	FLOOR TRAP	FT
12.	FLOOR DRAIN	FD
13.	VERTICAL GRATING	VG
14.	PLAIN FLOOR TRAP	PFT
15.	FLOW DIRECTION	→
16.	BOTTLE TRAP	BT

NOTES:-

- BUILDING HAS AN AUTOMATIC SYSTEM WHEREVER REQUIRED BY NBC.
- BUILDING WILL BE DESIGNED (STRUCTURE) AS PER THE RELEVANT IS CODES FOR EARTHQUAKE RESISTANCE.
- WC SHALL BE MECHANICALLY LIGHT & VENTILATED WHEREVER REQUIRED.
- ALL DIMENSIONS ARE IN MILLIMETRES UNLESS SPECIFIED OTHERWISE.
- CENTRALLY AIR CONDITIONED BUILDING WITH MECHANICAL VENTILATION, WITH 24/7 POWER BACKUP SUPPLY.

DRAWING TITLE :

28TH FLOOR PLAN
(TOWER DETAIL TYPICAL)
BUILDING NAME:
TOWER - 1

ARCHITECT SIGNATURE:-



OWNER SIGNATURE:-

Fantasy Exim Pvt. Ltd.
Auth. Signatory

PROPOSED BUILDING PLANS OF RETIREMENT GROUP HOUSING (UNDER RETIREMENT HOUSING POLICY DATED 17.08.2021) OVER AN AREA MEASURING 3.825 ACRES (LICENSE NO 116 OF 2025 DATED 04.07.2025) IN SECTOR-36, SOHNA BEING DEVELOPED BY CHANDU CONSTRUCTION INDIA PVT. LTD. IN COLLABORATION WITH FANTASY EXIM PVT. LTD.

DATE:-
SCALE:- NTS
SHEET NO. T-104