


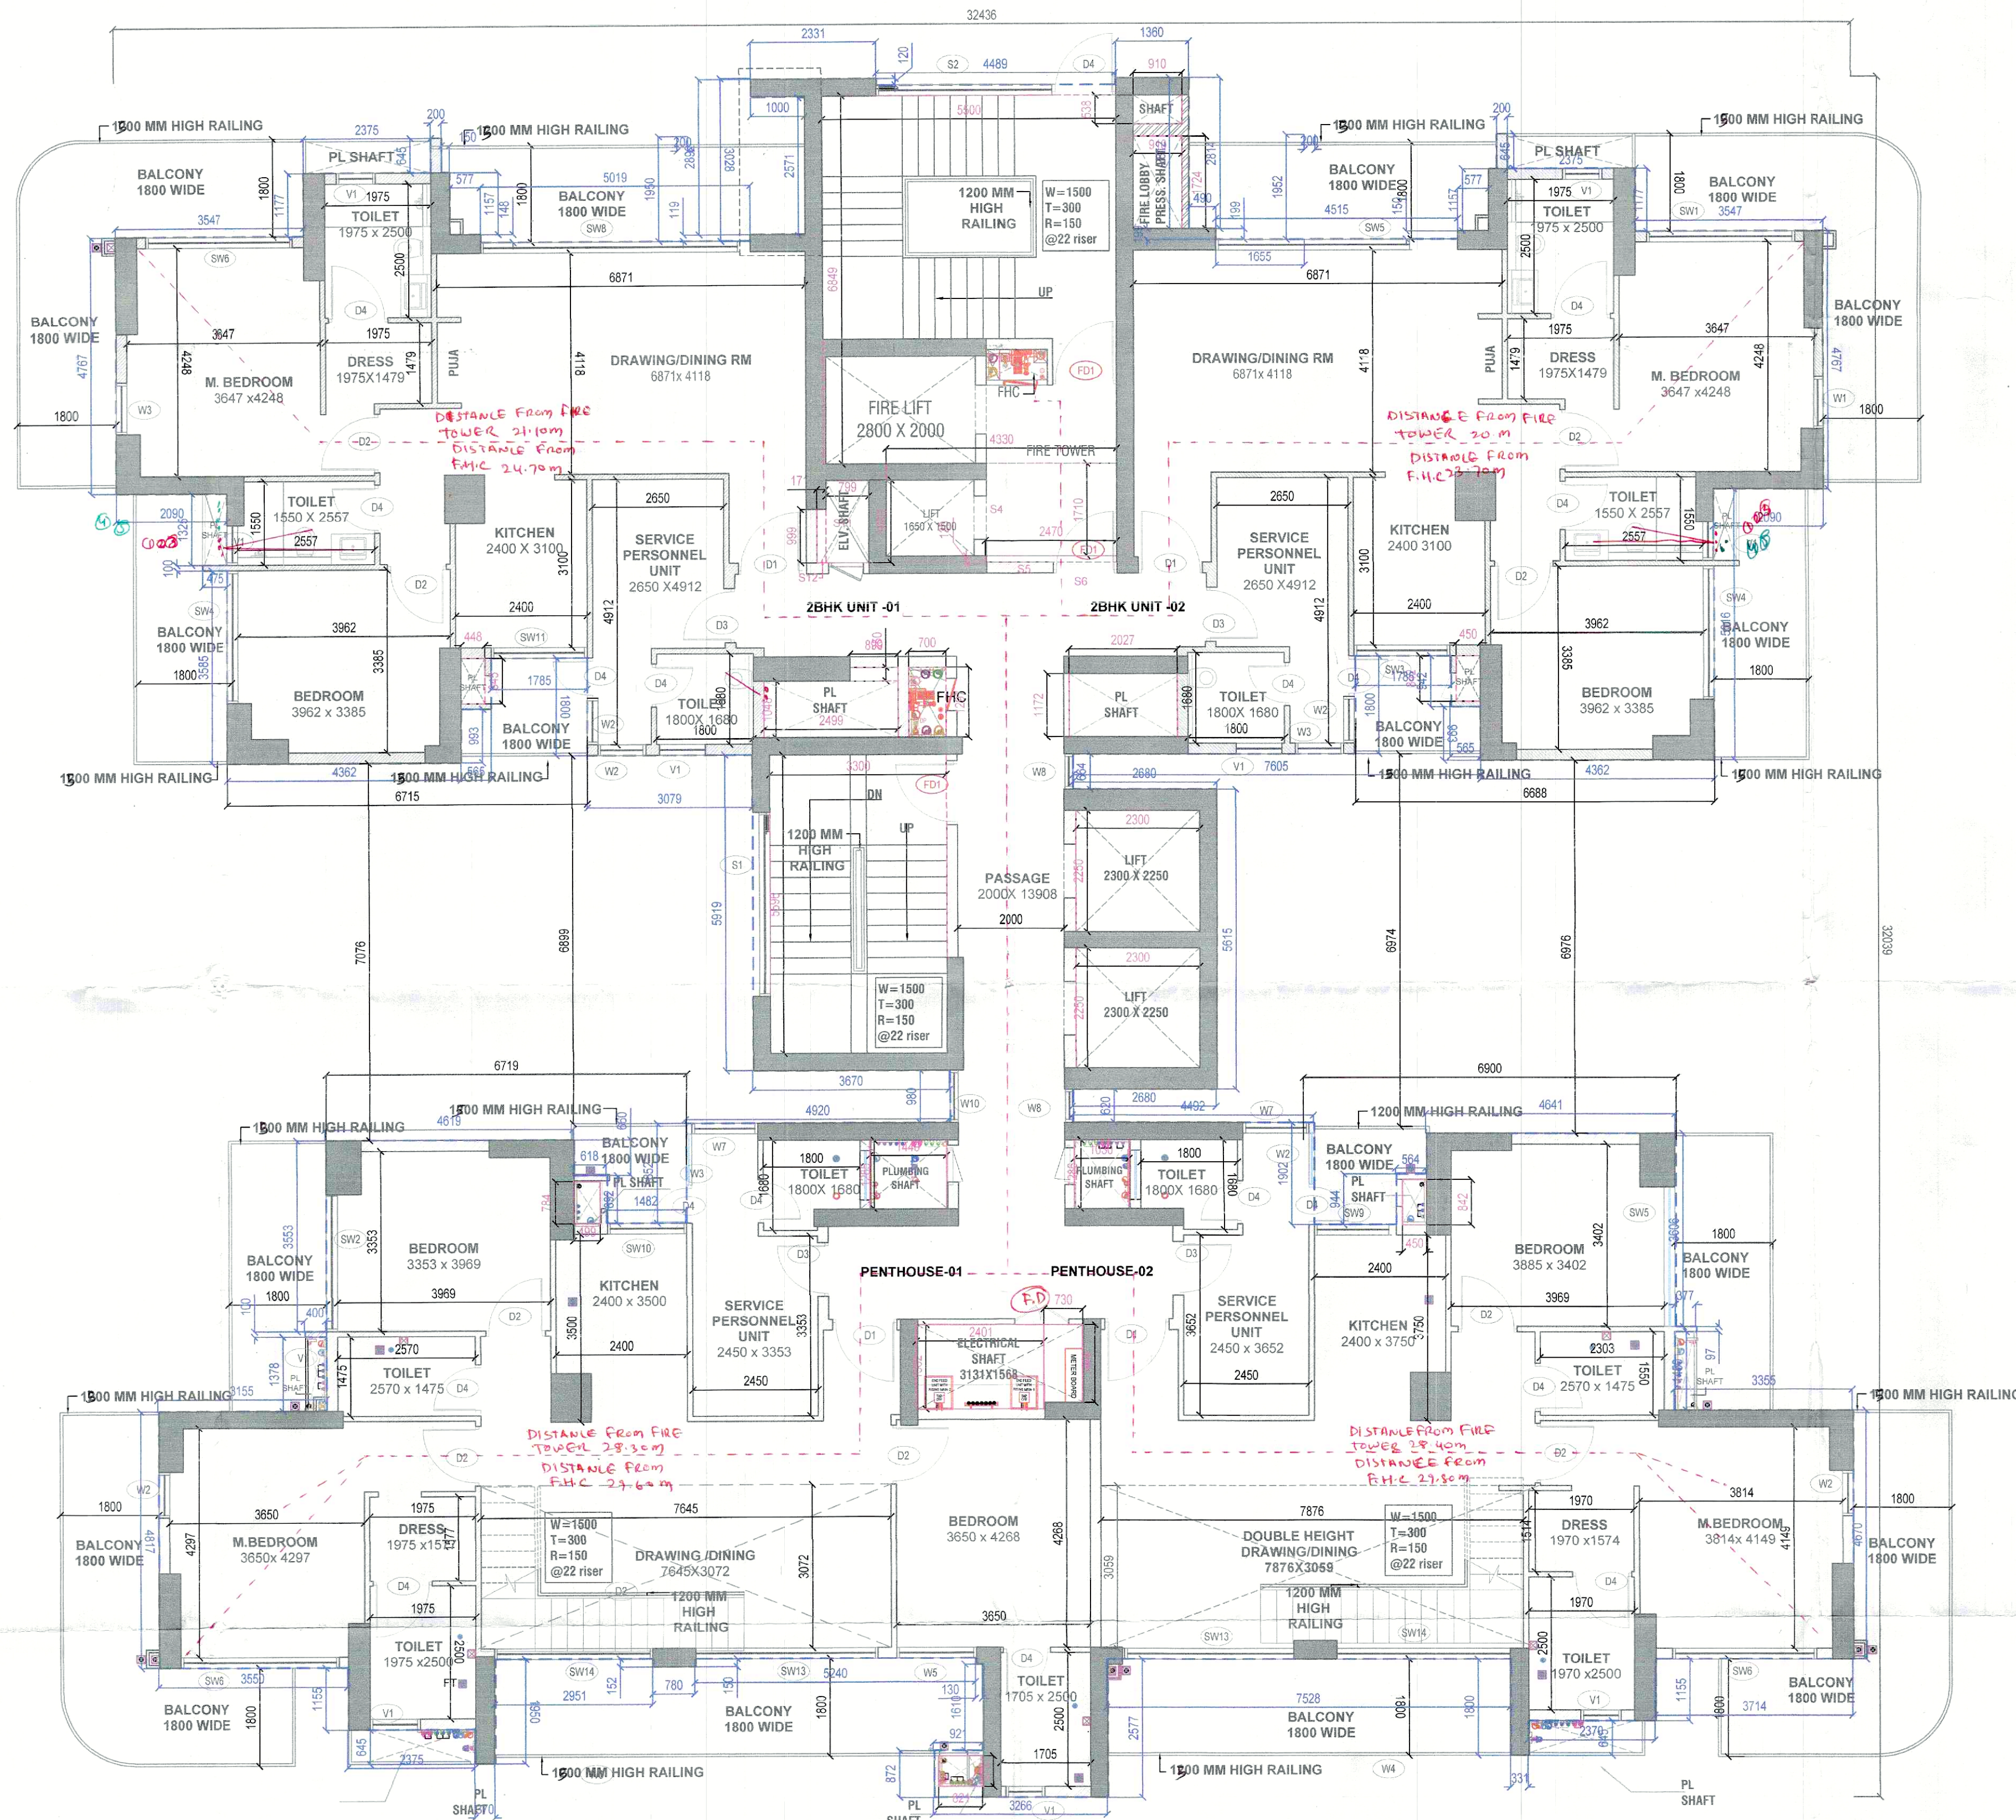

TO BE READ WITH THIS OFFICE
MEMO NO.:
DATED:

Sanctioned
MEMO NO.:
DATED:

TYPE	WIDTH	CILL	LINTEL	HEIGHT	REMARKS
D-01	1200	-	2700	2700	MAIN DOOR
D-02	900	-	2700	2700	TOILET
D-03	1100	-	2700	2700	POWDER TOILET
D-04	800	-	2700	2700	TOILET
DW-01	1480	0/900	2700	2700	KITCHEN
DW-02	1785	0/900	2700	2700	KITCHEN
DW-03	1440	0/900	2700	2700	KITCHEN
FD-01	1200	-	2700	2700	FIRE DOOR
GL-01	2450	-	2700	2700	BEDROOM/STUDY
GL-02	650	-	2700	2700	GLAZING
GL-03	1170	-	2700	2700	BEDROOM
SW-01	2764	-	2700	2700	DRAWING RM
SW-02	4515	-	2700	2700	BEDROOM
SW-03	1785	-	2700	2700	BEDROOM
SW-04	2465	-	2700	2700	BEDROOM
SW-05	2604	-	2700	2700	BEDROOM
SW-06	2738	-	2700	2700	BEDROOM
SW-07	3195	-	2700	2700	DRAWING RM
SW-08	3395	-	2700	2700	BEDROOM
SW-09	1535	-	2700	2700	STUDY ROOM
SW-10	1482	-	2700	2700	BEDROOM
SW-11	1785	-	2700	2700	KITCHEN
SW-12	3020	-	2700	2700	DRAWING RM
SW-13	3130	-	2700	2700	DRAWING RM
SW-14	3156	-	2700	2700	DRAWING RM
V-01	750	1500	2700	1200	TOILET VENT
W-01	953	900	2700	1800	BEDROOM
W-02	862	900	2700	1800	BEDROOM
W-03	900	900	2700	1800	BEDROOM
W-04	2531	900	2700	1800	BEDROOM
W-05	1495	900	2700	1800	BEDROOM
W-06	2451	900	2700	1800	BEDROOM
W-07	1231	900	2700	1800	BEDROOM
W-08	741	900	2700	1800	BEDROOM
W-09	620	900	2700	1800	BEDROOM
W-10	379	900	2700	1800	BEDROOM
S-01	3435	1800	2700	900	STAIRCASE
S-02	4340	300	2250	1950	STAIRCASE
S-03	2950	1200	2250	1050	STAIRCASE

S.NO.	DESCRIPTION	SYMBOL
1.	1000 SOIL PIPE	①
2.	1000 WASTE PIPE	②
3.	750 ANTI-SIPHONAGE PIPE	③
4.	DOMESTIC WATER SUPPLY DN. TAKE PIPE	④
5.	FLUSHING WATER SUPPLY DN. TAKE PIPE	⑤
6.	750 BALCONY WASTE WATER PIPE	⑥
7.	1500 RAIN WATER PIPE	⑦
8.	DOMESTIC WATER DN. TAKE BOOSTER SUPPLY	⑧
9.	DOMESTIC WATER RISER PIPE	⑨
10.	FLUSHING WATER RISER PIPE	⑩
11.	FLOOR TRAP	FT
12.	FLOOR DRAIN	FD
13.	VERTICAL GRATING	VG
14.	PLAIN FLOOR TRAP	PFT
15.	FLOW DIRECTION	→
16.	BOTTLE TRAP	⊙

SYMBOL	DESCRIPTION
(A)	150mm MS. SPRINKLER RISER PIPE (LOW ZONE)
(B)	150mm MS. SPRINKLER RISER PIPE (MIDDLE ZONE)
(C)	150mm MS. SPRINKLER RISER PIPE (HIGH ZONE)
(D)	150mm MS. FIRE HYDRANT RISER PIPE (LOW ZONE)
(E)	150mm MS. FIRE HYDRANT RISER PIPE (MIDDLE ZONE)
(F)	150mm MS. FIRE HYDRANT RISER PIPE (HIGH ZONE)
(G)	80mm DRAIN PIPE (Internal) Service only subject to comments in forwarding letter No. 366/135 24/1/2025

NOTES:-

- BUILDING HAS AN AUTOMATIC SYSTEM WHEREVER REQUIRED BY NBC.
- BUILDING WILL BE DESIGNED (STRUCTURE) AS PER THE RELEVANT IS CODES FOR EARTHQUAKE RESISTANCE.
- WC SHALL BE MECHANICALLY LIGHT & VENTILATED WHEREVER REQUIRED.
- ALL DIMENSIONS ARE IN MILLIMETRES UNLESS SPECIFIED OTHERWISE.
- CENTRALLY AIR CONDITIONED BUILDING WITH MECHANICAL VENTILATION, WITH 24/7 POWER BACKUP SUPPLY.

DRAWING TITLE :

28TH FLOOR PLAN

BUILDING NAME:

TOWER - 2

ARCHITECT SIGNATURE:-

ARVIKAS KUMAR RANA
24/2010/48851


OWNER SIGNATURE:-

Fantasy Exim Pvt. Ltd.
Auth. Signatory

PROPOSED BUILDING PLANS OF RETIREMENT GROUP HOUSING (UNDER RETIREMENT HOUSING POLICY DATED 17.08.2021) OVER AN AREA MEASURING 3.825 ACRES (LICENSE NO. 118 OF 2025 DATED 04.07.2025) IN SECTOR-36, SOHNA BEING DEVELOPED BY JANDU CONSTRUCTION INDIA PVT. LTD. IN COLLABORATION WITH FANTASY EXIM PVT. LTD.

DATE:-

SCALE:- NTS

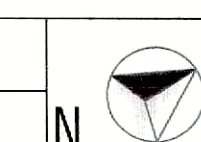

SHEET NO.

T-203