


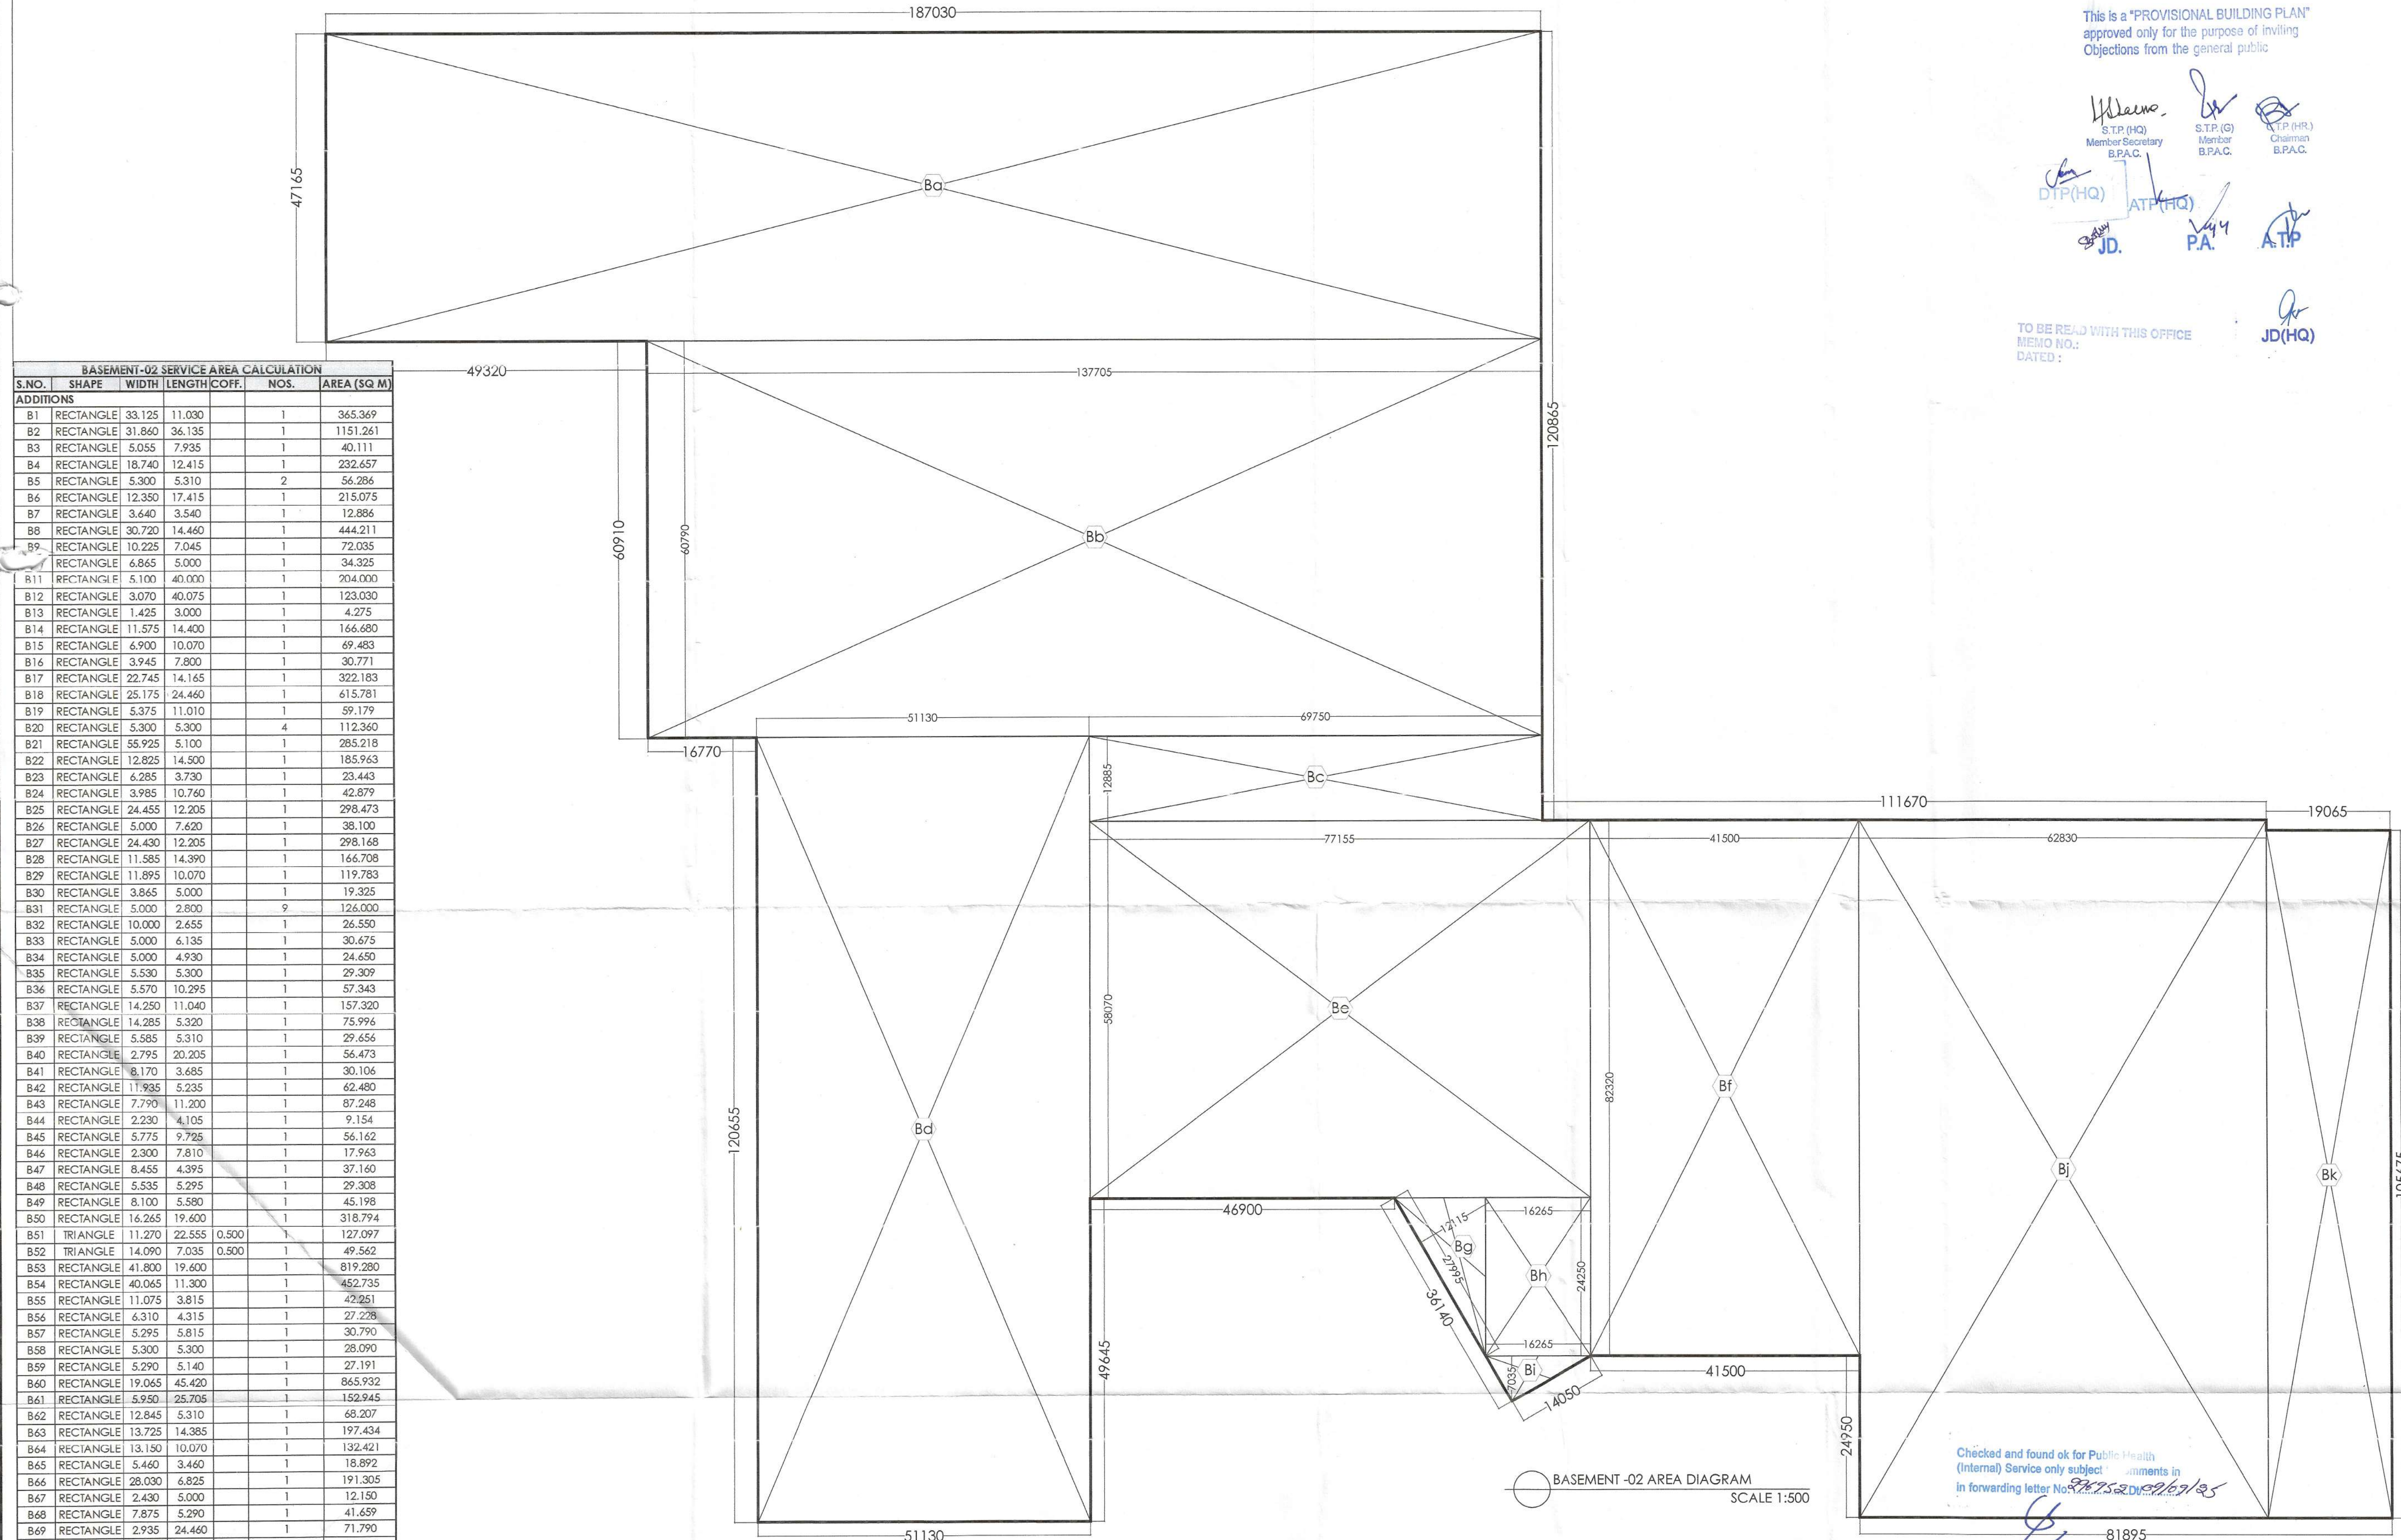

BASEMENT-02 SERVICE AREA CALCULATION						
S.NO.	SHAPE	WIDTH	LENGTH	COFF.	NOS.	AREA (SQ. M)
ADDITIONS						
B1	RECTANGLE	33.125	11.030		1	365.369
B2	RECTANGLE	31.860	36.135		1	1151.261
B3	RECTANGLE	5.055	7.935		1	40.111
B4	RECTANGLE	18.740	12.415		1	232.657
B5	RECTANGLE	5.300	5.310		2	56.286
B6	RECTANGLE	12.350	17.415		1	215.075
B7	RECTANGLE	3.640	3.540		1	12.886
B8	RECTANGLE	30.720	14.460		1	444.211
B9	RECTANGLE	10.225	7.045		1	72.035
	RECTANGLE	6.865	5.000		1	34.325
B11	RECTANGLE	5.100	40.000		1	204.000
B12	RECTANGLE	3.070	40.075		1	123.030
B13	RECTANGLE	1.425	3.000		1	4.275
B14	RECTANGLE	11.575	14.400		1	166.680
B15	RECTANGLE	6.900	10.070		1	69.483
B16	RECTANGLE	3.945	7.800		1	30.771
B17	RECTANGLE	22.745	14.165		1	322.183
B18	RECTANGLE	25.175	24.460		1	615.781
B19	RECTANGLE	5.375	11.010		1	59.179
B20	RECTANGLE	5.300	5.300		4	112.360
B21	RECTANGLE	55.925	5.100		1	285.218
B22	RECTANGLE	12.825	14.500		1	185.963
B23	RECTANGLE	6.285	3.730		1	23.443
B24	RECTANGLE	3.985	10.760		1	42.879
B25	RECTANGLE	24.455	12.205		1	298.473
B26	RECTANGLE	5.000	7.620		1	38.100
B27	RECTANGLE	24.430	12.205		1	298.168
B28	RECTANGLE	11.585	14.390		1	166.708
B29	RECTANGLE	11.895	10.070		1	119.783
B30	RECTANGLE	3.865	5.000		1	19.325
B31	RECTANGLE	5.000	2.800		9	126.000
B32	RECTANGLE	10.000	2.655		1	26.550
B33	RECTANGLE	5.000	6.135		1	30.675
B34	RECTANGLE	5.000	4.930		1	24.650
B35	RECTANGLE	5.530	5.300		1	29.309
B36	RECTANGLE	5.570	10.295		1	57.343
B37	RECTANGLE	14.250	11.040		1	157.320
B38	RECTANGLE	14.285	5.320		1	75.996
B39	RECTANGLE	5.585	5.310		1	29.656
B40	RECTANGLE	2.795	20.205		1	56.473
B41	RECTANGLE	8.170	3.685		1	30.106
B42	RECTANGLE	11.935	5.235		1	62.480
B43	RECTANGLE	7.790	11.200		1	87.248
B44	RECTANGLE	2.230	4.105		1	9.154
B45	RECTANGLE	5.775	9.725		1	56.162
B46	RECTANGLE	2.300	7.810		1	17.963
B47	RECTANGLE	8.455	4.395		1	37.160
B48	RECTANGLE	5.535	5.295		1	29.308
B49	RECTANGLE	8.100	5.580		1	45.198
B50	RECTANGLE	16.265	19.600		1	318.794
B51	TRIANGLE	11.270	22.555	0.500	1	127.097
B52	TRIANGLE	14.090	7.035	0.500	1	49.562
B53	RECTANGLE	41.800	19.600		1	819.280
B54	RECTANGLE	40.065	11.300		1	452.735
B55	RECTANGLE	11.075	3.815		1	42.251
B56	RECTANGLE	6.310	4.315		1	27.228
B57	RECTANGLE	5.295	5.815		1	30.790
B58	RECTANGLE	5.300	5.300		1	28.090
B59	RECTANGLE	5.290	5.140		1	27.191
B60	RECTANGLE	19.065	45.420		1	865.932
B61	RECTANGLE	5.950	25.705		1	152.945
B62	RECTANGLE	12.845	5.310		1	68.207
B63	RECTANGLE	13.725	14.385		1	197.434
B64	RECTANGLE	13.150	10.070		1	132.421
B65	RECTANGLE	5.460	3.460		1	18.892
B66	RECTANGLE	28.030	6.825		1	191.305
B67	RECTANGLE	2.430	5.000		1	12.150
B68	RECTANGLE	7.875	5.290		1	41.659
B69	RECTANGLE	2.935	24.460		1	71.790
B70	RECTANGLE	9.995	2.540		1	25.387
B71	RECTANGLE	5.000	8.365		1	41.825
B72	RECTANGLE	4.995	6.245		1	31.194
B73	RECTANGLE	5.005	7.795		1	39.014
B74	RECTANGLE	7.000	2.800		1	19.600
B75	RECTANGLE	7.455	5.080		1	37.871
B76	RECTANGLE	9.285	3.485		1	32.358
B77	RECTANGLE	5.000	2.540		1	12.700
B78	RECTANGLE	5.000	3.340		1	16.700
B79	RECTANGLE	18.355	12.950		1	237.697
B80	RECTANGLE	19.420	34.530		1	670.573
B81	RECTANGLE	19.540	26.370		1	515.270
B82	RECTANGLE	15.155	14.435		1	218.762
B83	RECTANGLE	33.890	14.435		1	489.202
B84	RECTANGLE	14.520	14.435		1	209.596
B85	RECTANGLE	5.410	3.175		1	17.177
B86	RECTANGLE	4.750	5.000		1	23.750
B87	RECTANGLE	10.040	5.885		1	59.085
TOTAL BASEMENT-02 SERVICE AREA						13172.282

BASEMENT-02 AREA DIAGRAM						
S.NO.	SHAPE	WIDTH	LENGTH	COFF.	NOS.	AREA (SQ. M)
ADDITIONS						
Ba	RECTANGLE	187.030	47.165		1	8821.270
Bb	RECTANGLE	137.705	60.790		1	8371.087
Bc	RECTANGLE	69.750	12.885		1	898.729
Bd	RECTANGLE	51.130	120.655		1	6169.090
Be	RECTANGLE	77.155	58.070		1	4480.391
Bf	RECTANGLE	41.500	82.320		1	3416.280
Bg	TRIANGLE	12.115	27.995	0.500	1	169.580
Bh	RECTANGLE	16.265	24.250		1	394.426
Bi	TRIANGLE	16.265	7.035	0.500	1	57.212
Bj	RECTANGLE	62.830	105.675		1	6639.560
Bk	RECTANGLE	19.065	105.675		1	2014.694
TOTAL BASEMENT-02 AREA						41432.319

This is a "PROVISIONAL BUILDING PLAN"
approved only for the purpose of inviting
Objections from the general public

[Signatures]
S.T.P. (HQ) Member Secretary B.P.A.C.
S.T.P. (G) Member B.P.A.C.
A.T.P. (HR.) Chairman B.P.A.C.
D.T.P. (HQ) *[Signature]*
A.T.P. (HQ) *[Signature]*
JD. *[Signature]*
P.A. *[Signature]*
A.T.P. *[Signature]*
JD(HQ) *[Signature]*

TO BE READ WITH THIS OFFICE
MEMO NO.:
DATED:

KEY PLAN

NOTES

HVAC LEGEND

- SUPPLY AIR (FRESH) CUTOUT
- EXHAUST AIR CUTOUT
- BR BLOWER ROOM

LEGEND

- SITE BOUNDARY AS/ZONING
- 6M SETBACK LINE AS/ZONING
- LINE OF BASEMENT

PARKING LEGEND

- SINGLE CAR PARKING
- VISITORS CAR PARKING

CLIENT
Birla Estates Pvt. Ltd. in collaboration with Barmalt India Pvt. Ltd.

STRUCTURES
WHITBY WOOD PRITAMDASANI, MUMBAI
Unit 1101 | Lodha Supremus | Powai, Andheri (East) | Mumbai-400072 | Maharashtra | India
T: +91-9820-186879
m.pritamdasani@whitbywood.com

MEP
SNC. SUNIL NAYYAR CONSULTING ENGINEERS LLP
206-206A & 305A-305B, 2nd & 3rd Floor
Sector 54 | Gurgaon-122002 | Haryana | India
T: +91-124-4803800
Email: sncgurgaon@snc.co.in

LANDSCAPE
SWA | LANDSCAPE BEACH
570 | Glenneire Street | Laguna Beach | California-92651 | USA
T: +1.949.497.5471 | D: +1.949.607.0174 | www.swagroup.com

ARCHITECTS
Arcop Associates Pvt. Ltd.
Plot- 38B, Sec-32, Gurgaon-122001
Ph: 24842050, 24842169
Montreal, Toronto, New-Delhi, Boston

PROJECT
REVISED BUILDING PLAN OF GROUP HOUSING COLONY LICENCE NO 116 of 2011 AREA MEASURING 13.275 ACRES IN SECTOR-31 - 32A, GURGAON BEING DEVELOPED BY BIRLA ESTATES PVT LTD IN COLLABORATION WITH BARMALT INDIA PVT. LTD.

ARCHITECT'S SIGNATURE
[Signature]
SUNIL NAYYAR
REGISTERED ARCHITECT
Registration No. CA2007/03302

OWNER'S SIGNATURE
For BIRLA ESTATES PVT. LTD.
[Signature]
Anand

DRAWING AUTHORIZED SIGNATURE
[Signature]
SUNIL NAYYAR

DRAWING NO.
BASEMENT-02
AREA DIAGRAM
AR-BP-105