



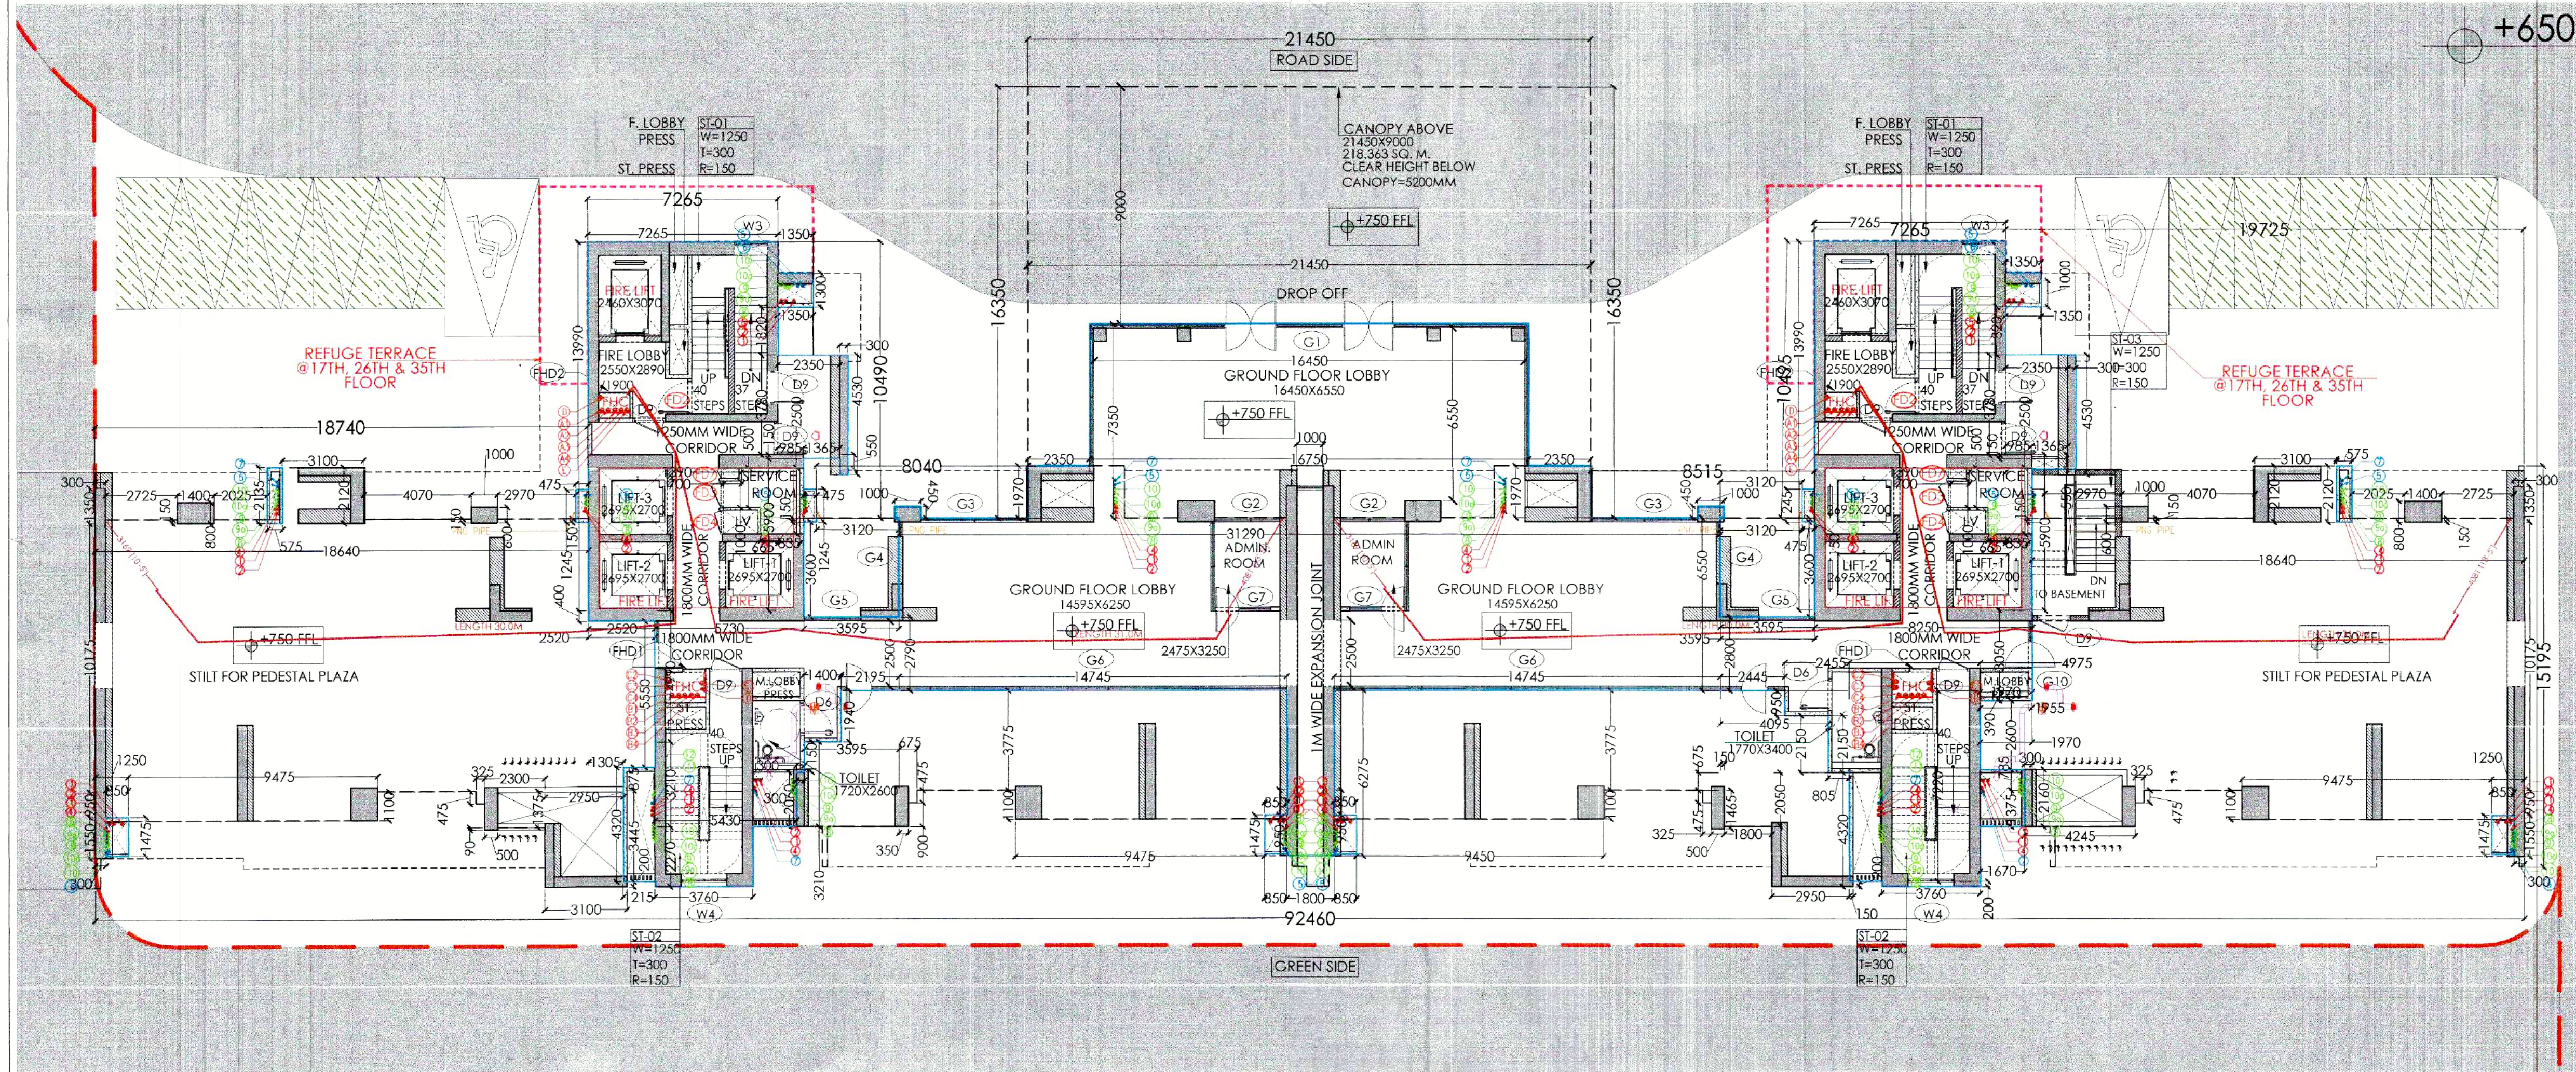

(01) STILT/GROUND FLOOR PLAN (TOWER T5 & T6)
SCALE - 1:150

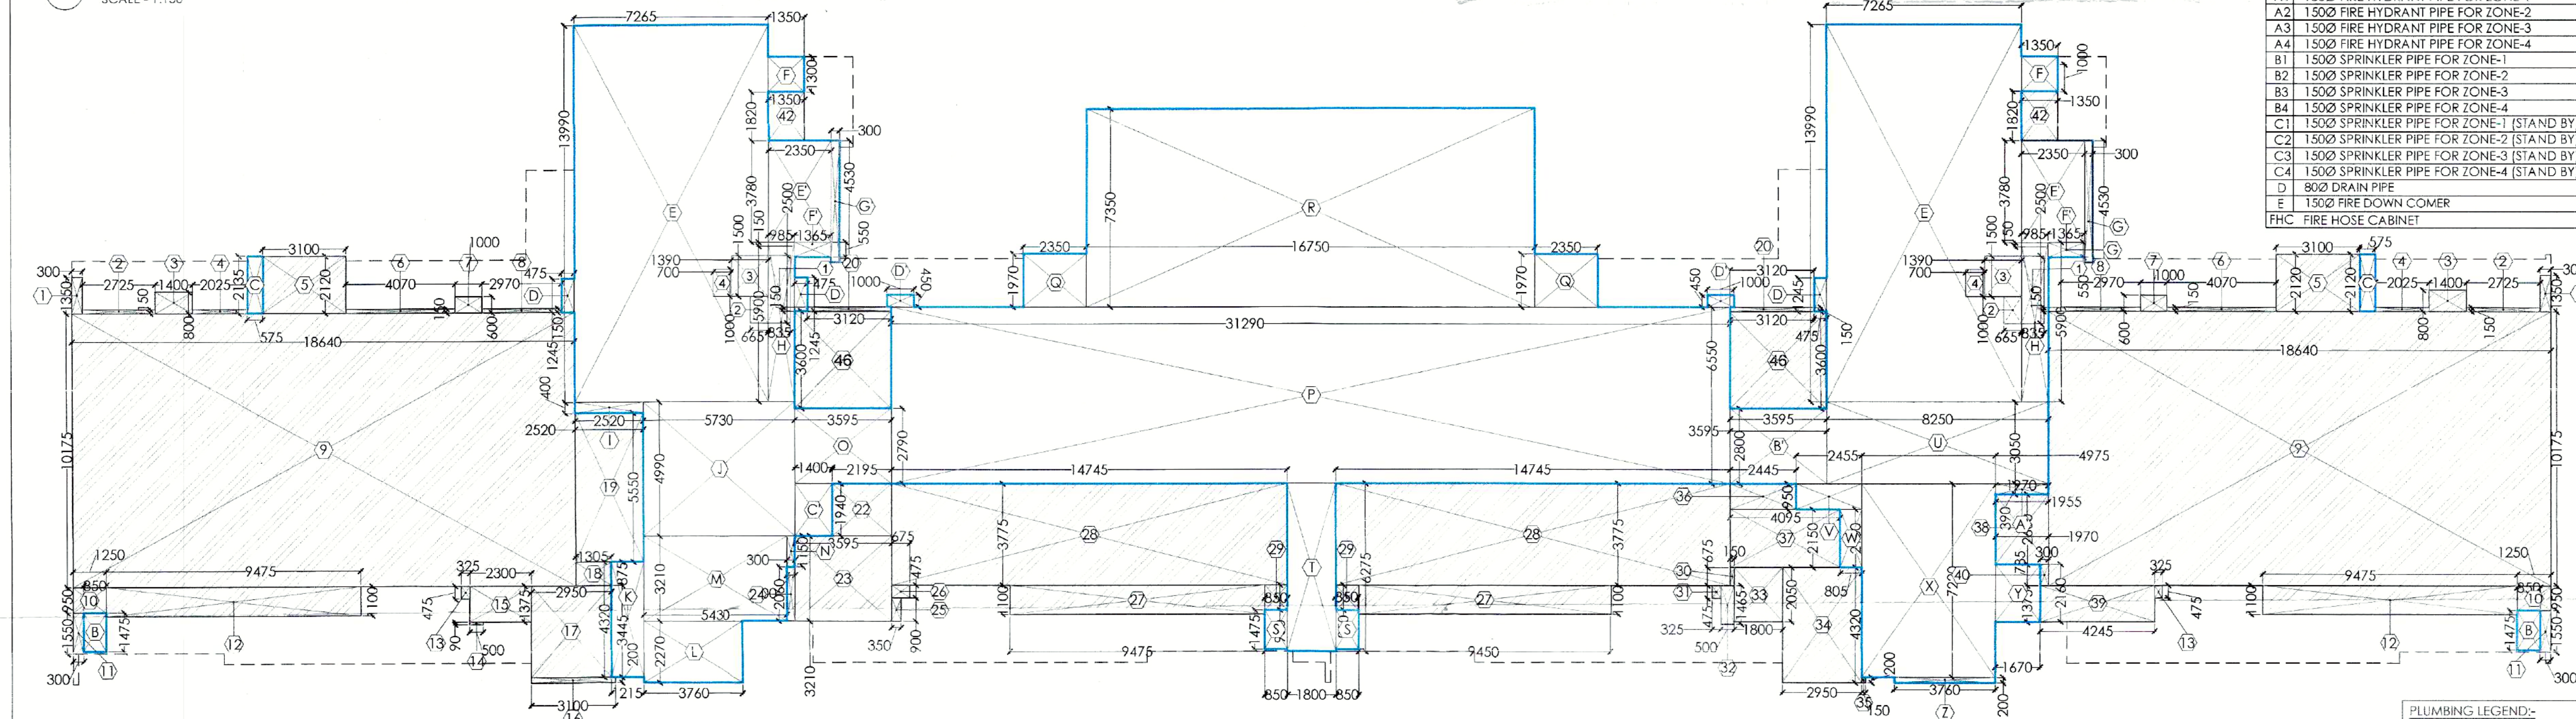

(02) STILT/GROUND FLOOR F.A.R. AREA DIAGRAM (TOWER T5 & T6)
SCALE - 1:150

NOTES :-

- VRF System is being provided.
- Full DG power back up is being provided.
- Toilets are mechanical ventilated.
- All lifts shall have 100% power back-up.
- All electrical installations shall be as per provision of nbc.
- Fire-fighting/safety provisions shall be as per relevant nbc provisions.
- Basement area shall have mechanically ventilated as per relevant code.
- All toilets are ventilated as per haryana building code 2017.
- Building has automatic sprinkler system wherever required by nbc.
- Building will be designed (structures) as per relevant i.s. codes for earthquake resistance.
- Solar panels of required capacity shall be provided on roof top as per hareda/zoning norms.
- All handicap ramps with railing.
- All fire fighting installations shall be as per provision of nbc.
- The rainwater harvesting system shall be provided as per central ground water Authority norms.

PLUMBING LEGEND:-

1	1000/1100 SOIL PIPE
2	1000/1100 WASTE PIPE
3	1000/1100 WASHING MACHINE WASTE WATER PIPE
4	750 VENT PIPE
5	1000/1100 RAIN WATER PIPE FOR BALCONY
6	1000/1100 RAIN WATER PIPE FOR REFUGE TERRACE
7	1500/1600 RAIN WATER PIPE FOR TERRACE
8	DOMESTIC WATER SUPPLY (BOOSTER) (TOP SIX FLOORS)
9	DOMESTIC HIGH ZONE WATER SUPPLY (BY GRAVITY)
10	DOMESTIC WATER SUPPLY (BY GRAVITY) (EXPRESS DOWN)
11	FLOORING WATER SUPPLY (BY GRAVITY)
12	FLOORING WATER SUPPLY (BY GRAVITY) (EXPRESS DOWN)
13	DOMESTIC WATER SUPPLY RISER FOR C.H. TANK
14	FLOORING WATER SUPPLY RISER FOR C.H. TANK
15	750 HVAC DRAIN PIPE

NOTES:-

- REFER DRAWING NO. AR-T5T6-201, 202 & 203 FOR ELEVATIONS
- REFER DRAWING NO. AR-T5T6-301 FOR SECTIONS
- T5 IS SIMILAR TO T6

TOWER-T5 & T6 FLOOR LEVELS

FLOOR NO.	DU	LEVEL (MM)
STILT/GROUND FLOOR LEVEL	LOBBY	750
FIRST FLOOR LEVEL		6750
SECOND FLOOR LEVEL		10150
THIRD FLOOR LEVEL		13550
FOURTH FLOOR LEVEL		16950
FIFTH FLOOR LEVEL		20350
SIXTH FLOOR LEVEL		23750
SEVENTH FLOOR LEVEL		27150
EIGHTH FLOOR LEVEL		30550
NINTH FLOOR LEVEL		33950
TENTH FLOOR LEVEL		37350
ELEVENTH FLOOR LEVEL		40750
TWELFTH FLOOR LEVEL		44150
THIRTEENTH FLOOR LEVEL		47550
FOURTEENTH FLOOR LEVEL		50950
FIFTEENTH FLOOR LEVEL		54350
SIXTEENTH FLOOR LEVEL		57750
REFUGE-01 FLOOR LEVEL		61150

TOWER-T5 & T6 FLOOR LEVELS

FLOOR NO.	DU	LEVEL (MM)
EIGHTEENTH FLOOR LEVEL		64550
NINETEENTH FLOOR LEVEL		67950
TWENTIETH FLOOR LEVEL		71350
TWENTYFIRST FLOOR LEVEL		74750
TWENTYSECOND FLOOR LEVEL		78150
TWENTYTHIRD FLOOR LEVEL		81550
TWENTYFOURTH FLOOR LEVEL		84950
TWENTYFIFTH FLOOR LEVEL		88350
REFUGE-02 FLOOR LEVEL		91750
TWENTYSEVENTH FLOOR LEVEL		95150
TWENTYEIGHTH FLOOR LEVEL		98550
TWENTYNINTH FLOOR LEVEL		101950
THIRTIETH FLOOR LEVEL		105350
THIRTYFIRST FLOOR LEVEL		108750

TOWER-T5 & T6 FLOOR LEVELS

FLOOR NO.	DU	LEVEL (MM)
THIRTYSECOND FLOOR LEVEL		112150
THIRTYTHIRD FLOOR LEVEL		115550
THIRTYFOURTH FLOOR LEVEL		118950
REFUGE-03 FLOOR LEVEL		122350
THIRTYFIFTH FLOOR LEVEL		125750
THIRTYSEVENTH FLOOR LEVEL		129150
THIRTYEIGHTH FLOOR LEVEL		132550
TOTAL DWELLING UNITS OF T5	76	
TOTAL DWELLING UNITS OF T6	78	
TOTAL F.A.R. IN TOWER T5	21253.433	
TOTAL F.A.R. IN TOWER T6	21803.101	

STILT/GROUND FLOOR (F.A.R.) - TOWER T5 & T6

S.NO.	WIDTH(M)	LENGTH(M)	COEFF.	NOS.	AREA (SQM)
ADDITIONS					
B	0.850	1.475	2	2	2.508
C	0.575	2.135	2	2	2.455
D	0.475	1.245	3	3	1.774
E	7.245	13.990	2	2	203.275
F	1.350	1.300	2	2	3.510
G	1.465	0.650	1	1	0.952
H	0.985	5.900	2	2	11.623
I	2.320	0.400	1	1	1.008
J	3.730	4.990	1	1	28.393
K	1.215	4.330	1	1	5.247
L	3.760	2.270	1	1	8.535
M	5.430	3.210	1	1	17.430
N	0.300	1.150	1	1	0.345
O	3.995	2.790	1	1	10.030
P	31.290	6.550	1	1	204.945
Q	2.350	1.970	2	2	9.259
R	16.750	7.350	1	1	123.113
S	0.850	1.475	2	2	2.508
T	1.800	6.275	1	1	11.295
U	8.250	3.050	1	1	25.143
V	2.445	0.950	1	1	2.322
W	0.850	2.150	1	1	1.731
X	4.975	7.220	1	1	35.920
Y	1.670	2.140	1	1	3.607
Z	3.740	0.200	1	1	0.752
A	1.750	0.390	1	1	0.762
B	3.995	2.880	1	1	10.066
C	1.400	1.940	1	1	2.716
D	1.000	0.450	2	2	0.900
E	2.350	3.780	2	2	17.766
F	1.365	0.550	2	2	1.502
G	0.300	4.330	2	2	2.598
TOTAL ADDITIONS					754.225
SUBTRACTIONS					
1	0.835	2.500	2	2	8.330
2	0.665	1.000	2	2	2.660
3	1.390	1.500	2	2	8.340
4	0.700	1.000	2	2	2.800
TOTAL SUBTRACTIONS					22.130
TOTAL F.A.R.					732.075


SN FIRE FIGHTING PIPE LEGEND:-

A1	1500 FIRE HYDRANT PIPE FOR ZONE-1
A2	1500 FIRE HYDRANT PIPE FOR ZONE-2
A3	1500 FIRE HYDRANT PIPE FOR ZONE-3
A4	1500 FIRE HYDRANT PIPE FOR ZONE-4
B1	1500 SPRINKLER PIPE FOR ZONE-1
B2	1500 SPRINKLER PIPE FOR ZONE-2
B3	1500 SPRINKLER PIPE FOR ZONE-3
B4	1500 SPRINKLER PIPE FOR ZONE-4
C1	1500 SPRINKLER PIPE FOR ZONE-1 (STAND BY)
C2	1500 SPRINKLER PIPE FOR ZONE-2 (STAND BY)
C3	1500 SPRINKLER PIPE FOR ZONE-3 (STAND BY)
C4	1500 SPRINKLER PIPE FOR ZONE-4 (STAND BY)
D	800 DRAIN PIPE
E	1500 FIRE DOWN COVER
FHC	FIRE HOSE CABINET

PLUMBING LEGEND:-

SW	DOMESTIC WATER SUPPLY
FW	FLOORING WATER SUPPLY
MT	MULTI FLOOR TRAP
FT	FLOOR TRAP
UT	URINAL TRAP
FD	FLOOR DRAIN
FCO	FLOOR CLEAN OUT PLUG
COP	CLEAN OUT PLUG
BD	BALCONY DRAIN
DP	DRAIN POINT

This is a "PROVISIONAL BUILDING PLAN" approved only for the purpose of inviting objections from the general public.

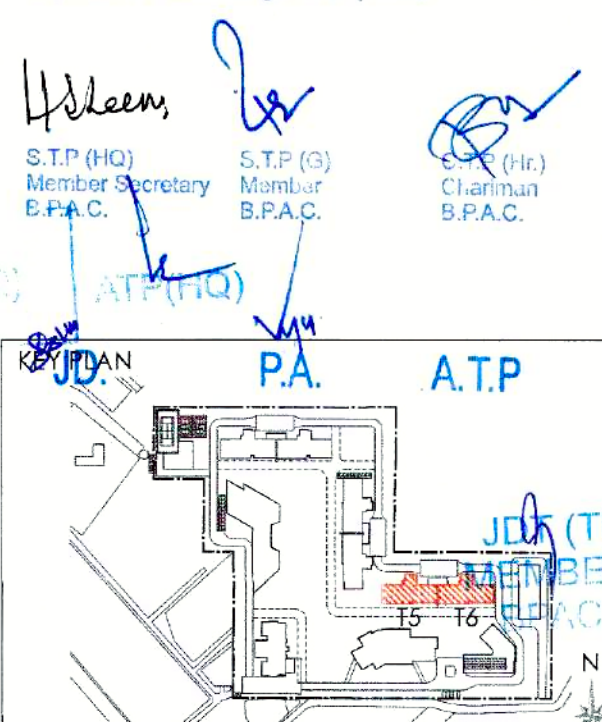

NOTES

DOOR/WINDOW SCHEDULE (TOWERS)

S. NO.	DOOR NO.	WIDTH	HEIGHT	DOORS	LOCATIONS	R/R RATINGS
1	D2	1050	2400	0	Bedroom	
2	D3	900	2400	0	Kitchen	
3	D4	800	2400	0	Staircase	
4	D5	1200	2400	0	GF - H. Toilet	
5	D6	2400	2400	0	Staircase	
6	D7	2400	2400	0	M. Bedroom	
7	D8	2400	2400	0	Bedroom	
8	D9	2400	2400	0	Bedroom	
9	D10	2400	2400	0	Living/Dining	
10	D11	2400	2400	0	Living/Dining	
11	D12	2400	2400	0	M. Bedroom	
12	D13	2400	2400	0	M. Bedroom	
13	D14	2400	2400	0	M. Bedroom	
14	D15	2400	2400	0	M. Bedroom	
15	D16	2400	2400	0	WC	
16	D17	2400	2400	0	WC	
17	D18	2400	2400	0	Utility	
18	D19	2400	2400	0	Kitchen	
19	D20	2400	2400	0	Staircase	
20	D21	2400	2400	0	M. Toilet	
21	D22	2400	2400	0	Bedroom	
22	D23	2400	2400	0	Staircase	
23	D24	2400	2400	0	Staircase	
24	D25	2400	2400	0	M. Toilet	
25	D26	2400	2400	0	Bedroom	
26	D27	2400	2400	0	Staircase	
27	D28	2400	2400	0	Staircase	
28	D29	2400	2400	0	GF Lift Lobby	
29	D30	2400	2400	0	GF Lobby	
30	D31	2400	2400	0	GF Lobby	
31	D32	2400	2400	0	GF Lobby	
32	D33	2400	2400	0	GF Lobby	
33	D34	2400	2400	0	GF Lobby	
34	D35	2400	2400	0	GF Lobby	
35	D36	2400	2400	0	GF Lobby	
36	D37	2400	2400	0	GF Lobby	
37	D38	2400	2400	0	GF Lobby	
38	D39	2400	2400	0	GF Lobby	
39	D40	2400	2400	0	GF Lobby	
40	D41	2400	2400	0	GF Lobby	
41	D42	2400	2400	0	GF Lobby	
42	D43	2400	2400	0	GF Lobby	
43	D44	2400	2400	0	GF Lobby	
44	D45	2400	2400	0	Entrance	
45	D46	2400	2400	0	Staircase	
46	D47	2400	2400	0	Staircase	
47	D48	2400	2400	0	Staircase	
48	D49	2400	2400	0	Staircase	
49	D50	2400	2400	0	Staircase	
50	D51	2400	2400	0	Staircase	
51	D52	2400	2400	0	Staircase	
52	D53	2400	2400	0	Staircase	
53	D54	2400	2400	0	Staircase	
54	D55	2400	2400	0	Staircase	
55	D56	2400	2400	0	Staircase	
56	D57	2400	2400	0	Staircase	
57	D58	2400	2400	0	Staircase	
58	D59	2400	2400	0	Staircase	
59	D60	2400	2400	0	Staircase	
60	D61	2400	2400	0	Staircase	
61	D62	2400	2400	0	Staircase	
62	D63	2400	2400	0	Staircase	
63	D64	2400	2400	0	Staircase	
64	D65	2400	2400	0	Staircase	
65	D66	2400	2400	0	Staircase	
66	D67	2400	2400	0	Staircase	
67	D68	2400	2400	0	Staircase	
68	D69	2400	2400	0	Staircase	
69	D70	2400	2400	0	Staircase	
70	D71	2400	2400	0	Staircase	
71	D72	2400	2400	0	Staircase	
72	D73	2400	2400	0	Staircase	
73	D74	2400	2400	0	Staircase	
74	D75	2400	2400	0	Staircase	
75	D76	2400	2400	0	Staircase	
76	D77	2400	2400	0	Staircase	
77	D78	2400	2400	0	Staircase	
78	D79	2400	2400	0	Staircase	
79	D80	2400	2400	0	Staircase	
80	D81	2400	2400	0	Staircase	
81	D82	2400	2400	0	Staircase	

CLIENT
Birla Estates Pvt. Ltd. in collaboration with Barmat India Pvt. Ltd.

PROOF CHECK CONSULTANT
Skeleton Consultants Pvt. Ltd.
2nd Floor, A-75, Sector 5, Noida, Uttar Pradesh-201301

GEO TECHNICAL CONSULTANT
Cengs Geotechnical Pvt. Ltd.
A-100, Sector 63, Noid