


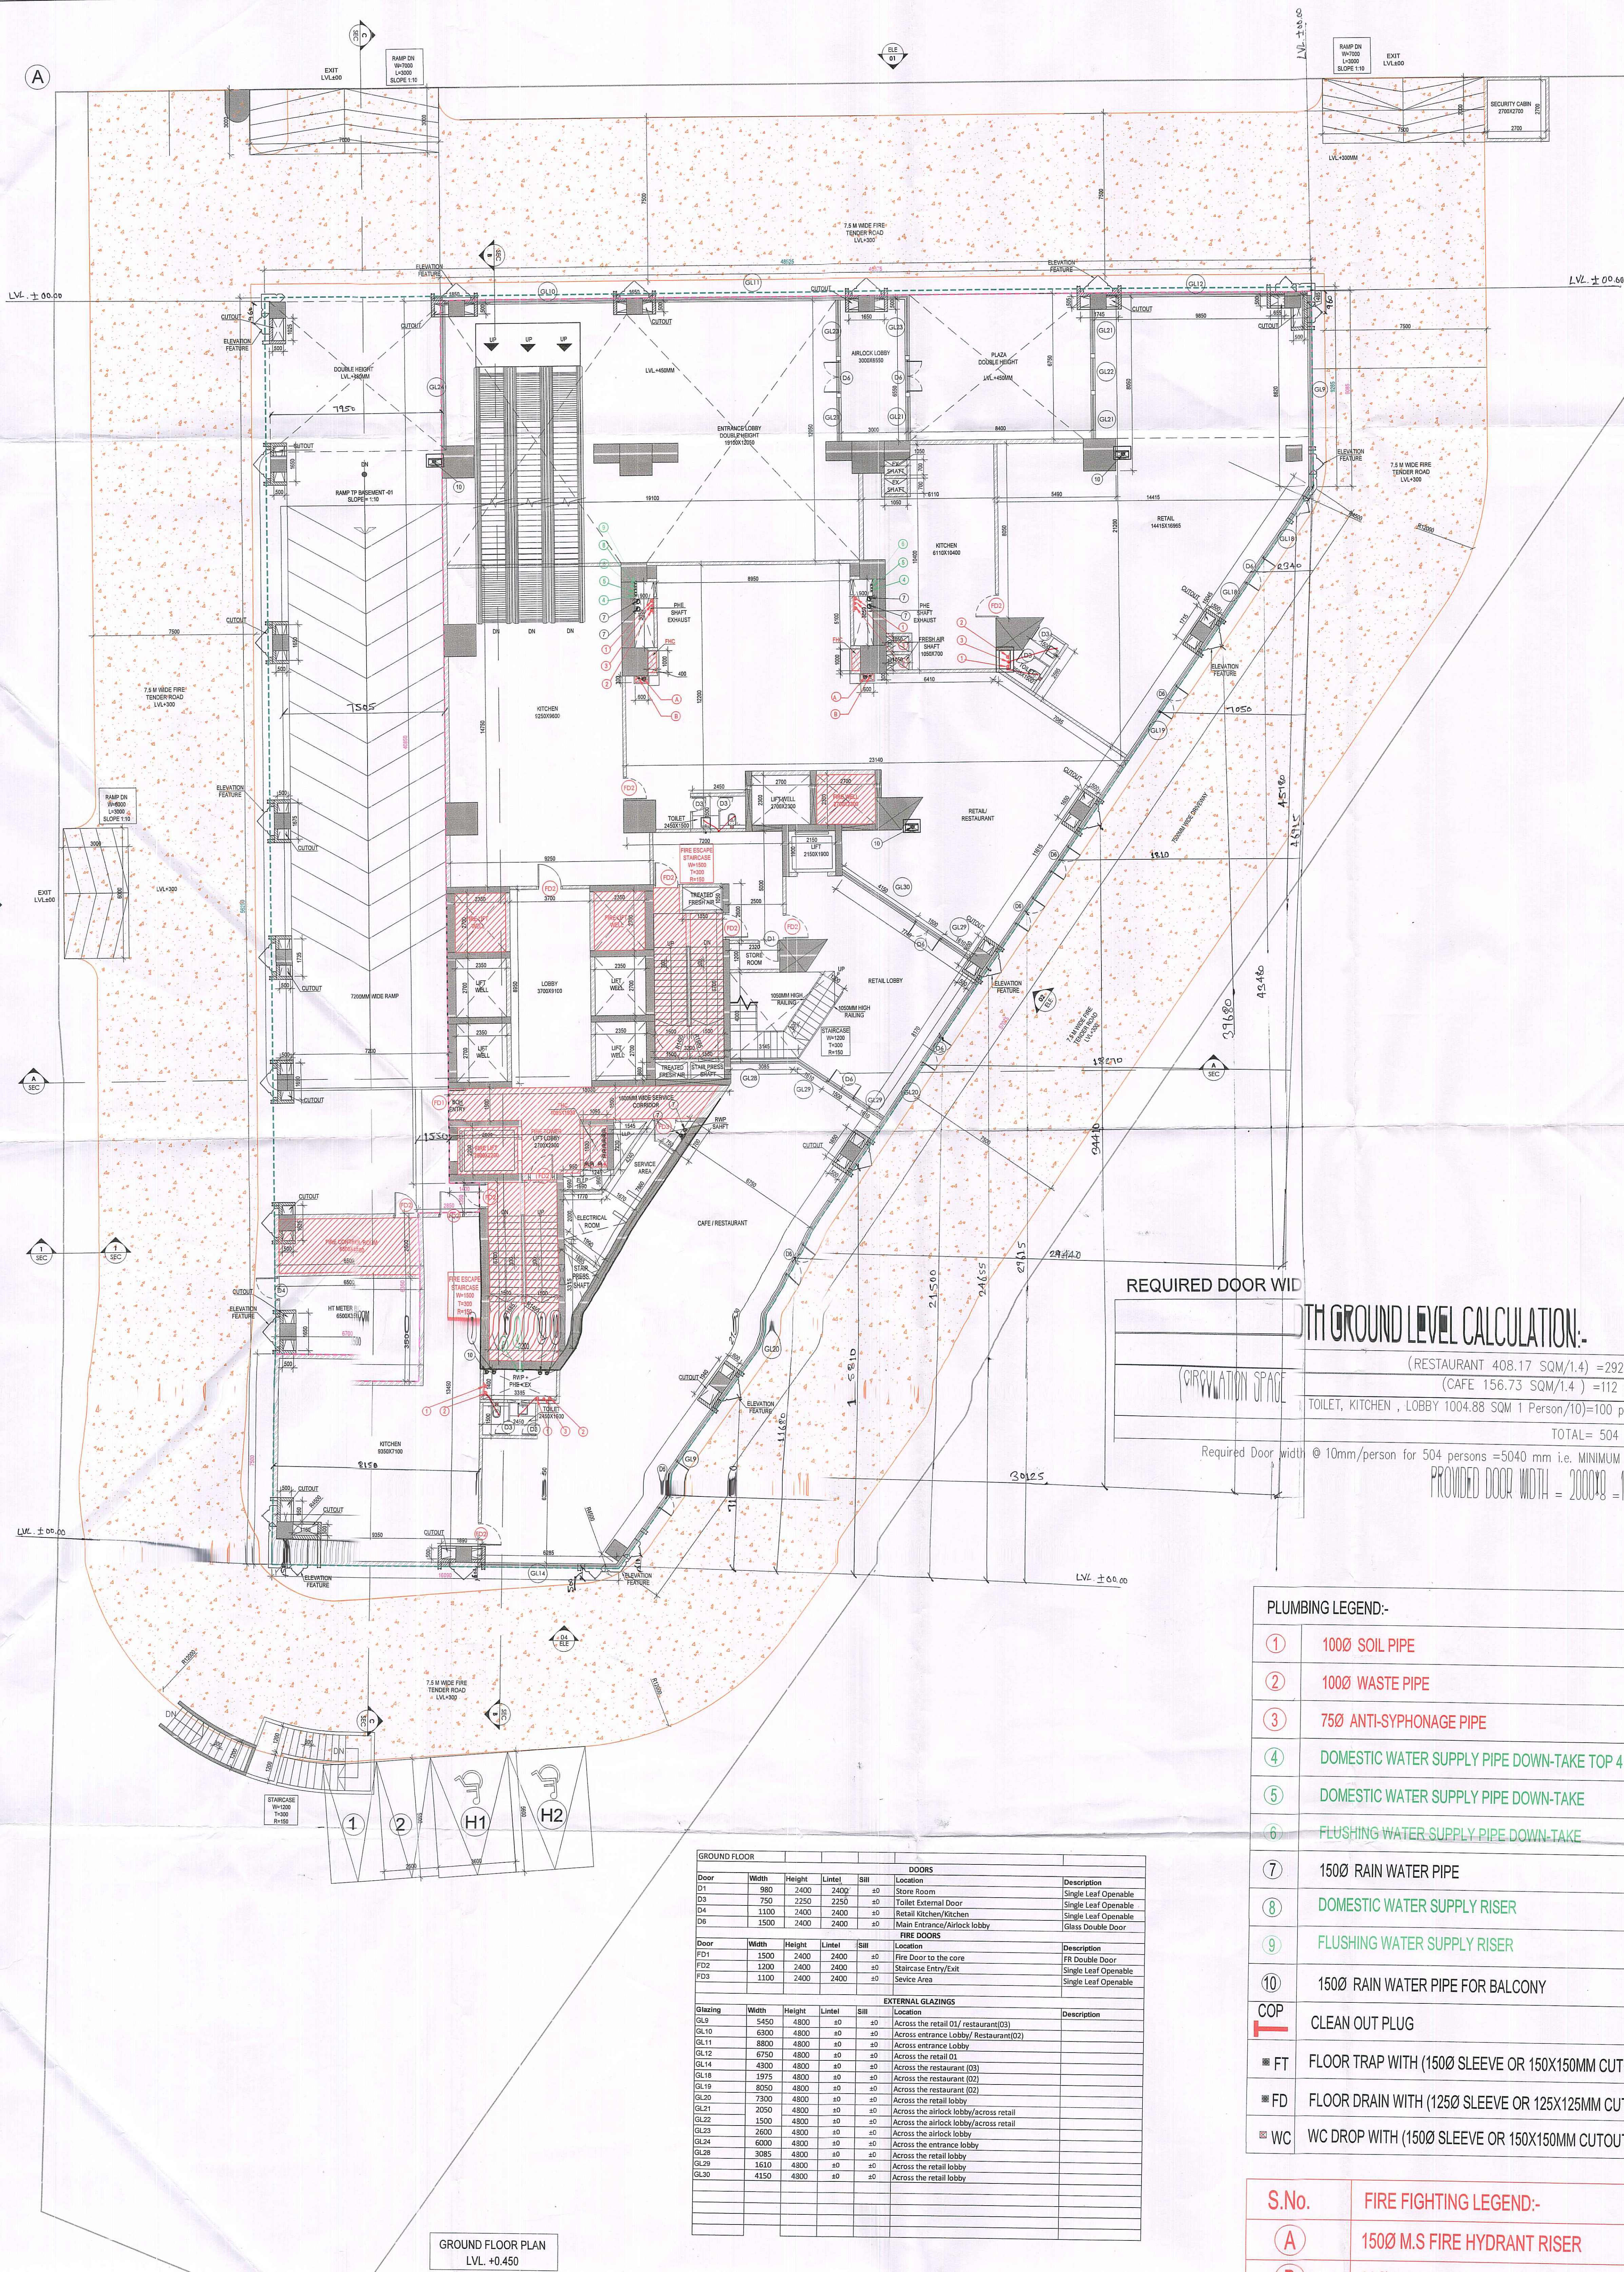

### REQUIRED DOOR WIDTH WITH GROUND LEVEL CALCULATION.

(RESTAURANT 408.17 SQM/1.4) = 292 persons  
(CAFE 156.73 SQM/1.4) = 112 persons  
TOILET, KITCHEN, LOBBY 1004.88 SQM 1 Person/10 = 100 persons  
TOTAL = 504 persons  
Required Door width @ 10mm/person for 504 persons = 5040 mm i.e. MINIMUM 5250 MM.  
PROVIDED DOOR WIDTH = 2000\*3 = 6000MM

#### PLUMBING LEGEND:-

- 1000 SOIL PIPE
- 1000 WASTE PIPE
- 750 ANTI-SYPHONAGE PIPE
- DOMESTIC WATER SUPPLY PIPE DOWN-TAKE TOP 4 FLOOR
- DOMESTIC WATER SUPPLY PIPE DOWN-TAKE
- FLUSHING WATER SUPPLY PIPE DOWN-TAKE
- 1500 RAIN WATER PIPE
- DOMESTIC WATER SUPPLY RISER
- FLUSHING WATER SUPPLY RISER
- 1500 RAIN WATER PIPE FOR BALCONY
- CLEAN OUT PLUG
- FLOOR TRAP WITH (1500 SLEEVE OR 150X150MM CUTOUT)
- FLOOR DRAIN WITH (1250 SLEEVE OR 125X125MM CUTOUT)
- WC DROP WITH (1500 SLEEVE OR 150X150MM CUTOUT)

#### S.No. FIRE FIGHTING LEGEND:-

- 1500 M.S FIRE HYDRANT RISER
- 800 M.S DRAIN PIPE
- 1500 M.S SPRINKLER RISER
- 1500 M.S SPRINKLER RISER
- FIRE HOSE CABINET

Checked and found ok for Public Health  
(Internal) Service only subject to comments in  
a forwarding letter.

Note: Supervising Engineer (HQ)  
for Chief Engineer-1  
HVP, Faridkot

ALL FLOOR MECHANICAL VENTILATED  
LIGHTED & 100% POWER BACKUP.  
AIR CONDITIONING SYSTEM IS BEING PROVIDED  
DG POWER BACKUP IS BEING PROVIDED.  
TOILET ARE MECHANICALLY VENTILATED.  
ALL LIFTS SHALL HAVE POWER BACK-UP.  
ALL ELECTRICAL INSTALLATION SHALL BE AS  
PER PROVISION OF RELEVANT CODE.  
FIRE/FIGHTING/SAFETY PROVISIONS WILL BE  
AS PER RELEVANT CODE PROVISIONS.  
BASEMENT AREA SHALL HAVE MECHANICALLY  
VENTILATED AS PER RELEVANT CODE.  
ALL TOILETS ARE VENTILATED AS PER  
HARYANA BUILDING CODE 2017.  
BUILDINGS HAS AUTOMATIC SPRINKLER  
SYSTEM WHEREVER REQUIRED BY RELEVANT  
CODE. BUILDINGS WILL BE DESIGNED  
(STRUCTURES) AS PER RELEVANT  
I.S. CODES FOR EARTHQUAKE RESISTANCE.  
SOLAR PANELS OF REQUIRED CAPACITY SHALL  
BE PROVIDED AS PER HARE DAZONING  
NORMS.  
ALL HANDICAP RAMPS WITH RAILING.  
ALL FIRE FIGHTING INSTALLATIONS SHALL BE  
AS PER PROVISION OF RELEVANT CODE.  
THE RAINWATER HARVESTING SYSTEM SHALL  
BE PROVIDED AS PER CENTRAL GROUND  
WATER AUTHORITY NORMS.

#### PROJECT:-

PROPOSED BUILDING PLAN OF COMMERCIAL  
COMPLEX SITE AREA 1.186 ACRES  
(4943.93 SQM) IN SECTOR 28, GURUGRAM

#### OWNER'S

ACQUISITIVE INFRADEVELOPERS PVT. LTD.  
WITH LODHA DEVELOPERS LIMITED.

#### OWNER'S SEAL & SIGNATURE

For ACQUISITIVE INFRADEVELOPERS PVT. LTD.  
Authorized Signatory

#### ARCHITECT'S SEAL & SIGNATURE



MAY-2026 Scale : 1:100

Drawing Title:-

TOWER 01  
GROUND FLOOR PLAN

DTF (HQ)  
Member  
BPAC

STB (HQ)  
Member Secretary  
BPAC

CTP  
Chairman  
BPAC

ACFO, (HQ)  
Member  
BPAC

FSC (HQ)  
Member  
BPAC