


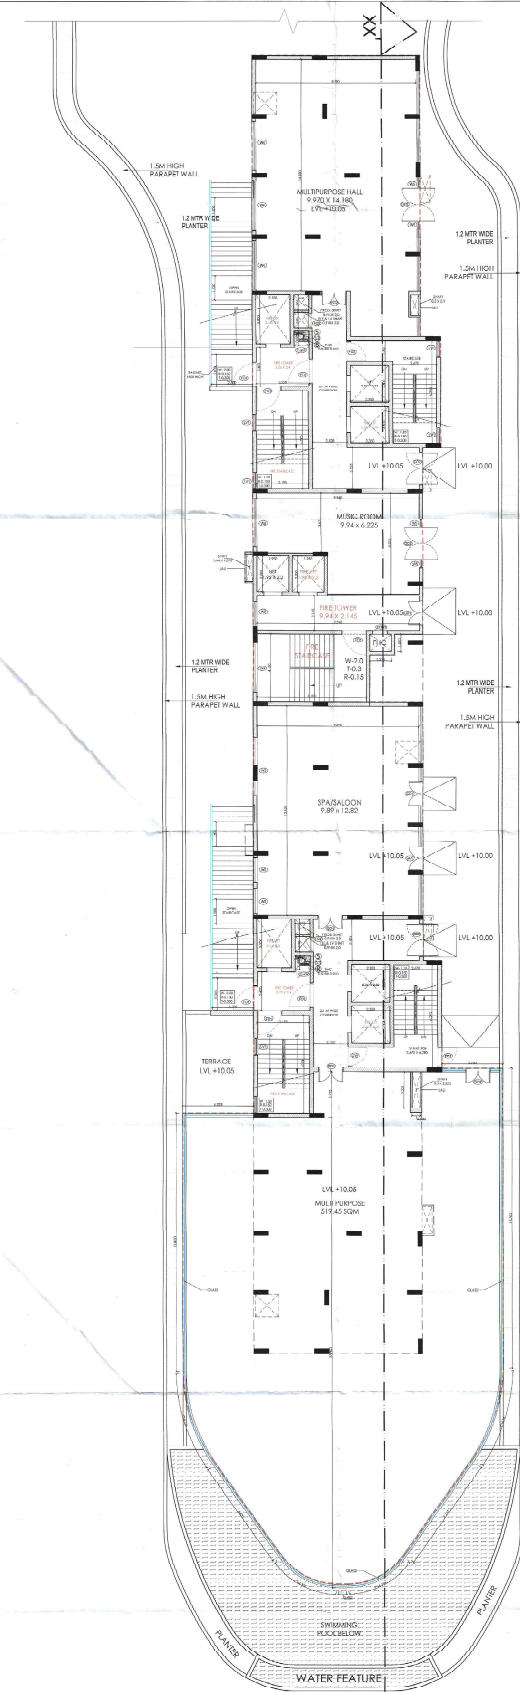

SECOND/PODIUM-3 FLOOR PLAN

FLOOR AREA	C.O.P.F.A.C.T.O.R	C.O.C.C.U.P.A.N.C.Y	REQUIRED DWT WITH @ 100MM ²	PROPOSED DWT WITH 7.5M
854	1.8	4.5		

LEGEND	Type	Length (m)	Width (m)	NO.	Area (sq.m)
C1	Rectangular	6.455	1.17	1	7.551
C2	Rectangular	3.002	1.17	1	3.513
C3	Rectangular	3.002	1.17	1	3.513
C4	Rectangular	2.705	1.17	1	3.166
C5	Rectangular	3.225	1.17	1	3.773
C6	Rectangular	3.225	1.17	1	3.773
C7	Rectangular	3.225	1.17	1	3.773
C100	Rectangular	3.225	1.17	1	3.773

SECOND/PODIUM 3-FLOOR PLAN AREA DIAGRAM

- HIRE LIGHTING LEGEND**
- 1500 ALTERNATE RISER SPRINKLER PIPE FOR ZONE-01
 - 1500 ALTERNATE RISER SPRINKLER PIPE FOR ZONE-02
 - 1500 ALTERNATE RISER SPRINKLER PIPE FOR ZONE-03
 - 1500 ALTERNATE RISER SPRINKLER PIPE FOR ZONE-04
 - 1500 SPRINKLER PIPE FOR ZONE-01
 - 1500 SPRINKLER PIPE FOR ZONE-02
 - 1500 SPRINKLER PIPE FOR ZONE-03
 - 1500 SPRINKLER PIPE FOR ZONE-04
 - 1500 HYDRANT PIPE FOR ZONE-01
 - 1500 HYDRANT PIPE FOR ZONE-02
 - 1500 HYDRANT PIPE FOR ZONE-03
 - 1500 HYDRANT PIPE FOR ZONE-04
 - 800 DRAIN PIPE

- PLUMBING LEGEND**
- | S.NO. | SYMBOL | DESCRIPTION |
|-------|----------------------------------|----------------------------------|
| 1 | 160 OD UPVC SOIL PIPE | 160 OD UPVC SOIL PIPE |
| 2 | 160 OD UPVC WAIST PIPE | 160 OD UPVC WAIST PIPE |
| 3 | 7500 ANTI-SIPHONIC PIPE | 7500 ANTI-SIPHONIC PIPE |
| 4 | DOMESTIC WATER SUPPLY PIPE | DOMESTIC WATER SUPPLY PIPE |
| 5 | FLUSHING WATER SUPPLY PIPE | FLUSHING WATER SUPPLY PIPE |
| 6 | DOMESTIC WATER SUPPLY RISER PIPE | DOMESTIC WATER SUPPLY RISER PIPE |
| 7 | FLUSHING WATER SUPPLY RISER PIPE | FLUSHING WATER SUPPLY RISER PIPE |
| 8 | 160 OD RAIN WATER PIPE | 160 OD RAIN WATER PIPE |
| 9 | 7500 RAIN WATER PIPE | 7500 RAIN WATER PIPE |

DOOR WINDOW SCHEDULE FOR TOWER A & B

TYPE	WIDTH	HEIGHT	CILL	UNTEL
D1	1200	2400	-	2400
D2	1100	2400	-	2400
D3	900	2400	-	2400
D4	750	2100	-	2100
D5	1000	2400	-	2400
D6	1200	2400	-	2400
D7	1500	2400	-	2400
D8	1800	2400	-	2400
D100	29400	2400	-	2400

NOTES:

ALL DIMENSIONS ARE IN METERS (M) UNLESS OTHERWISE SPECIFIED.

ALL ARCHITECTURAL DRAWINGS SHALL BE READ IN CONJUNCTION WITH STRUCTURAL AND OTHER MPP, ETC., DRAWINGS.

ANY DISCREPANCY IF FOUND SHALL BE REPORTED TO THE PROJECT MANAGEMENT CONSULTANT IMMEDIATELY.

ALL LEVELS INDICATED ARE THE FINISHED FLOOR LEVELS, UNLESS OTHERWISE SPECIFIED.

DRAWINGS ARE NOT TO BE MEASURED, ONLY WRITTEN DIMENSIONS ARE TO BE FOLLOWED.

ALL LIFE, STAIRCASE, AND SERVICE AREA ARE UNDER 100% POWER BACKUP.

PROJECT TITLE

Proposed building plan of Gurgaon Housing Colony for an area measuring 5.0752 acres

Licence No. 259 of 2025 dated 23.12.2025 in Sector 63.4, Gurgaon, Haryana Urban complex being developed by M/s. ANANT RAJ LIMITED

OWNER SIGN:

DEVELOPER

ANANT RAJ LIMITED H-65 CONNAUGHT CIRCUS NEW DELHI-110001

MPP CONSULTANTS

KPMG

KUMAR ENDECON PVT. LTD.
ENGINEERING DESIGN CONSULTANTS
40505 GROUND FLOOR CHITRAKUT PARK
NEW DELHI-110019
E-mail: info@endecon.in

STRUCTURAL CONSULTANTS

CHAPMAN TAYLOR
INDIAN REGISTERED & ISO 9001 CERTIFIED
Chapman Taylor India LLP
A 1718 First Floor
Saket, New Delhi - 110029
Tel: +91-11-40018005

ARCHITECTS

CHAPMAN TAYLOR
INDIAN REGISTERED & ISO 9001 CERTIFIED
Chapman Taylor India LLP
A 1718 First Floor
Saket, New Delhi - 110029
Tel: +91-11-40018005

DRAWING TITLE

COMMUNITY CENTER
SECOND/PODIUM 3 FLOOR PLAN
& AREA DIAGRAM

DATE: 20/01/2025
CHECKED BY: [Signature]
DESIGNED BY: [Signature]
SCALE: 1:100
ORIG. NO: C1/SUB/ARC/002
DATE: 1/3/2025