


Building Plans Sanction and Plans will be valid for five year only
 To be read with Memo No. 1206
 Dated 29/10/2023 to 28/10/2030

Chairman Building Plan Committee cum Senior Town Planner
 HSIIDC, IMT Manesar

Recommended for Sanction
 ATP
 H. Guleria
 J. Jaiswal

PLUMBING VERTICAL PIPES SCHEDULES--		
1		100Ø SOIL PIPE
2		100Ø WASTE PIPE
3		75Ø VENT PIPE
4		DOMESTIC WATER SUPPLY MAIN PIPE
4A		DOMESTIC BOOSTER WATER SUPPLY PIPE
5		DOMESTIC WATER SUPPLY BRANCH PIPE
6		FLUSHING WATER SUPPLY BRANCH PIPE
7		FLUSHING WATER SUPPLY MAIN PIPE
8		DOMESTIC WATER RISER TO OHT
9		FLUSHING WATER RISER TO OHT
R		100Ø ROOF RAIN WATER PIPE
R1		75Ø BALCONY RAIN WATER PIPE
		(FD) FLOOR DRAIN
		(FT) FLOOR TRAP
		(BD) BALCONY DRAIN PIPE

PLUMBING LEGEND--			
S.NO.	ABBREVIATION	SYMBOL	DISCRIPTION
1	WP		100Ø WASTE PIPE
2	WP		FD TO FT 50Ø WASTE PIPE
3	WP		32Ø WASTE PIPE
4	SP		100Ø SOIL PIPE
5	DWS		DOMESTIC WATER SUPPLY
6	FWS		FLUSHING WATER SUPPLY
7	BV/BFV		BALL/BUTTER FLY VALVE

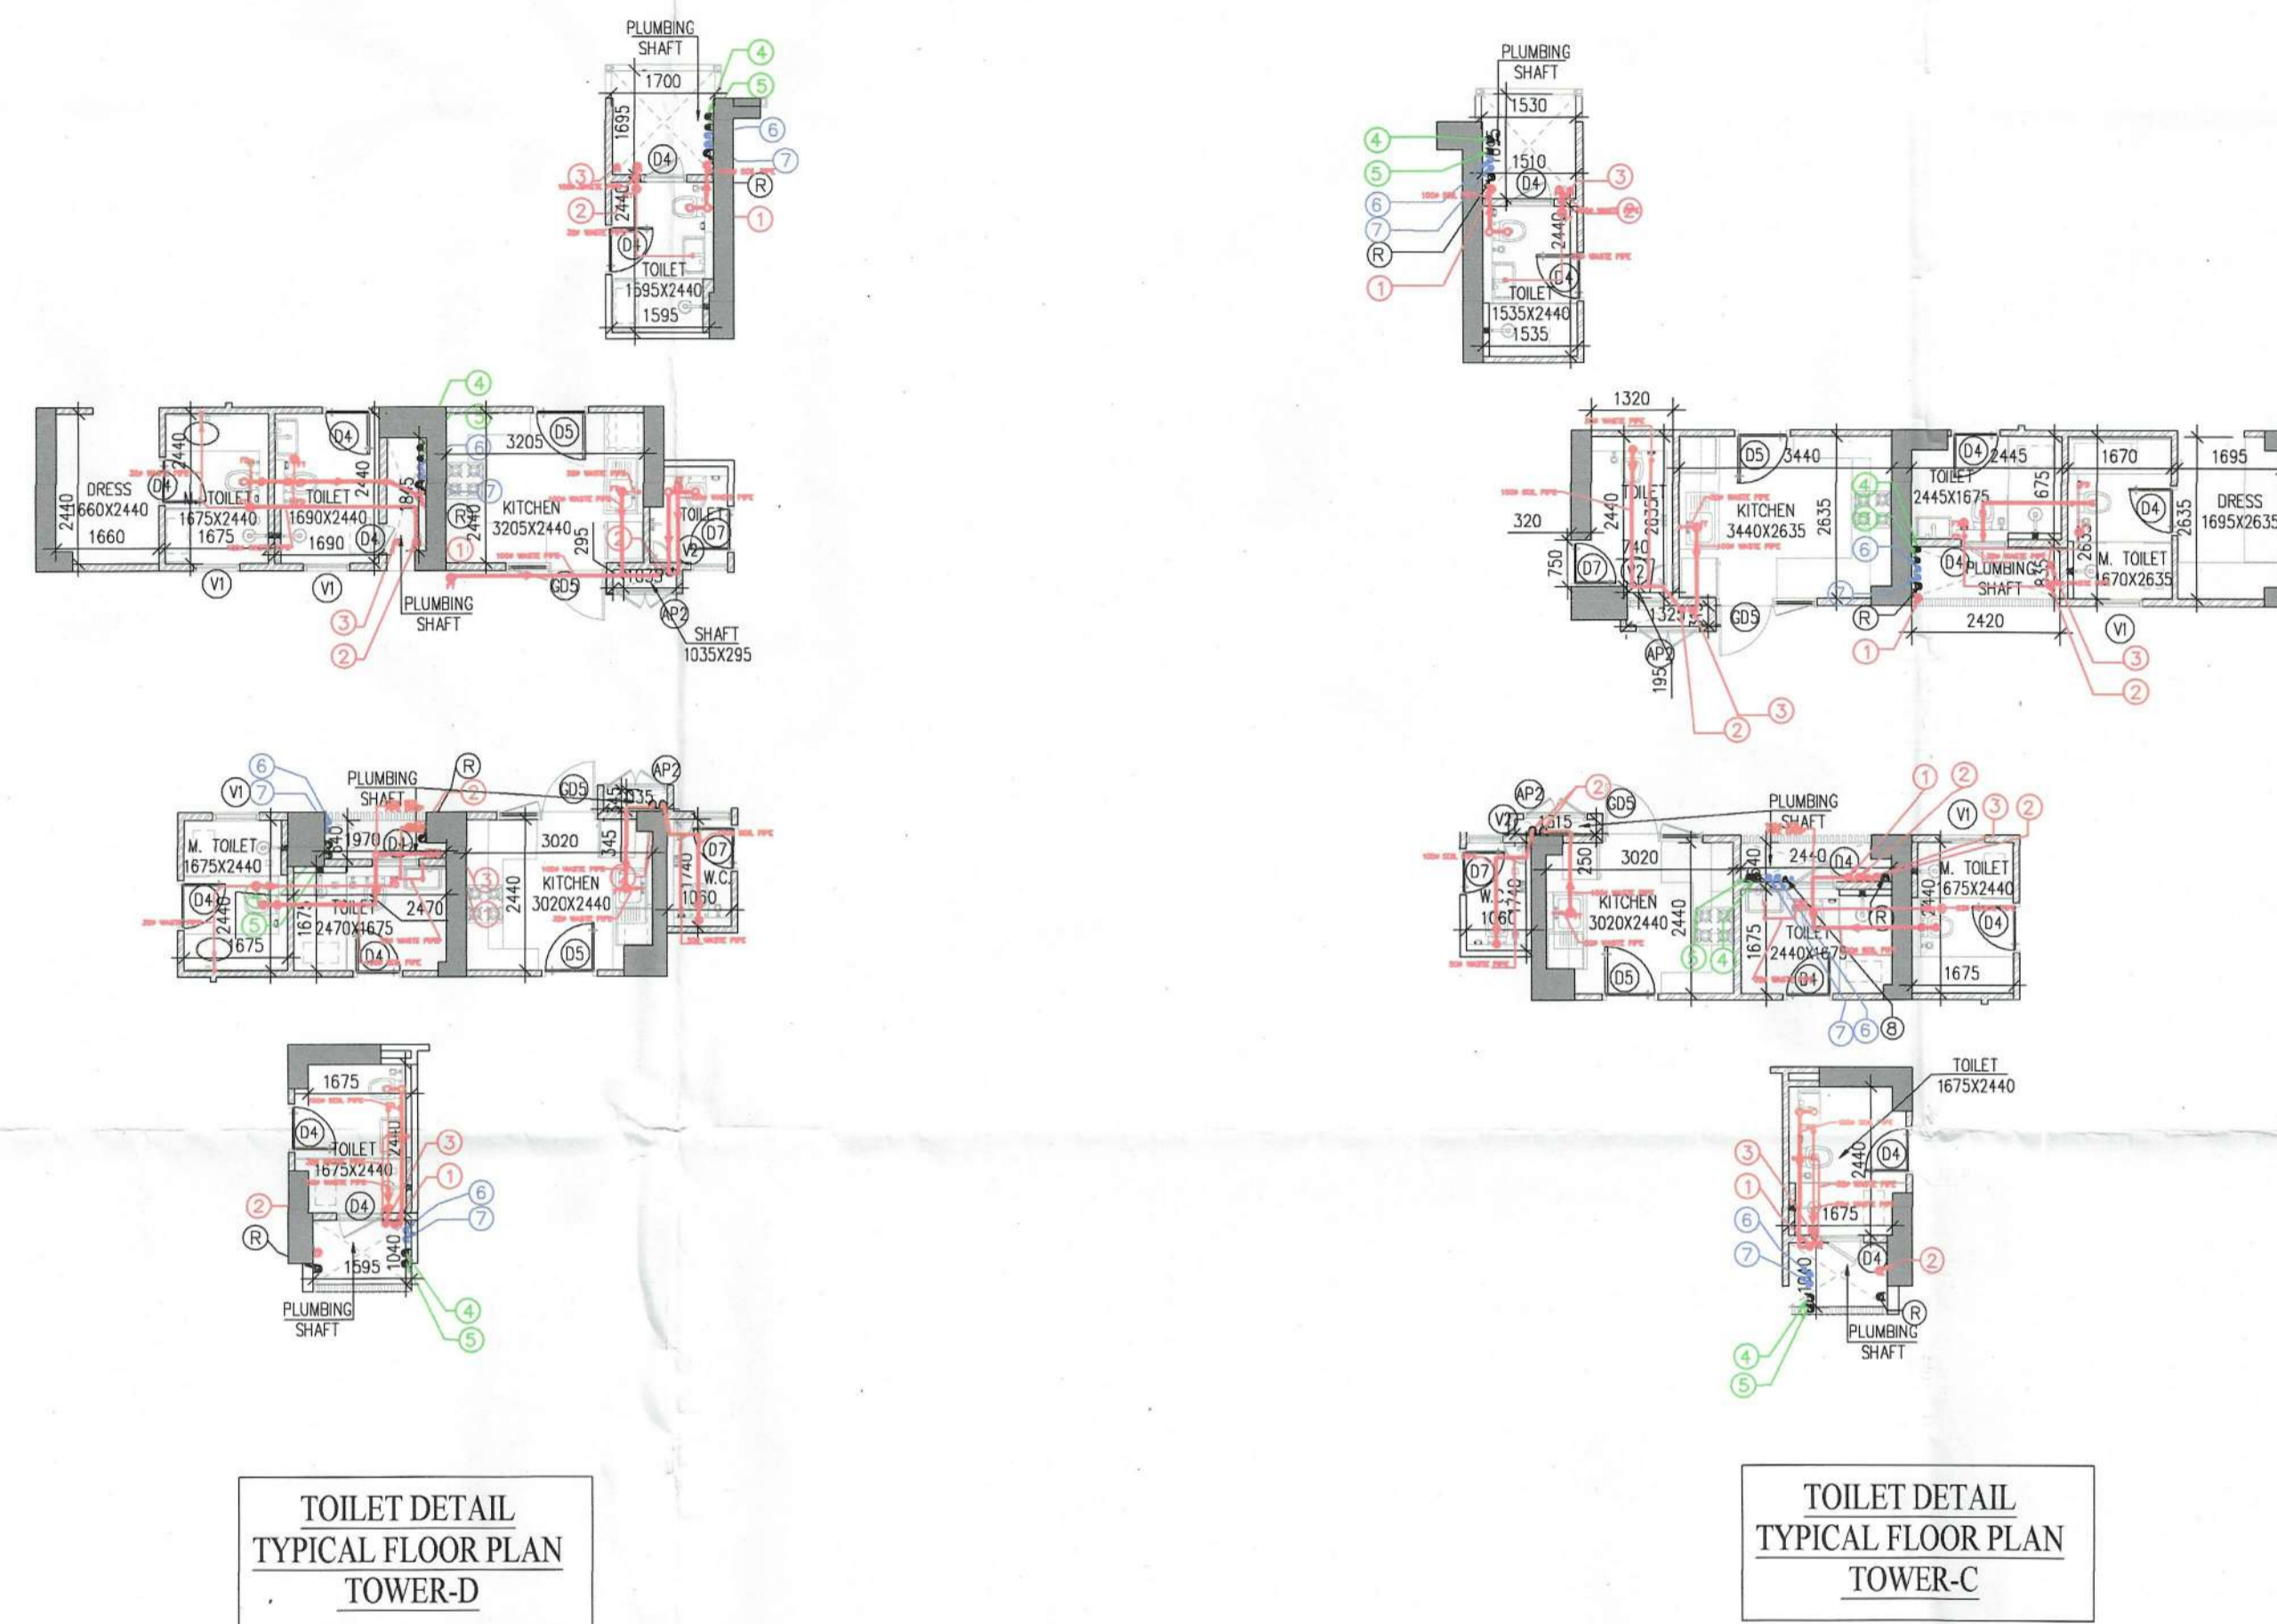

Note :-

- BUILDING HAS AUTOMATIC SPRINKLER SYSTEM WHEREVER REQUIRED BY NBC.
- BUILDING WILL BE DESIGNED (STRUCTURES) AS PER RELEVANT IS CODES FOR EARTH QUAKE RESISTANCE.
- POWER BACKUP/ MECHANICAL VENTILATED SHAFTS.

PROJECT:

PROPOSED BUILDING PLAN FOR PHASE-2 & 2A OF GROUP HOUSING SITE PLOT NO. GH-03 SITUATED AT SECTOR-80, MANESAR AREA ADMEASURING 22501 SQMTRS BEING DEVELOPED BY CONSCIENT INFRASTRUCTURE PVT. LTD.

ASSOCIATE ARCHITECTS



PLOT NO-408 SEC-37C GURGAON (PH-9560794794)

OWNER'S SEAL & SIGNATURE



ARCHITECT'S SEAL & SIGNATURE

Ar. Ravinder Kumar
 CA/2012/55971
 Ph.: 9871004573

SEP.-2025	Scale -1:100	
Drawing Title: - TOWER-C&D TOILET DETAIL		Drawing No: - TD-01