

Note:-
 1. BUILDING HAS AUTOMATIC SPRINKLER SYSTEM WHEREVER REQUIRED BY NBC.
 2. BUILDING WILL BE DESIGNED (STRUCTURES) AS PER REFERENT IS CODES FOR EARTH QUAKE RESISTANCE.
 3. ALL TOILET & KITCHEN HAVE PERMANENT VENTILATION / EXHAUST
 4. ALL BUILDINGS ARE NATURALLY VENTILATED AND WHERE EVER REQUIRED MECHANICAL VENTILATION IS PROPOSED WITH 100% POWER BACKUP.

S.T.P.(G) S.T.P.(H) S.T.P.(M)
 Member/Secretary Member Chairman
 B.P.A.C. B.P.A.C. B.P.A.C.
 Rajesh Dutt SD(HQ)
 AD
 ATP(HQ)
 SANCTIONED
 MEMO NO: 4193
 DATED: 03-11-2025

Project
 PROPOSED BUILDING PLAN OF RESIDENTIAL GROUP HOUSING COLONY OVER AN AREA MEASURING 5.1375 ACRE (LICENSE NO. 62 OF 2025 DATED 01-05-2025) IN SECTOR 103, GURUGRAM BEING DEVELOPED BY GURUGRAM INFRASTRUCTURE AND AIPL BHARAT INFRASTRUCTURE PRIVATE LIMITED IN COLLABORATION WITH AIPL BHARAT INFRASTRUCTURE PRIVATE LIMITED.

Client
 AIPL Bharat Infrastructure Pvt. Ltd.
 AIPL Business Club, 5th Floor, Sector 62, Gurugram 122002, Haryana, IN
 Phone: +91 92111 00000 Ext. 7794

Architects:
 Morphogenesis
 Plot No. 41, Industrial Estate, Okhla Phase-III, New Delhi 110020, India
 TEL: +91 11 41828070
 FAX: 91 11 26490351
 E Mail: studio@morphogenesis.org
 Associate Architects:



SBA Design N Code LLP
 Architecture Codes Interiors
 (Formerly known as S.M.S.L.S.)
 88/88A, 1st Floor, Sector 103, Gurugram, New Delhi 110070.
 Mob: 9810791552, 9811077209


MEP CONSULTANT:
 AEON INTEGRATED BUILDING DESIGN CONSULTANTS LLP
 201/202, 2nd Floor, Sector 103, Gurugram, New Delhi 110070, INDIA

SITE PLAN FIRE FIGHTING LAYOUT

OWNER'S SEAL & SIGNATURE
 AIPL BHARAT INFRASTRUCTURE PRIVATE LIMITED
 Authorised Signatory

ARCHITECT'S SEAL & SIGNATURE
 POOJA NIKHAR
 CA/2012/55585

Scale: 1:400
 Drawing No: ST-02
 SITE PLAN FOR SERVICES
 Drawing Title: A
 02-SEPT-25

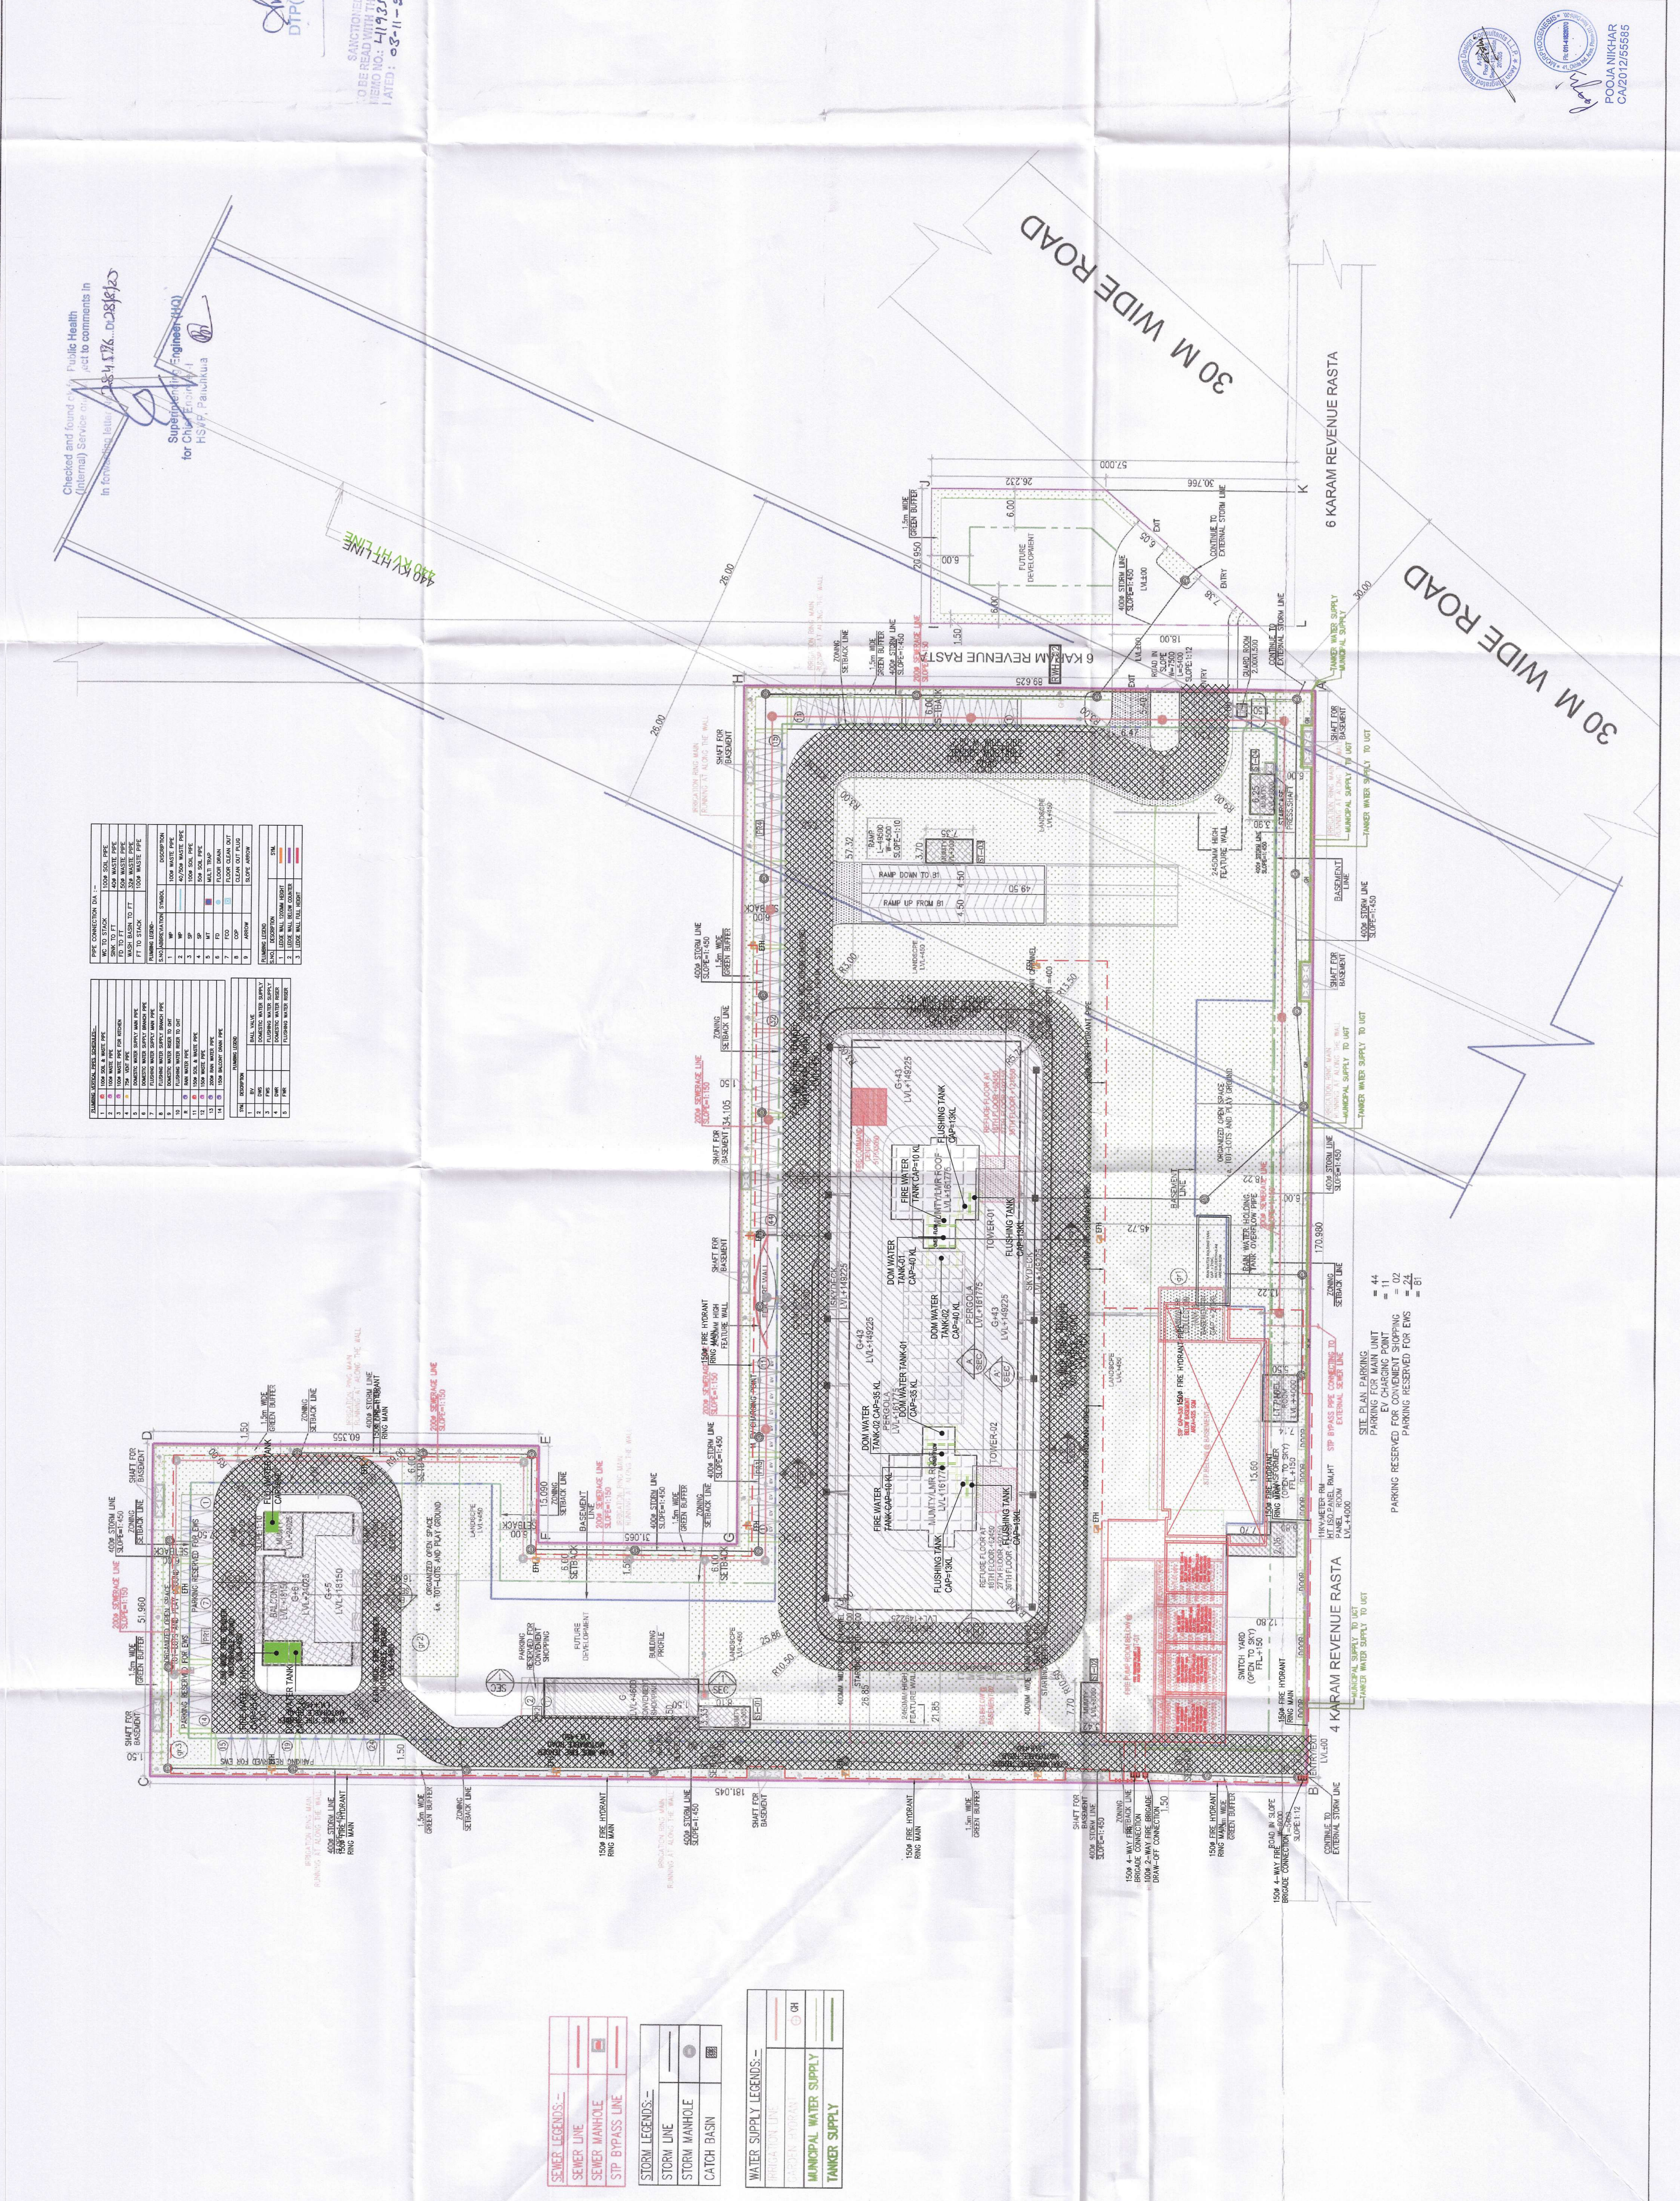

PIPE CONNECTIONS TO STATION	
1. 100MM WATER PIPE	100MM WATER PIPE
2. 150MM WATER PIPE	150MM WATER PIPE
3. 200MM WATER PIPE	200MM WATER PIPE
4. 250MM WATER PIPE	250MM WATER PIPE
5. 300MM WATER PIPE	300MM WATER PIPE
6. 400MM WATER PIPE	400MM WATER PIPE
7. 500MM WATER PIPE	500MM WATER PIPE
8. 600MM WATER PIPE	600MM WATER PIPE
9. 700MM WATER PIPE	700MM WATER PIPE
10. 800MM WATER PIPE	800MM WATER PIPE
11. 900MM WATER PIPE	900MM WATER PIPE
12. 1000MM WATER PIPE	1000MM WATER PIPE
13. 1200MM WATER PIPE	1200MM WATER PIPE
14. 1500MM WATER PIPE	1500MM WATER PIPE
15. 2000MM WATER PIPE	2000MM WATER PIPE
16. 2500MM WATER PIPE	2500MM WATER PIPE
17. 3000MM WATER PIPE	3000MM WATER PIPE
18. 3500MM WATER PIPE	3500MM WATER PIPE
19. 4000MM WATER PIPE	4000MM WATER PIPE
20. 4500MM WATER PIPE	4500MM WATER PIPE
21. 5000MM WATER PIPE	5000MM WATER PIPE
22. 5500MM WATER PIPE	5500MM WATER PIPE
23. 6000MM WATER PIPE	6000MM WATER PIPE
24. 6500MM WATER PIPE	6500MM WATER PIPE
25. 7000MM WATER PIPE	7000MM WATER PIPE
26. 7500MM WATER PIPE	7500MM WATER PIPE
27. 8000MM WATER PIPE	8000MM WATER PIPE
28. 8500MM WATER PIPE	8500MM WATER PIPE
29. 9000MM WATER PIPE	9000MM WATER PIPE
30. 9500MM WATER PIPE	9500MM WATER PIPE
31. 10000MM WATER PIPE	10000MM WATER PIPE

SEWER LEGENDS:-	
SEWER LINE	---
SEWER MANHOLE	⊕
STP BYPASS LINE	---

STORM LEGENDS:-	
STORM LINE	---
STORM MANHOLE	⊕
CATCH BASIN	⊕

WATER SUPPLY LEGENDS:-	
WATER SUPPLY LINE	---
WATER TOWER	⊕
MANHOLES	⊕
MANHOLES WATER SUPPLY	⊕
TANKER SUPPLY	⊕

44 = SITE PLAN PARKING
 11 = PARKING FOR MAIN UNIT
 22 = PARKING RESERVED FOR EKS
 81 = PARKING RESERVED FOR EKS